
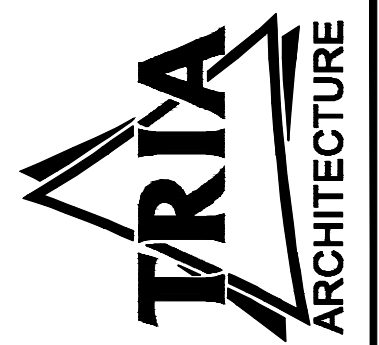
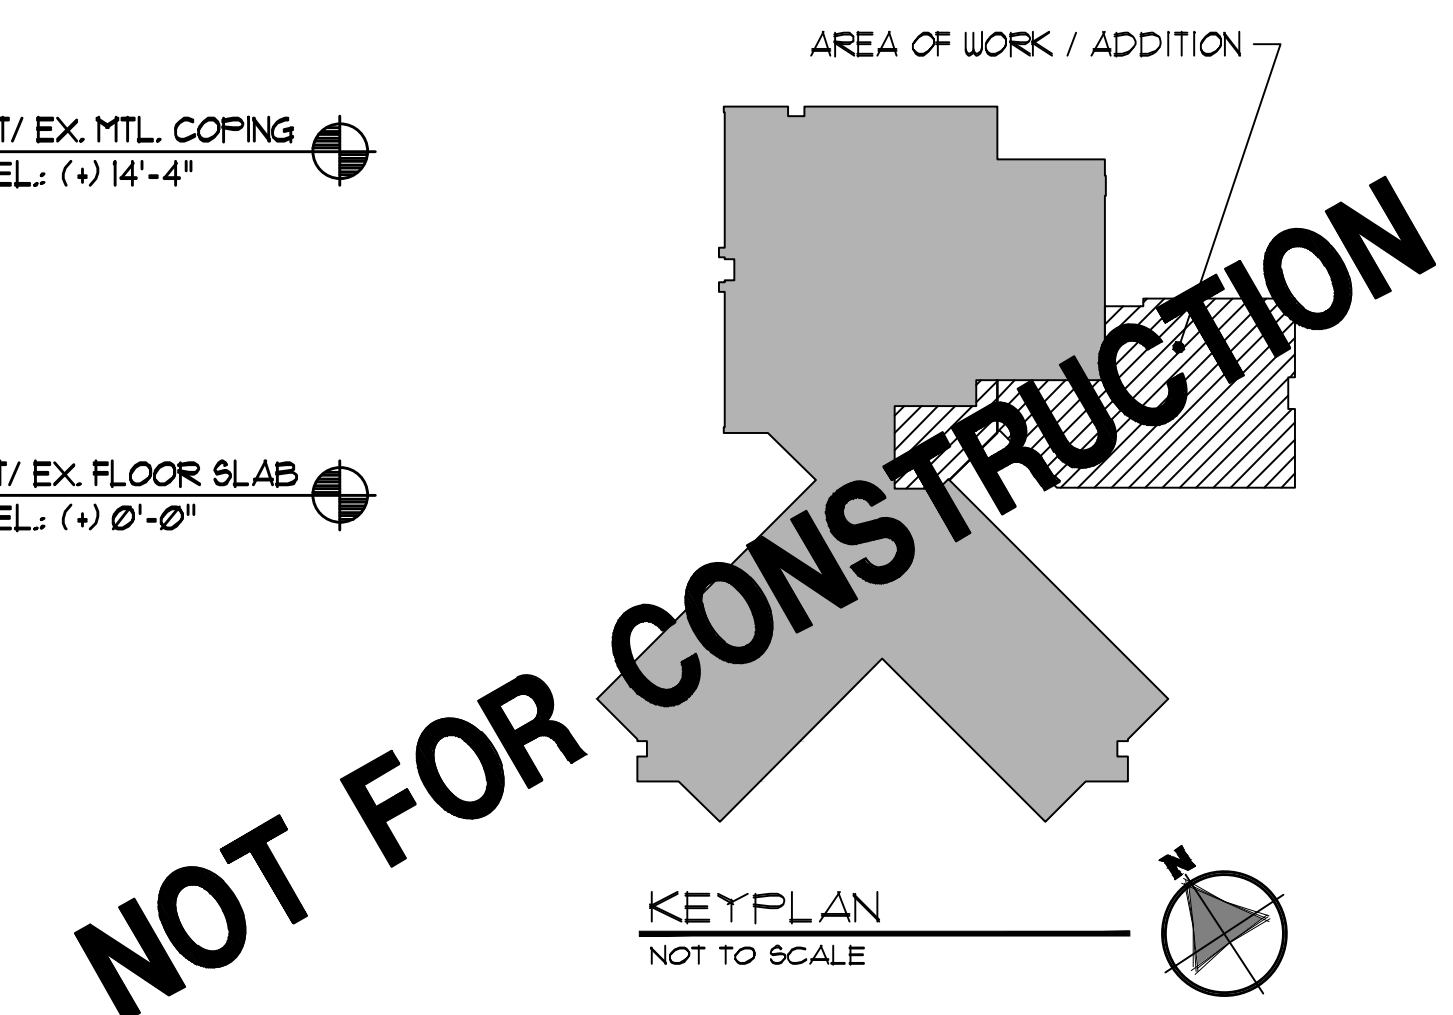
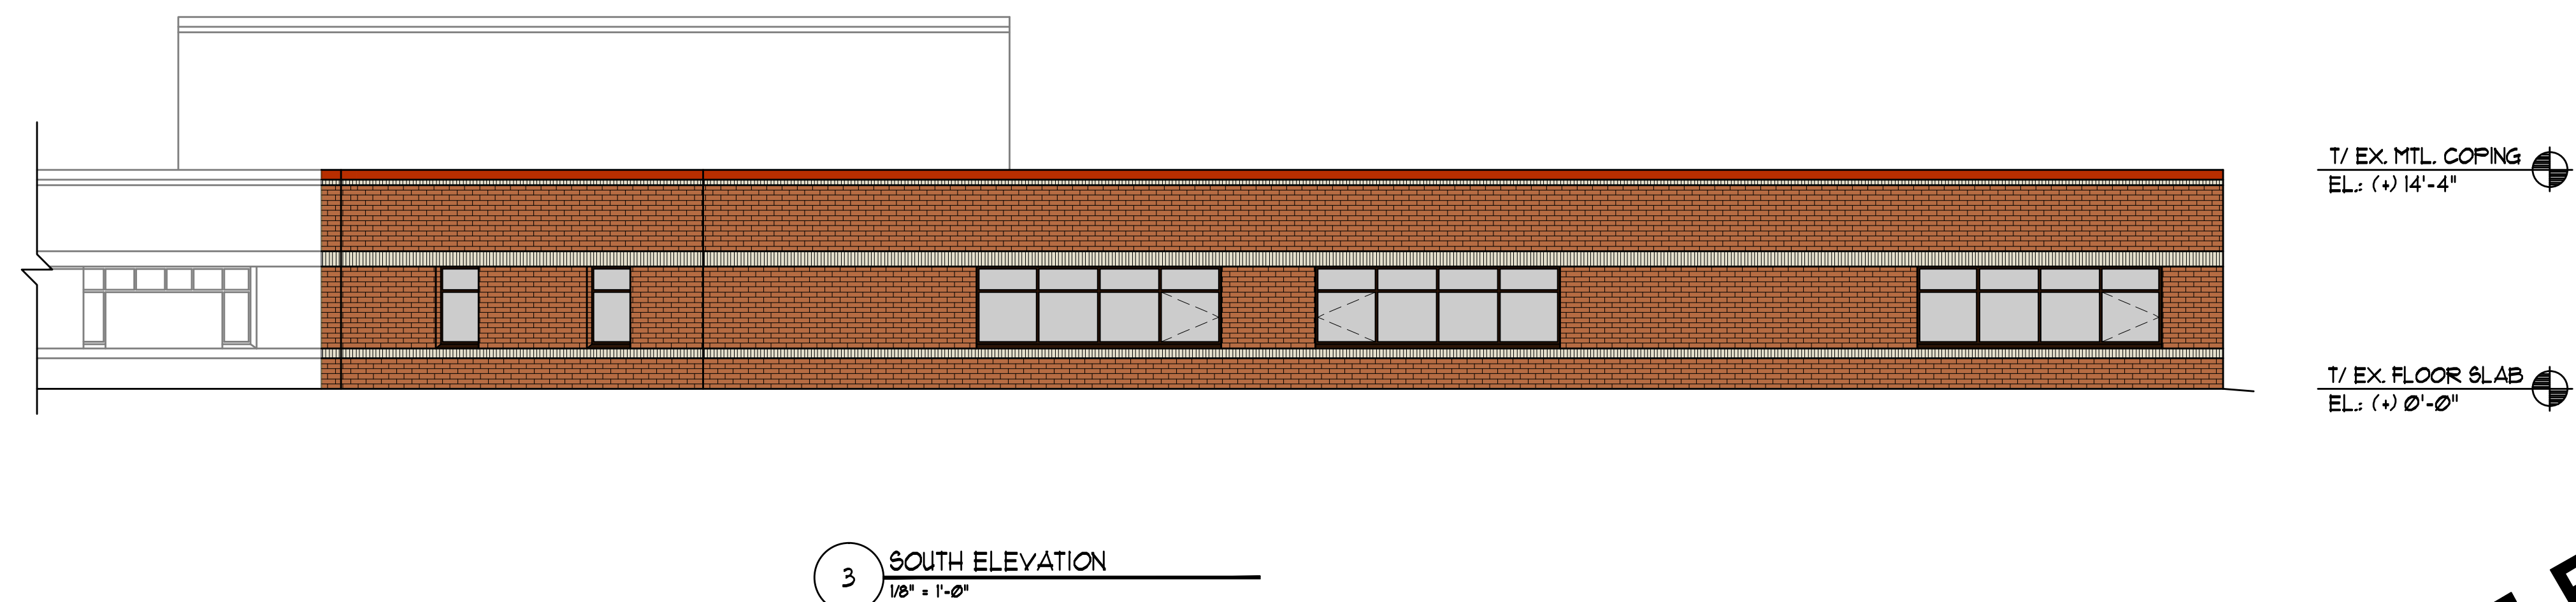
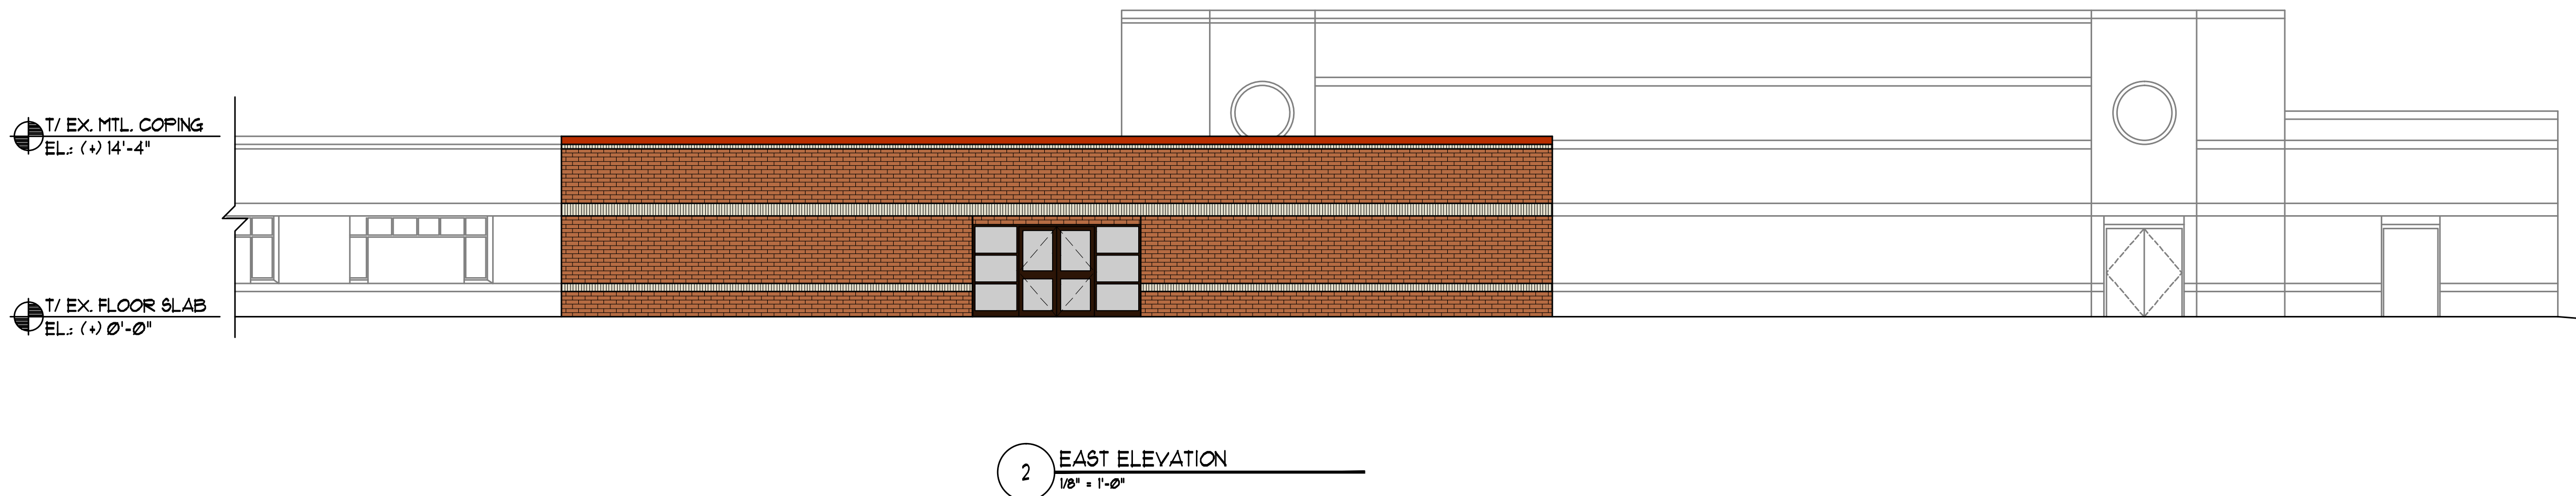


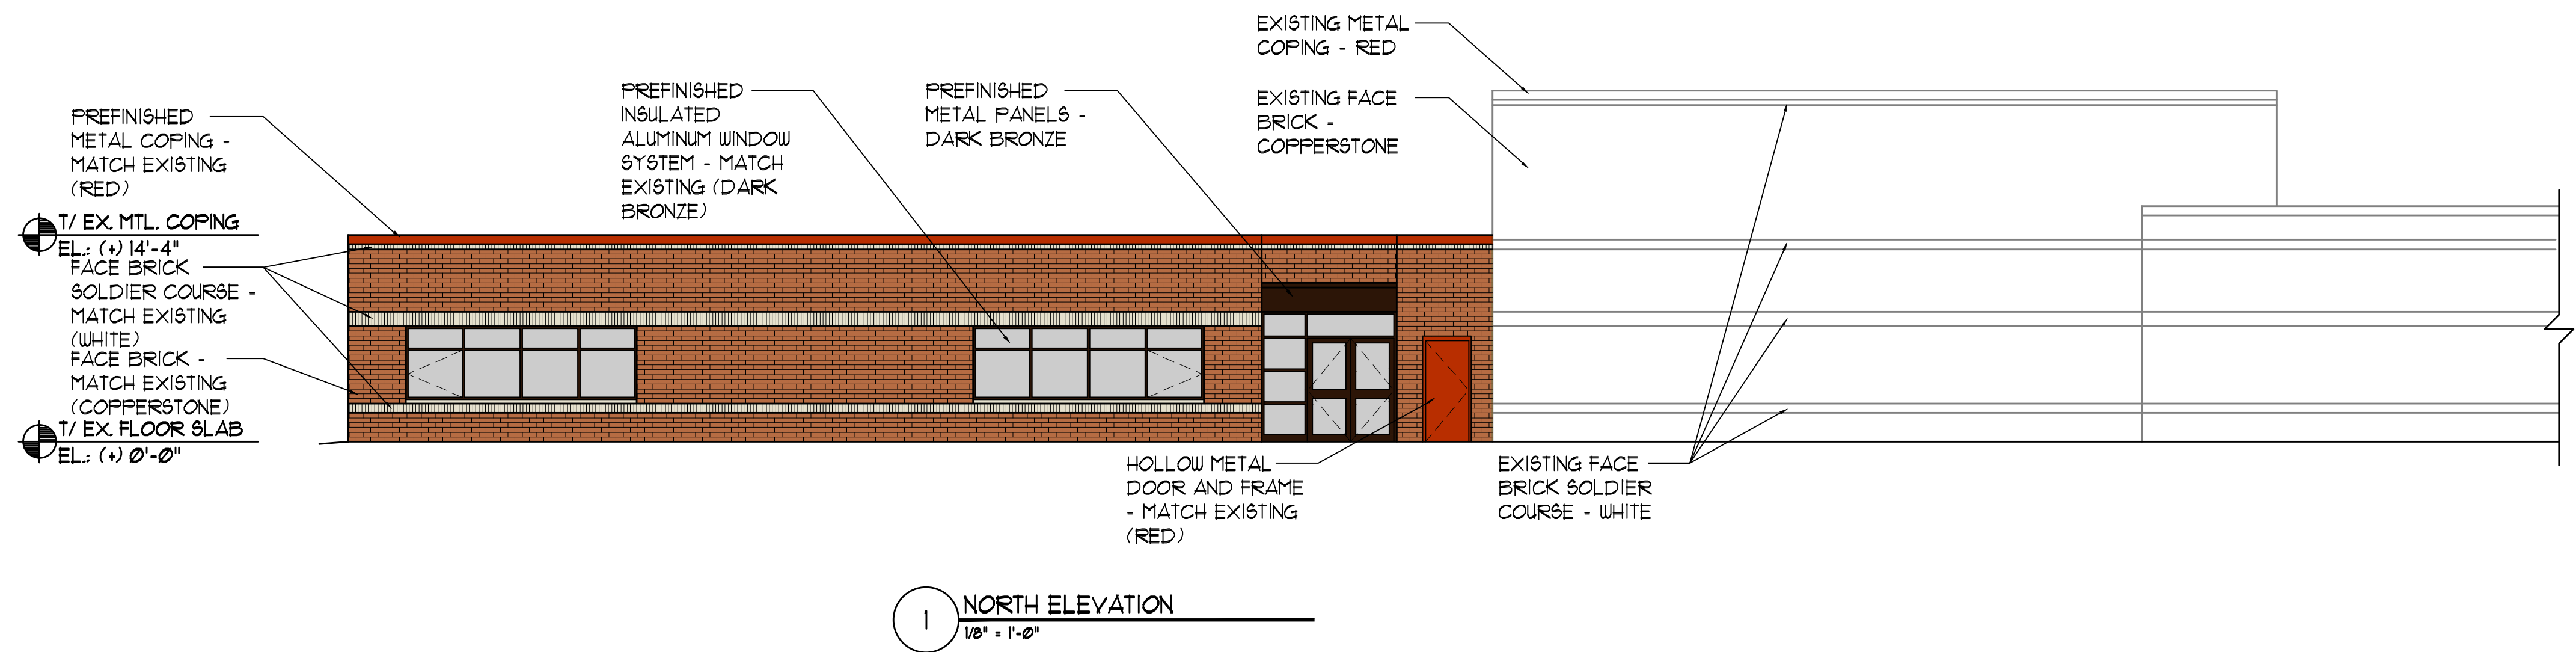

CIVIL CONSULTANT:  
(P) 630/4652172

STRUCTURAL CONSULTANT:  
(P) 630/3610540  
(P) 630/3510864

MEP / FF CONSULTANT:  
(P) 630/3610540  
(P) 630/3610540

reSmith  
135 E. CREEK PARK, SUITE 102  
MORTON, ILLINOIS 60451-0002

Larson Engineering, Inc.  
135 E. CREEK PARK, SUITE 102  
MORTON, ILLINOIS 60451-0002

FLARA  
135 E. CREEK PARK, SUITE 102  
MORTON, ILLINOIS 60451-0002

ORLAND SCHOOL DISTRICT 135  
2023 ADDITIONS AND RENOVATIONS AT:  
CENTENNIAL PRIMARY SCHOOL  
14101 CREEK CROSSING DR, ORLAND PARK, IL 60462

|                        |                     |
|------------------------|---------------------|
| PROJECT NUMBER: 21-064 | SECTION             |
| PROJECT MANAGER: TFS   | EXTERIOR ELEVATIONS |
| DRAWN BY: XXX          |                     |
| DATE: 12/20/21         |                     |



A4.00

SET 1 OF 5