


File: P:\1501 Simon Park and Orland Square.dwg (cd\sheet\1501.LA101 - Layout Plan.dwg

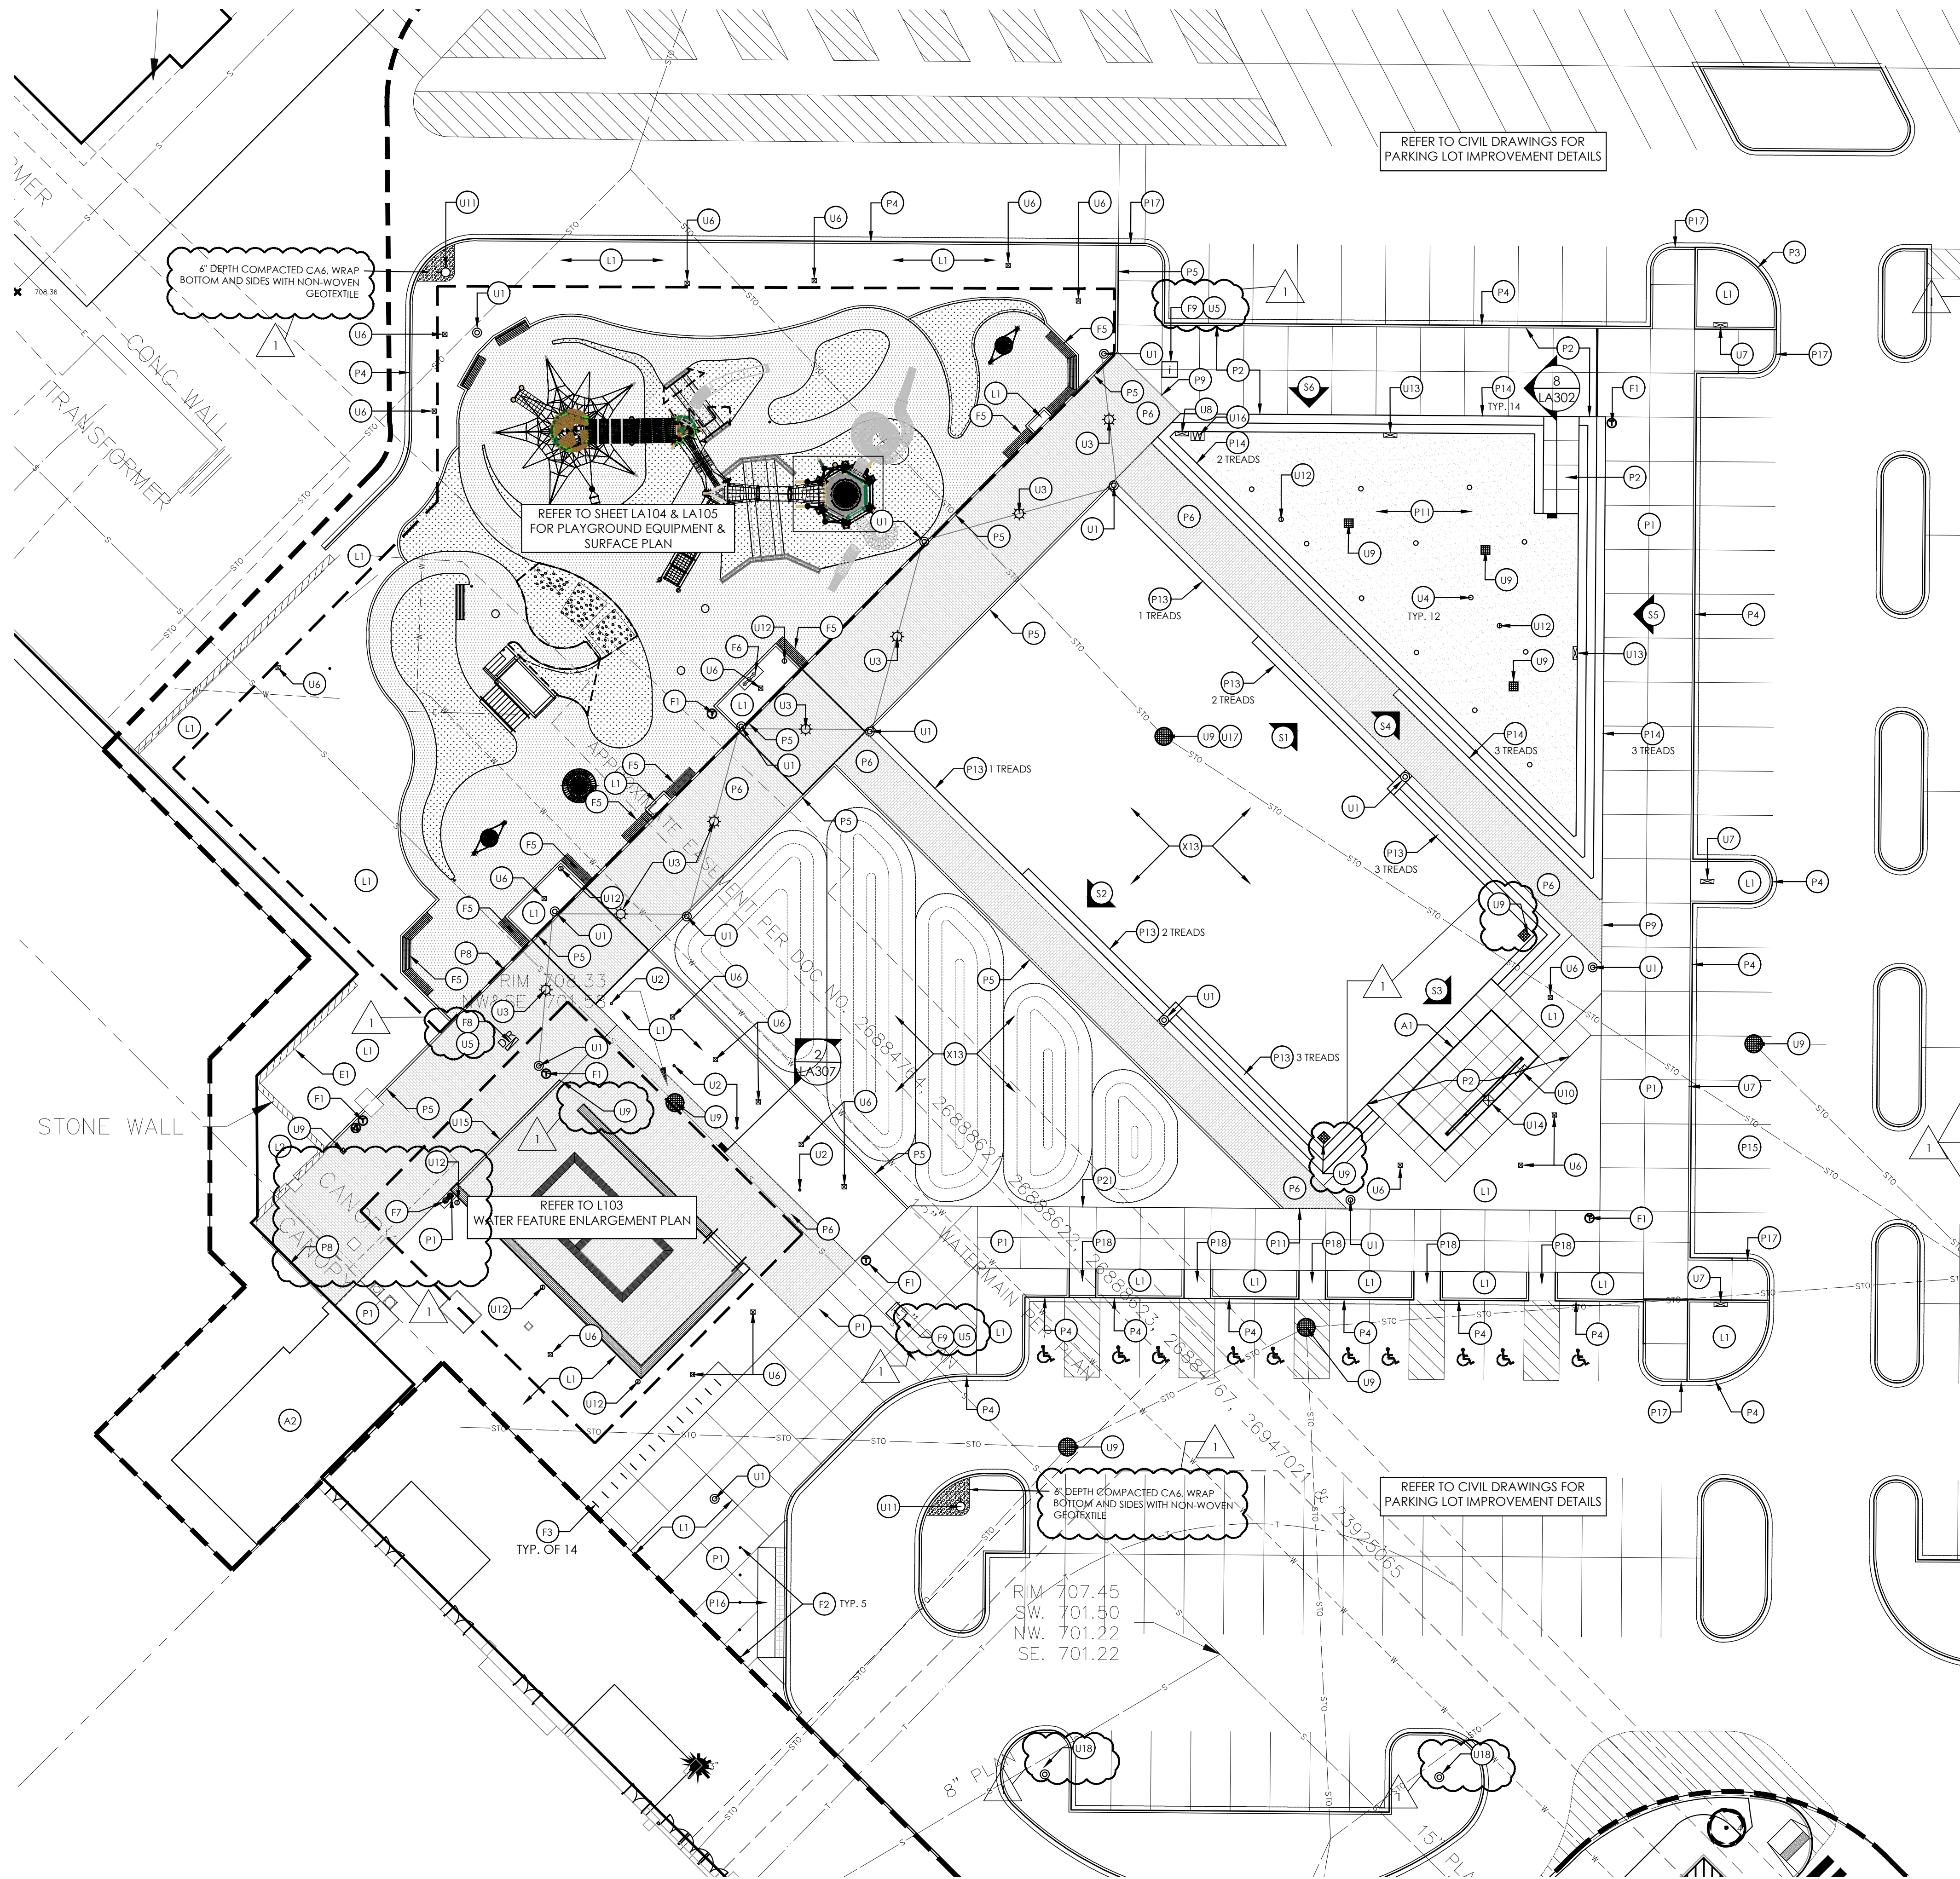

LAYOUT KEYNOTES:

ITEM	DESCRIPTION	DETAIL REFERENCE
ARCHITECTURE		
A1	STAGE	SEE ARCHITECTURAL DRAWINGS
A2	INTERIOR RESTROOMS & UTILITY ROOM	SEE ARCHITECTURAL DRAWINGS
EXISTING STRUCTURES		
E1	EXISTING WALL	SEE DEMO PLANS
FURNISHINGS		
F1	LITTER RECEPTACLE	SEE SPECIFICATION
F2	BOLLARD	SEE DETAIL 6/LA303
F3	BIKE RACK	SEE DETAIL 1/LA303
F4	MOVEABLE TABLE AND CHAIRS	SEE SPECIFICATION
F5	BENCH	SEE SHEET LA311
F6	BI-LEVEL DRINKING FOUNTAIN	SEE DETAIL 2/LA303
F7	BI-LEVEL DRINKING FOUNTAIN	SEE DETAIL 2/LA303
F8	INTERACTIVE OUTDOOR DIRECTOR SIGN	SEE DETAILS 6/LA311
F9	IDENTITY SIGN	SEE DETAILS 4 + 5/LA314
LANDSCAPE		
L1	PLANT BED	SEE LANDSCAPE PLAN + SCHEDULE
L2	TURF SOD	SEE LANDSCAPE PLAN + SCHEDULE
PAVEMENT		
P1	CONCRETE PAVEMENT, STANDARD	SEE DETAIL 2/LA301
P2	CONCRETE PAVEMENT, VEHICULAR	SEE DETAIL 3/LA301
P3	SPRAY PLAZA STAIRS	SEE DETAIL 18/LA301
P4	CURB AND GUTTER	SEE DETAIL 5/LA301 & CIVIL SHEETCS02
P5	CURB, CONCRETE CONTAINMENT	SEE DETAIL 14 + 16/LA301
P6	UNIT PAVERS, TYPE A	SEE DETAILS 6 + 12/LA301
P7	UNIT PAVERS, TYPE B (SPRAY PLAZA)	SEE DETAILS 7/LA301
P8	PAVERS ADJACENT DOOR THRESHOLD	SEE DETAIL 9/LA301
P9	PAVERS ADJACENT TO CONCRETE WALK	SEE DETAIL 10/LA301
P10	PAVER, TYPE A-PAVER, TYPE B INTERFACE	SEE DETAIL 8/LA301
P11	DECOMPOSED GRANITE	SEE DETAILS 13-14/LA301
P12	SPRAY PLAZA TRENCH BASIN	SEE SHEET LA305
P13	C.I.P. CONCRETE STEPS, LAWN	SEE SHEET LA302, LA310
P14	C.I.P. CONCRETE STEPS, BOSQUE	SEE SHEET LA302, LA309
P15	ASPHALT PAVEMENT	REFER TO CIVIL DRAWINGS
P16	CURB RAMP, TYPE A	SEE DETAIL 1/LA314
P17	CURB RAMP, TYPE B	SEE DETAIL 2/LA314
P18	CURB RAMP, TYPE C	SEE DETAIL 3/LA314
P19	HAND RAILS	SEE DETAIL 17/LA301
P20	SPRAY PLAZA WALL, CORNER	SEE DETAIL 5/LA312
P21	CONCRETE ADJACENT ARTIFICIAL TURF	SEE DETAIL 11/LA301
STEPS		
S1	EVENT LAWN, NORTH STEP	SEE DETAIL 1/LA310
S2	EVENT LAWN, SOUTH STEP	SEE DETAIL 2/LA310
S3	EVENT LAWN, EAST STEP	SEE DETAIL 3/LA310
S4	BOSQUE, SOUTH STEP	SEE DETAIL 2/LA309
S5	BOSQUE, EAST STEP	SEE DETAIL 3/LA309
S6	BOSQUE, NORTH STEP	SEE DETAIL 1/LA309
UTILITY		
U1	LIGHT POLE AND FIXTURE	SEE SHEET LA 205
U2	PATHWAY LIGHT FIXTURE	SEE DETAIL 5/LA303
U3	CATENARY LIGHTING	SEE ELECTRICAL DRAWINGS
U4	UPLIGHT	SEE DETAIL 4/LA303
U5	CONDUIT FOR FUTURE SIGNAGE	SEE ELECTRICAL PLANS
U6	GFCI POWER RECEPTACLE	SEE ELECTRICAL PLANS
U7	30 AMP TRUCK POWER	SEE ELECTRICAL PLANS
U8	30 AMP POWER PEDESTAL, LEGRAND	SEE DETAIL 3/LA303
U9	AREA DRAIN	SEE CIVIL AND DETAIL 11/LA304
U10	ADDITIONAL RECEPTACLE, LEGRAND	SEE ELECTRICAL PLANS
U11	POWER PEDESTAL, LEGRAND	SEE DETAIL 11/LA303
U12	GFCI POWER RECEPTACLE, LEGRAND	SEE ELECTRICAL AND DETAIL 9/LA301
U13	ARTIFICIAL TURF	SEE DETAIL 10/LA303
U14	ARTIFICIAL TURF	SEE DETAIL 8/LA312
U15	SLOT DRAIN	SEE DETAIL 10/LA303
U16	FUTURE WATER CONNECTION	SEE DETAIL 8/LA312
U17	ARTIFICIAL TURF	SEE DETAIL 10/LA303
U18	PARKING LOT LIGHT	SEE PHOTOMETRIC AND ELECTRICAL
ARTIFICIAL TURF		
X13	ARTIFICIAL TURF	SEE SHEET LA304

SITE DEVELOPMENT DATA BOX

LANDSCAPE ZONE	EXISTING	REQUIRED	PROVIDED	UNIT
Bicycle Parking		26.7 (801 Vehicle Spaces/30)	28	EACH
Wetland Area	0	0	0	SQ FT
Floodway Area	0	0	0	SQ FT
Floodplain Area	0	0	0	SQ FT
Area of Open Water	0	0	0	SQ FT

**RUNDELL
ERNSTBERGER
ASSOCIATES**

Land Architecture + Urban Design + Land Planning
618 East Market Street, Indianapolis, IN 46202
TE [317] 263.0127 FX [317] 263.2080

611 W Main Street, Suite 201, Louisville, KY 40202
TE [502] 561.8676 FX [502] 561.9076
www.reasite.com

PROJECT LEAD:

PREPARED FOR:

SUBCONSULTANT:

PROJECT:

**ORLAND SQUARE MALL
PROPOSED MULTIPURPOSE
ACTIVITY SPACE**

288 Orland Square Drive, Orland Park, IL 60462

REVISIONS:

NO.	BY	DESCRIPTION	DATE
1	REA	ADDENDUM #1	03-08-19

COPYRIGHT NOTICE:

THE CONCEPTS, IDEAS, DESIGNS, PLANS, AND DETAILS AS SHOWN ON THIS DOCUMENT ARE THE SOLE PROPERTY OF RUNDELL ERNSTBERGER ASSOCIATES, INC. AND WERE CREATED, DEVELOPED, AND PROVIDED FOR USE ON THE PROJECT BY THE FIRM. NO PART OF THIS DOCUMENT OR ANY OF ITS CONTENTS SHALL BE REPRODUCED OR TRANSMITTED IN ANY FORM OR BY ANY MEANS, ELECTRONIC OR MECHANICAL, INCLUDING PHOTOCOPYING, RECORDING, OR BY ANY INFORMATION STORAGE AND RETRIEVAL SYSTEM, WITHOUT THE EXPRESS WRITTEN PERMISSION OF RUNDELL ERNSTBERGER ASSOCIATES, INC. THE OWNER/CLIENT SHALL BE PERMITTED TO RETAIN COPIES FOR INFORMATION AND REFERENCE IN CONNECTION WITH THIS PROJECT.

DRAWING NAME:

**SITE LAYOUT &
MATERIALS PLAN**

CERTIFICATION:

LICENSED LANDSCAPE ARCHITECT

KEVIN J. OSBURN
157-001326

STATE OF ILLINOIS

REA Project #: 171501
Date: 02/21/2019
Drawn by: KK
Reviewed by: DL

DRAWING #:

LA101

DATE: 02/21/2019
EXPIRES: 08/31/2019