

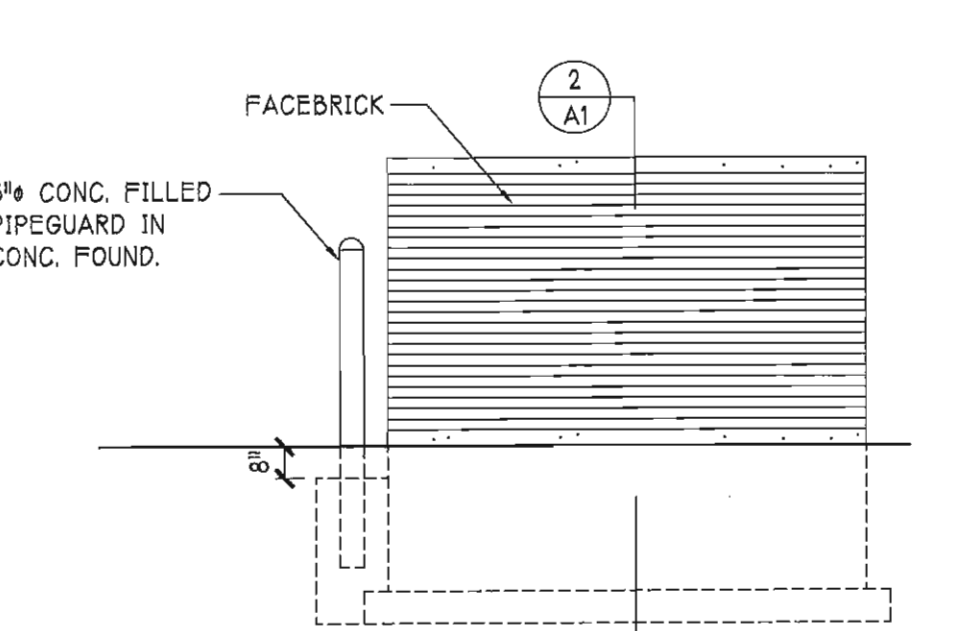


2 TRASH ENCLOSURE 1/4" = 1'-0"

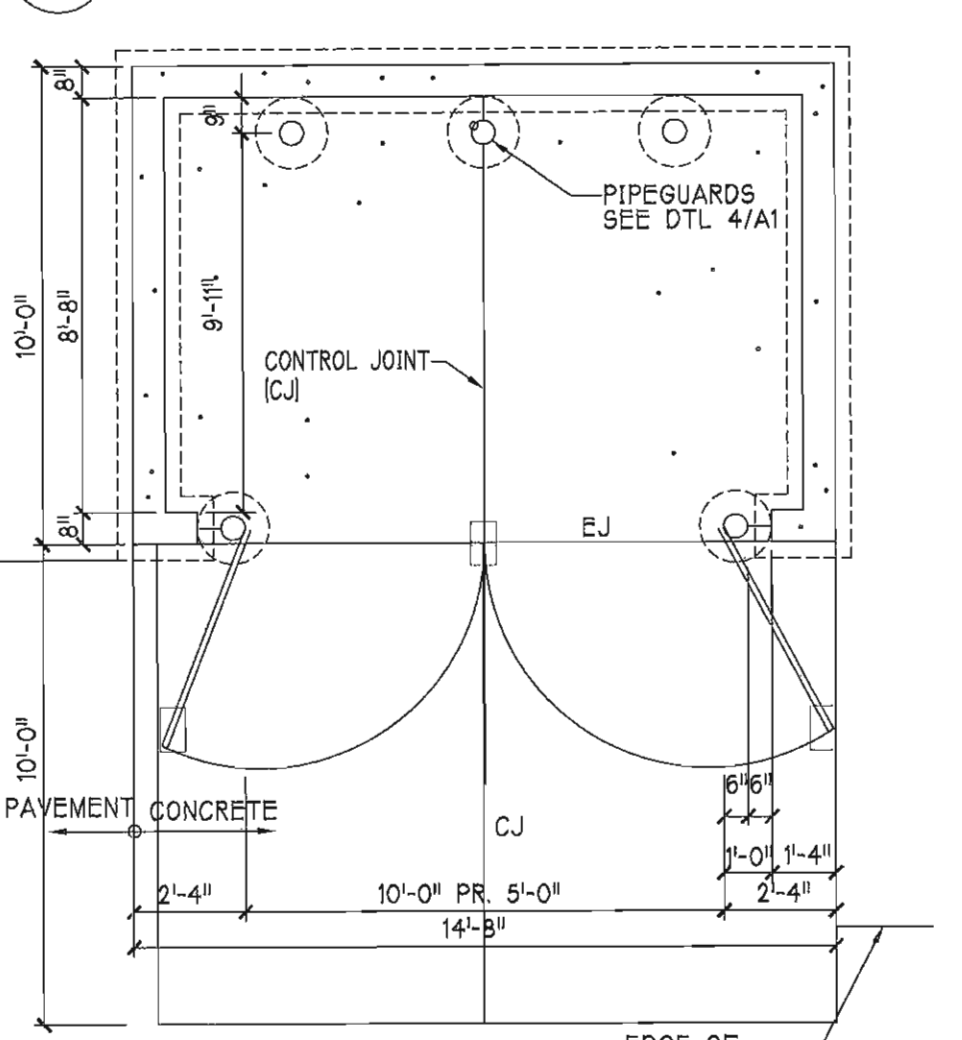


NORTH/ SOUTH ELEVATIONS

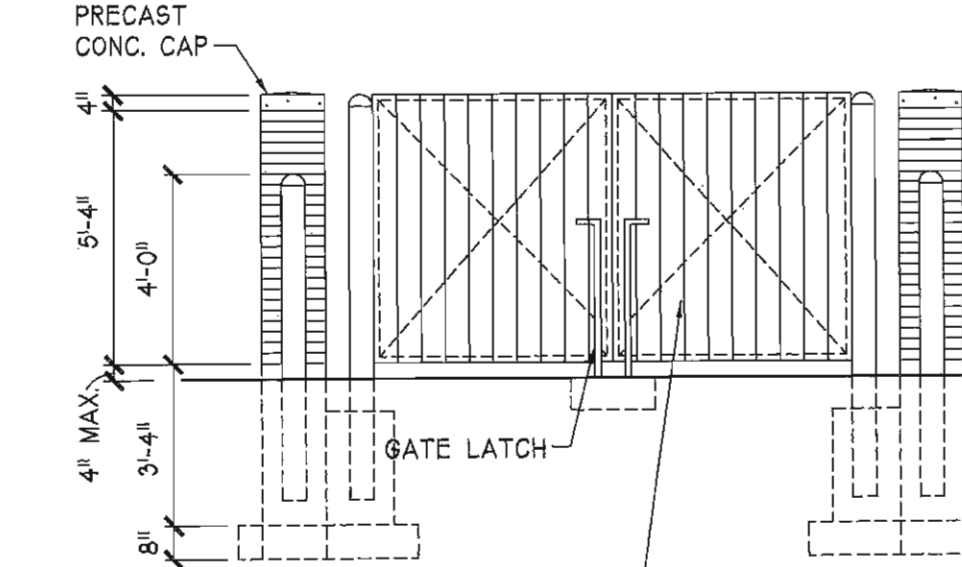


2"X6" VERT. STAINED CEDAR ON STL. ANGLE FRAME (PAINTED) W/DIAGONAL ADJUSTABLE TIE RODS ON PIVOT HINGE ON 6" CONC. FILLED PIPE (IN 18"X3'-8" DP. CONC. FOUND.) PROVIDE GATE LATCH W/RECEIVER IN PAVEMENT IN CLOSED & OPEN POSITION

EAST ELEVATION

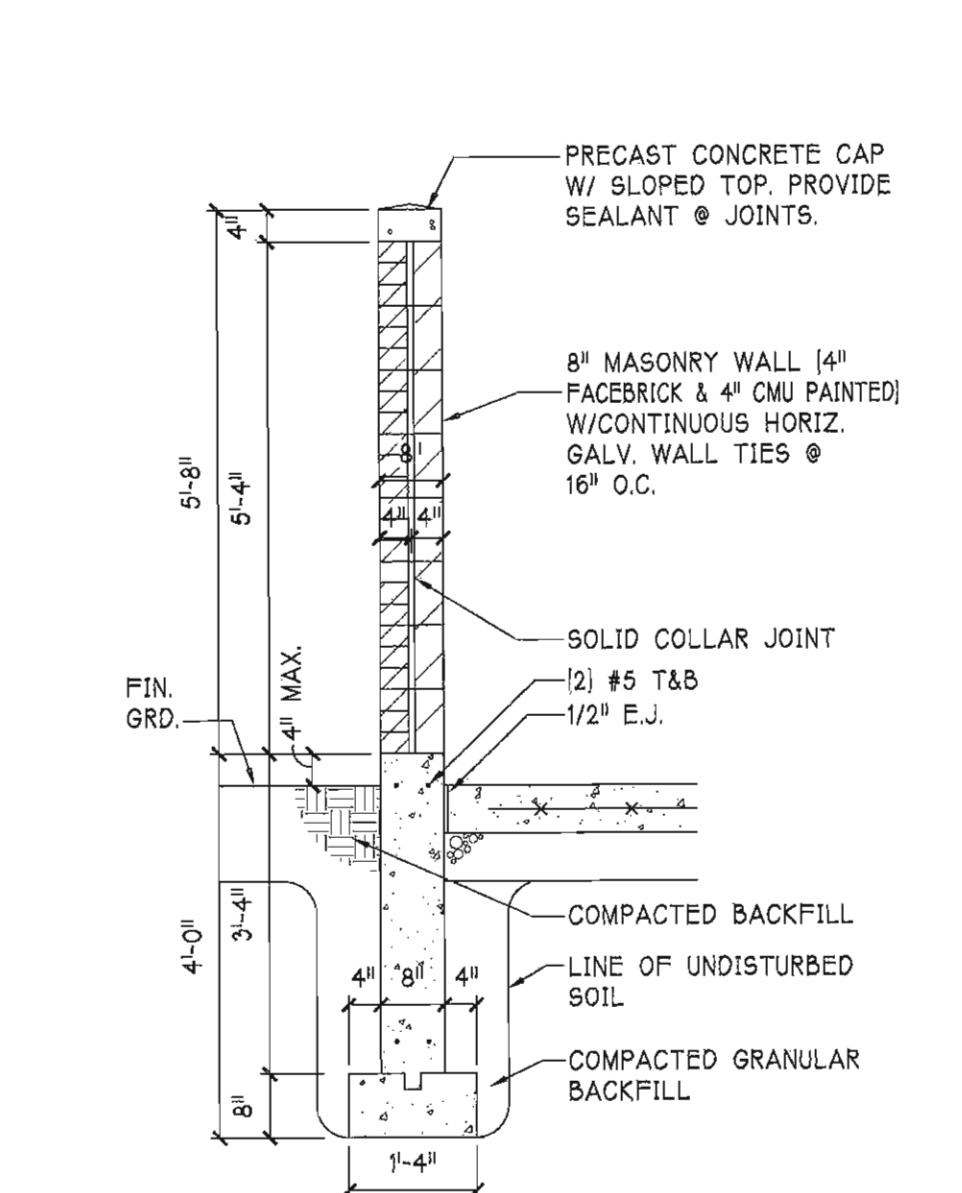

3 SECTION 1/2" = 1'-0"

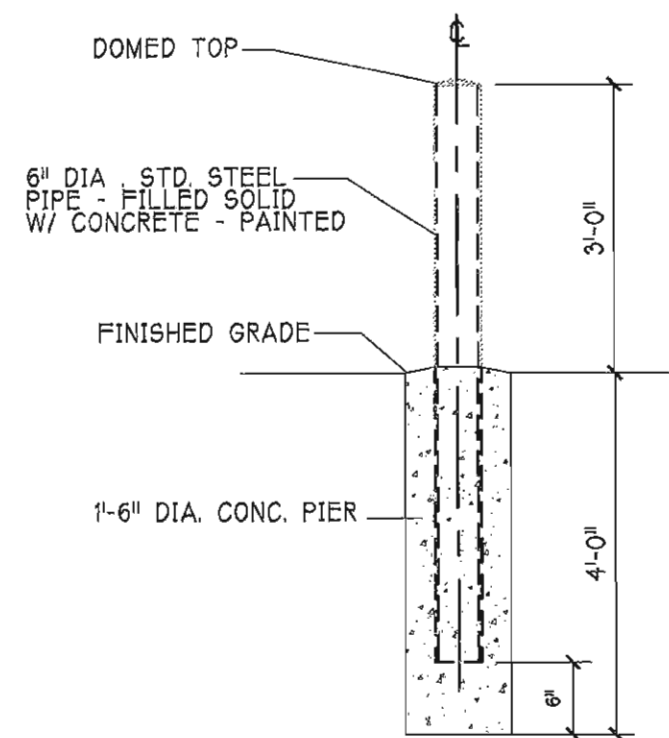


4 PIPE BOLLARD

NTS

REFER TO CIVIL ENGINEERING DRAWINGS FOR SITE PLAN (GEOMETRICS, GRADING, & UTILITIES) ALL WORK SHALL COMPLY WITH THE ILLINOIS ACCESSIBILITY CODE & THE AMERICANS WITH DISABILITIES ACT. ARCHITECT HAS NOT BEEN CONTRACTED FOR SITE DESIGN, AND HAS NO RESPONSIBILITY FOR ITS COMPLIANCE WITH APPLICABLE CODES.

LOCATION PLAN

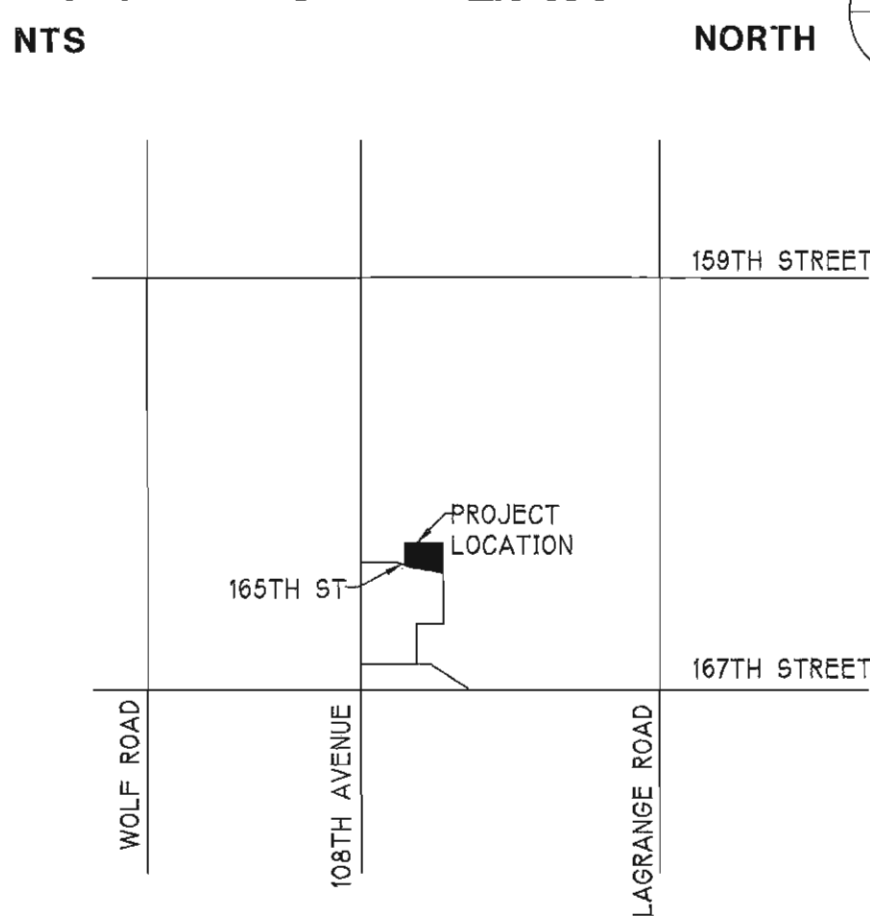

CODES

|                  |                                                                         |
|------------------|-------------------------------------------------------------------------|
| ARCHITECTURAL:   | INTERNATIONAL BUILDING CODE 2006                                        |
| MECHANICAL:      | INTERNATIONAL MECHANICAL CODE 2006                                      |
| PLUMBING:        | STATE OF ILLINOIS PLUMBING                                              |
| ELECTRICAL:      | NEC 2005                                                                |
| FIRE PROTECTION: | INTERNATIONAL FIRE CODE 2006                                            |
| ENERGY CODE:     | INTERNATIONAL ENERGY CODE 2006                                          |
| HANDICAP:        | ILLINOIS ACCESSIBILITY CODE (IAC)<br>AMERICANS W/DISABILITIES ACT (ADA) |

NOTE: ALL WORK SHALL COMPLY WITH THE IAC & ADA

ALTERNATES


A1 WINDOW BLINDS (ADD)

BUILDING DATA

|                    |               |
|--------------------|---------------|
| CONSTRUCTION TYPE: | IIIB          |
| BUILDING AREA:     | 7,987 SF      |
| BUILDING HEIGHT:   | 28'-4" (PEAK) |
| OCCUPANCY USE:     | B- BUSINESS   |

DRAWING INDEX

| SHEET | DESCRIPTION                            | NO. |
|-------|----------------------------------------|-----|
| A1    | SITE KEY PLAN & TRASH ENCLOSURE        | 1   |
| A2    | BLDG FLOOR PLAN & DETAILS              | 2   |
| A3    | DETAILS                                | 3   |
| A4    | EXTERIOR ELEVATIONS & DETAILS          | 4   |
| A5    | DETAILS                                | 5   |
| A6    | BUILDING SECTIONS & DETAILS            | 6   |
| S1    | FOUNDATION PLAN                        | 7   |
| S2    | ROOF & FLOOR FRAMING PLANS             | 8   |
| S3    | DETAILS                                | 9   |
| S4    | MASONRY WALL REINFORCING               | 10  |
| P1    | PLUMBING & FIRE PROTECTION FLOOR PLANS | 11  |
| M1    | MECHANICAL FLOOR PLANS                 | 12  |
| E1    | LIGHTING & POWER FLOOR PLANS           | 13  |
| SP1   | SPECIFICATIONS                         | 14  |

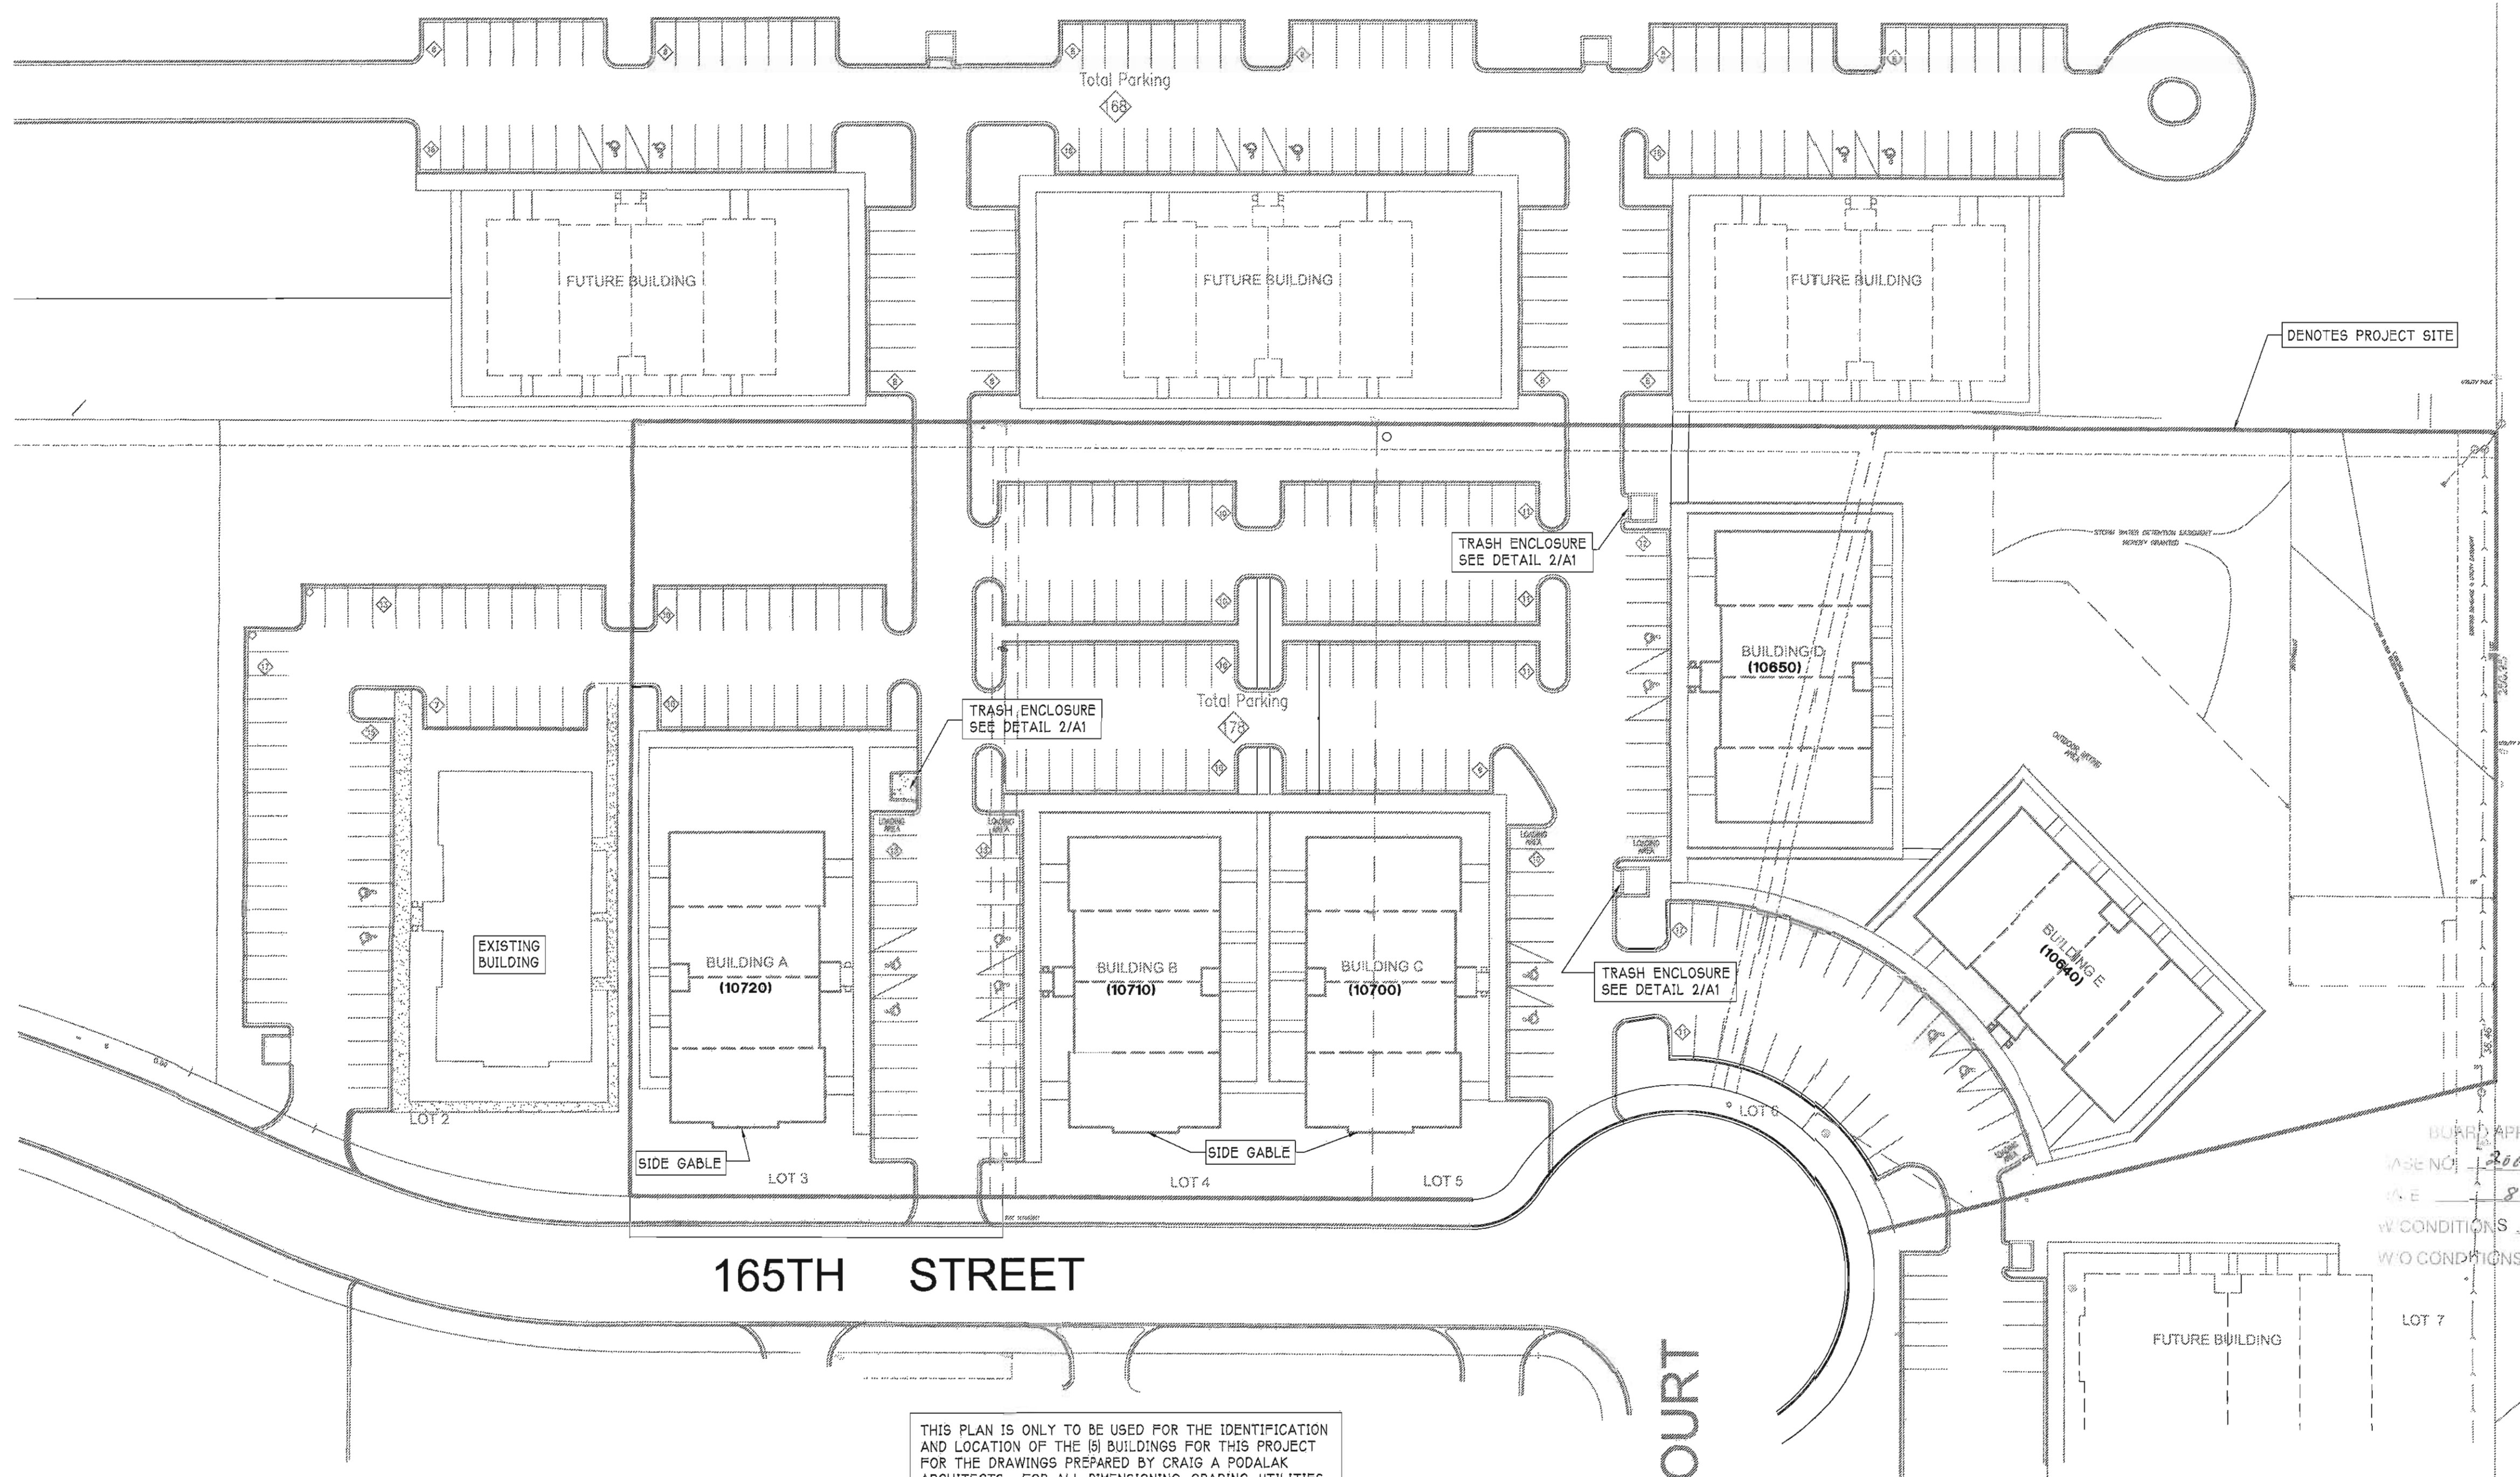

THIS PLAN IS ONLY TO BE USED FOR THE IDENTIFICATION AND LOCATION OF THE (5) BUILDINGS FOR THIS PROJECT FOR THE DRAWINGS PREPARED BY CRAIG A. PODALAK ARCHITECTS. FOR ALL DIMENSIONING, GRADING, UTILITIES, ETC. REFER TO THE CIVIL ENGINEERING DRAWINGS.

BUILDING ADDRESSES SHOWN TO BE CONFIRMED WITH POSTAL SERVICE

1 SITE KEY PLAN


1"=40'-0"

STATUS PLOT  
NOT FOR CONSTRUCTION



CRAIG A. PODALAK ARCHITECTS

12410 S. NASHVILLE AVE.  
PALOS HEIGHTS, IL 60463  
708 / 389-3333

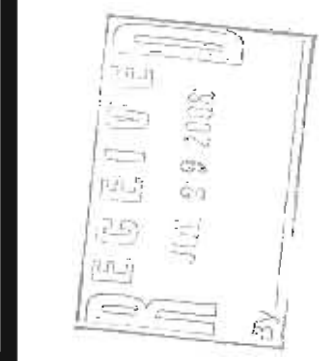

GLEN OAKS PHASE 5 OFFICE PARK  
10640- 10720 W 165TH STREET  
ORLAND PARK, ILLINOIS

PROJECT NO. 0816  
DATE 7-15-08

DRAWN BY RD  
CHECKED BY CAP  
FILE 0816A1

1 OF 14

COPYRIGHT © 2008 CRAIG A. PODALAK RESERVES COPYRIGHT & OTHER RIGHTS RESTRICTING THESE DOCUMENTS TO THE ORIGINAL SITE OR PURPOSE FOR WHICH THEY WERE PREPARED. REPRODUCTIONS, CHANGES, OR ASSIGNMENTS ARE PROHIBITED.