

NOTES:

1) EXISTING OBSTRUCTION LIGHT & ANTENNAS TO RELOCATE ON TOP OF PROPOSED MINIMONOPOLE AND FRAME.


EXISTING ANTENNAS USERS AND FREQUENCIES

- ORLAND PARK UTILITY DIVISION ANTENNAS:
 - (2) YAGI AND (1) OMNI
 - (3) SPREAD SPECTRUM RADIOS 900MHZ
- ORLAND PARK PUBLIC WORKS DEPARTMENT:
 - (1) VHF @ 155.00 FREQUENCY RANGE
- ORLAND PARK POLICE DEPARTMENT:
 - (1) VHF @ 155.00 FREQUENCY RANGE
- ORLAND PARK PUBLIC LIBRARY:
 - (1) VHF @ 155.00 FREQUENCY RANGE

2) PROPOSED LESSEE POD MOUNT & US-CELL MINIMONOPOLE ANTENNAS & ALL SUPPORTS TO BE PAINTED TO MATCH WATER TANK EXTERIOR.

3) PROPOSED POLICE DEP. ANTENNAS:

- ONE 300 MHZ OMNI ARRAY
- ONE GPS
- TWO 4.9 MHZ DISH

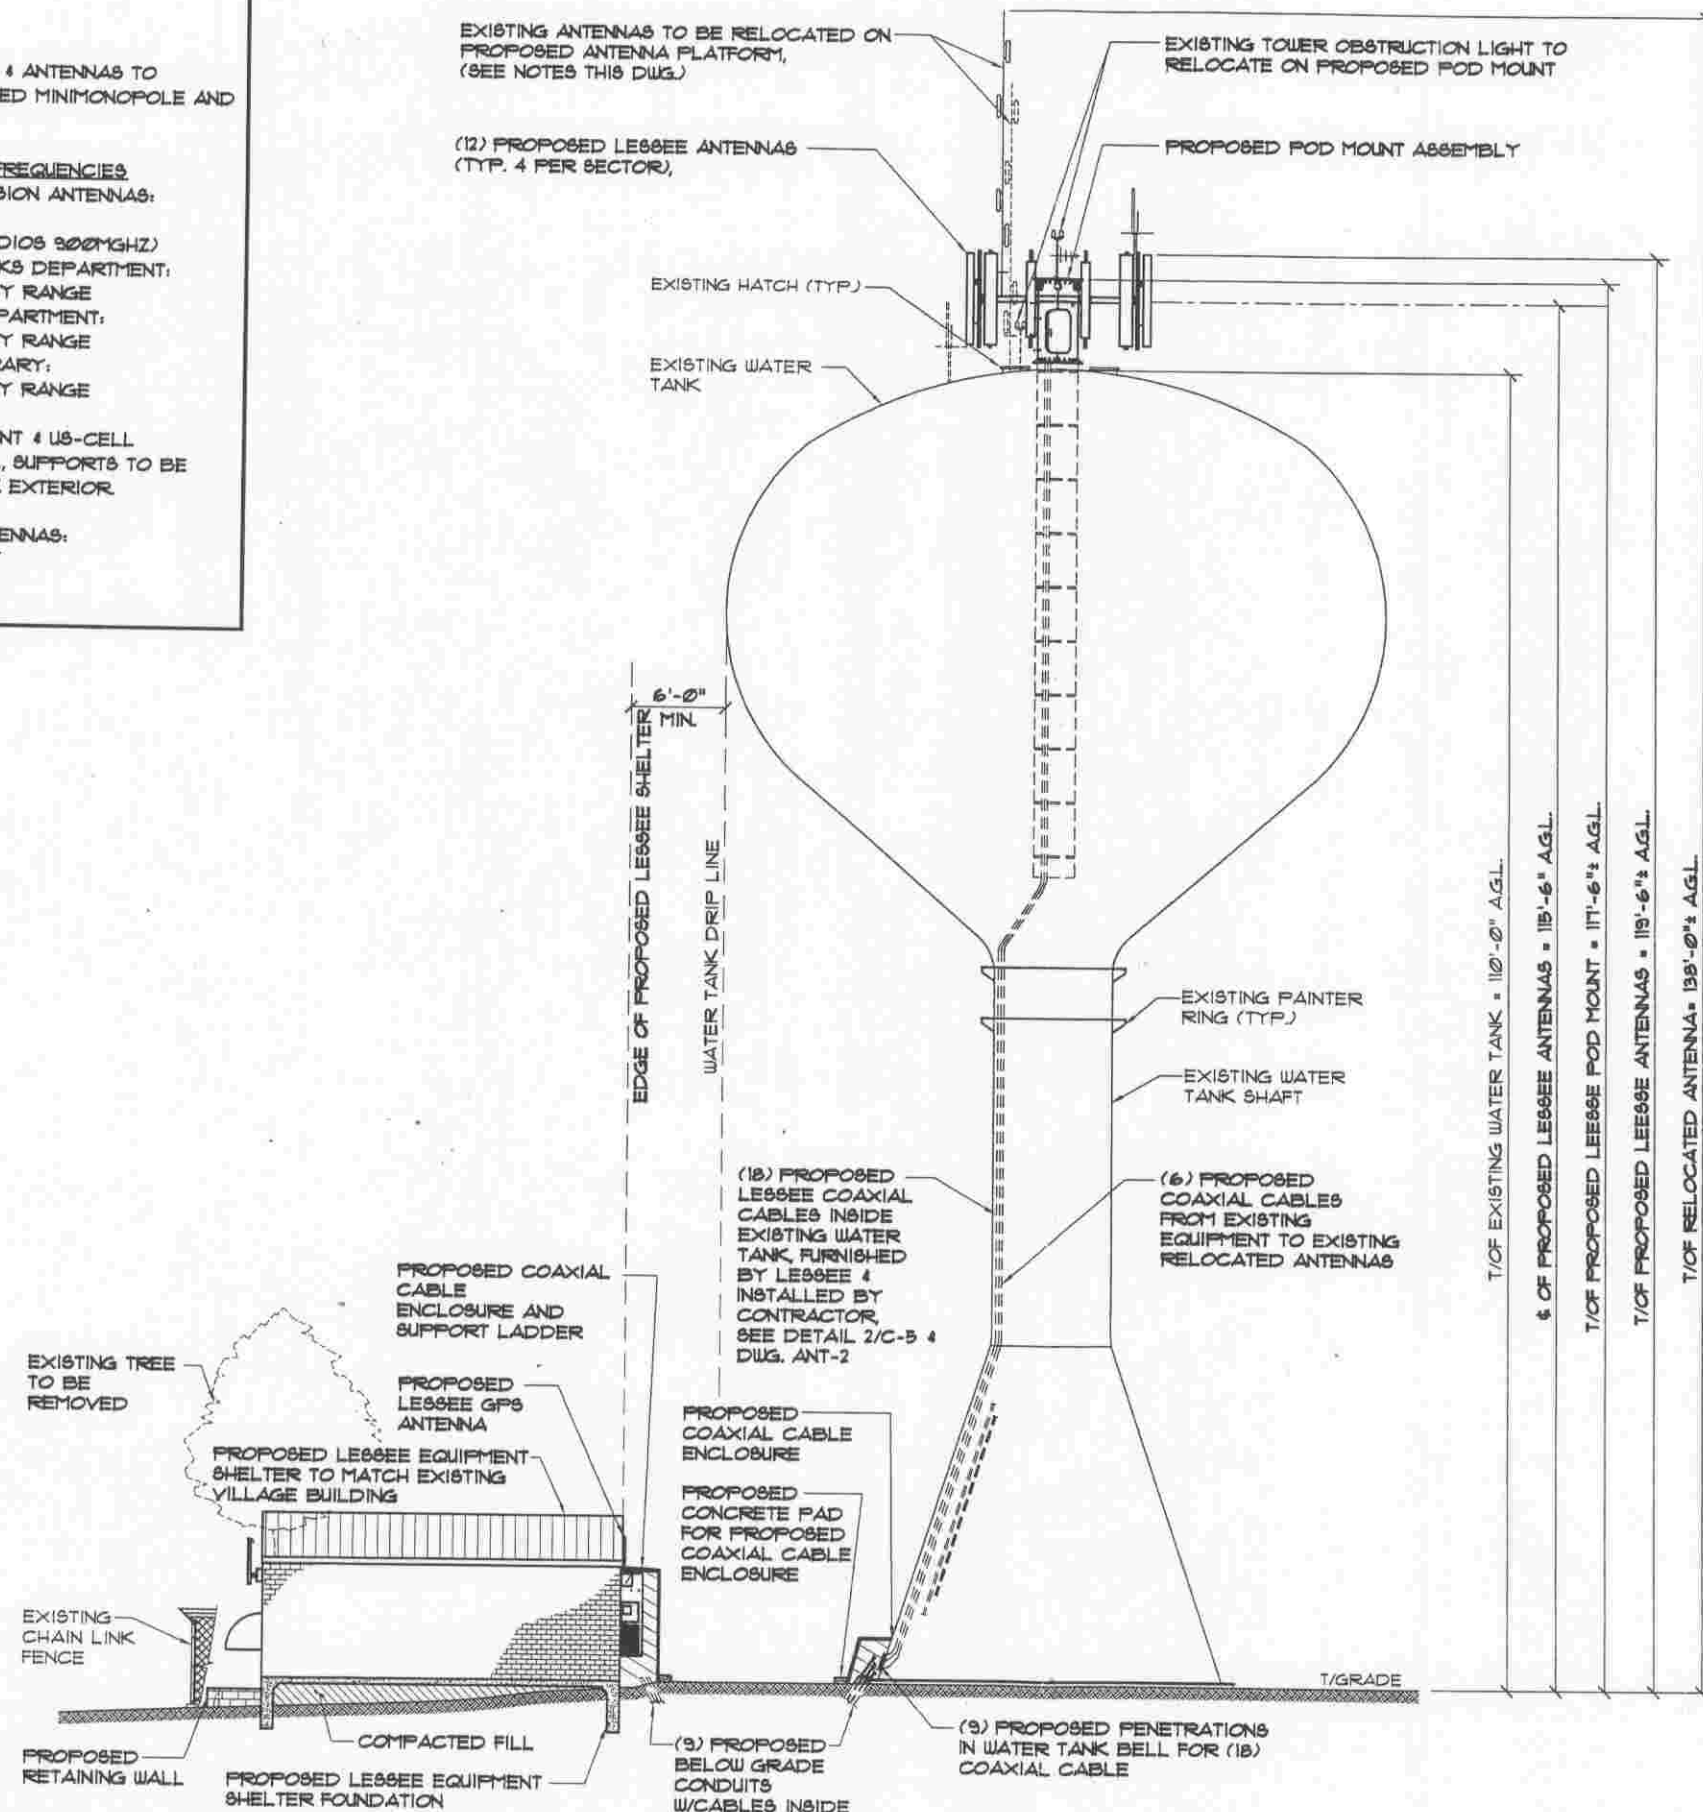

NORTH ELEVATION

SCALE: N.T.S.

Chicago SMSA

Limited Partnership
d/b/a Verizon Wireless
1515 Woodfield Rd.
Suite 1400,
Schaumburg, IL 60173

Fullerton
Engineering Consultants

9100 W. Higgins Rd, Suite 800
Rosemont, Illinois 60018
Tel. 847-292-0100
Fax 847-292-0105

THIS DRAWING IS THE PROPERTY OF FULLERTON ENGINEERING CONSULTANTS, INC. IT IS FOR THE EXCLUSIVE USE OF THIS PROJECT. ANY RE-USE OF THIS DRAWING WITHOUT THE EXPRESSED WRITTEN CONSENT OF FULLERTON ENGINEERING CONSULTANTS, INC. IS PROHIBITED.

SITE NAME

RT. 7 & WEST

LOCATION NUMBER

187771

PROJECT NUMBER

2008284361

SITE ADDRESS

15501 PARK STATION BLVD.
ORLAND PARK, IL 60461

DATE	REVISIONS	
05/15/09	ZONING	AU
08/14/09	ZONING	AU

CHECKED BY: RI

APPROVED BY: HB

DATE SIGNED: _____

EXPIRATION DATE: _____

SHEET TITLE

SITE
ELEVATION

SHEET NUMBER

Z-4