




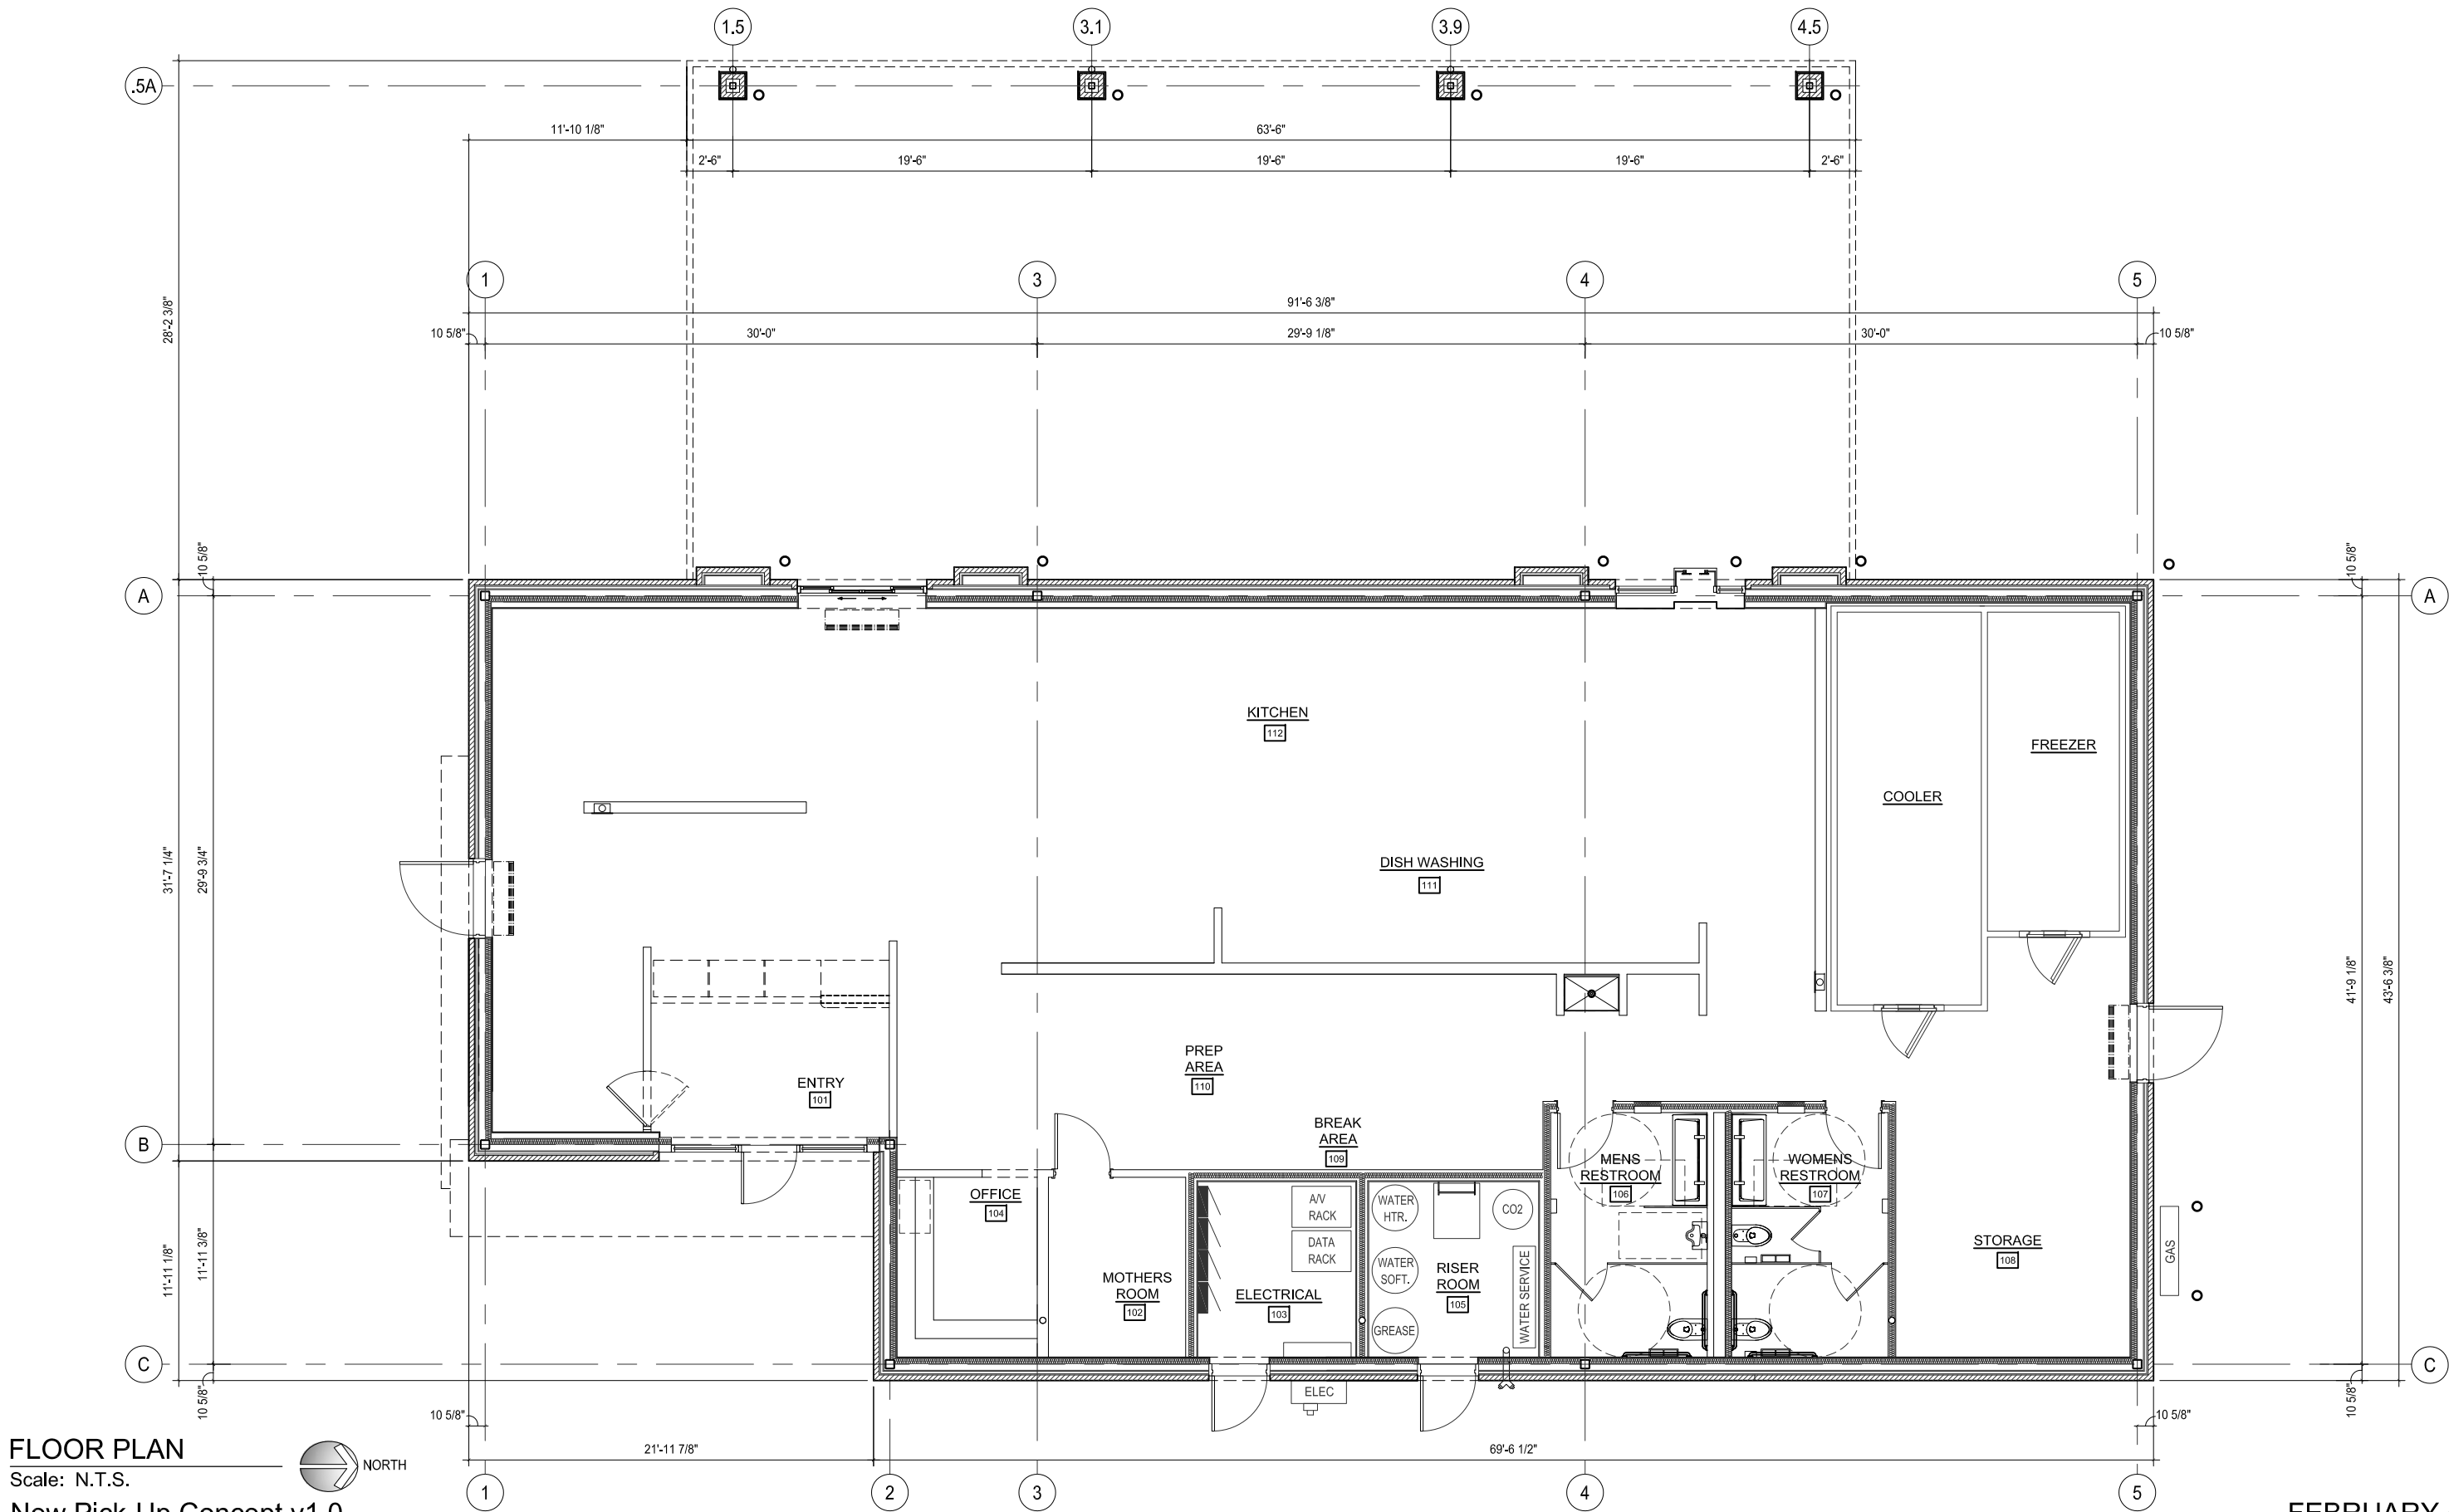

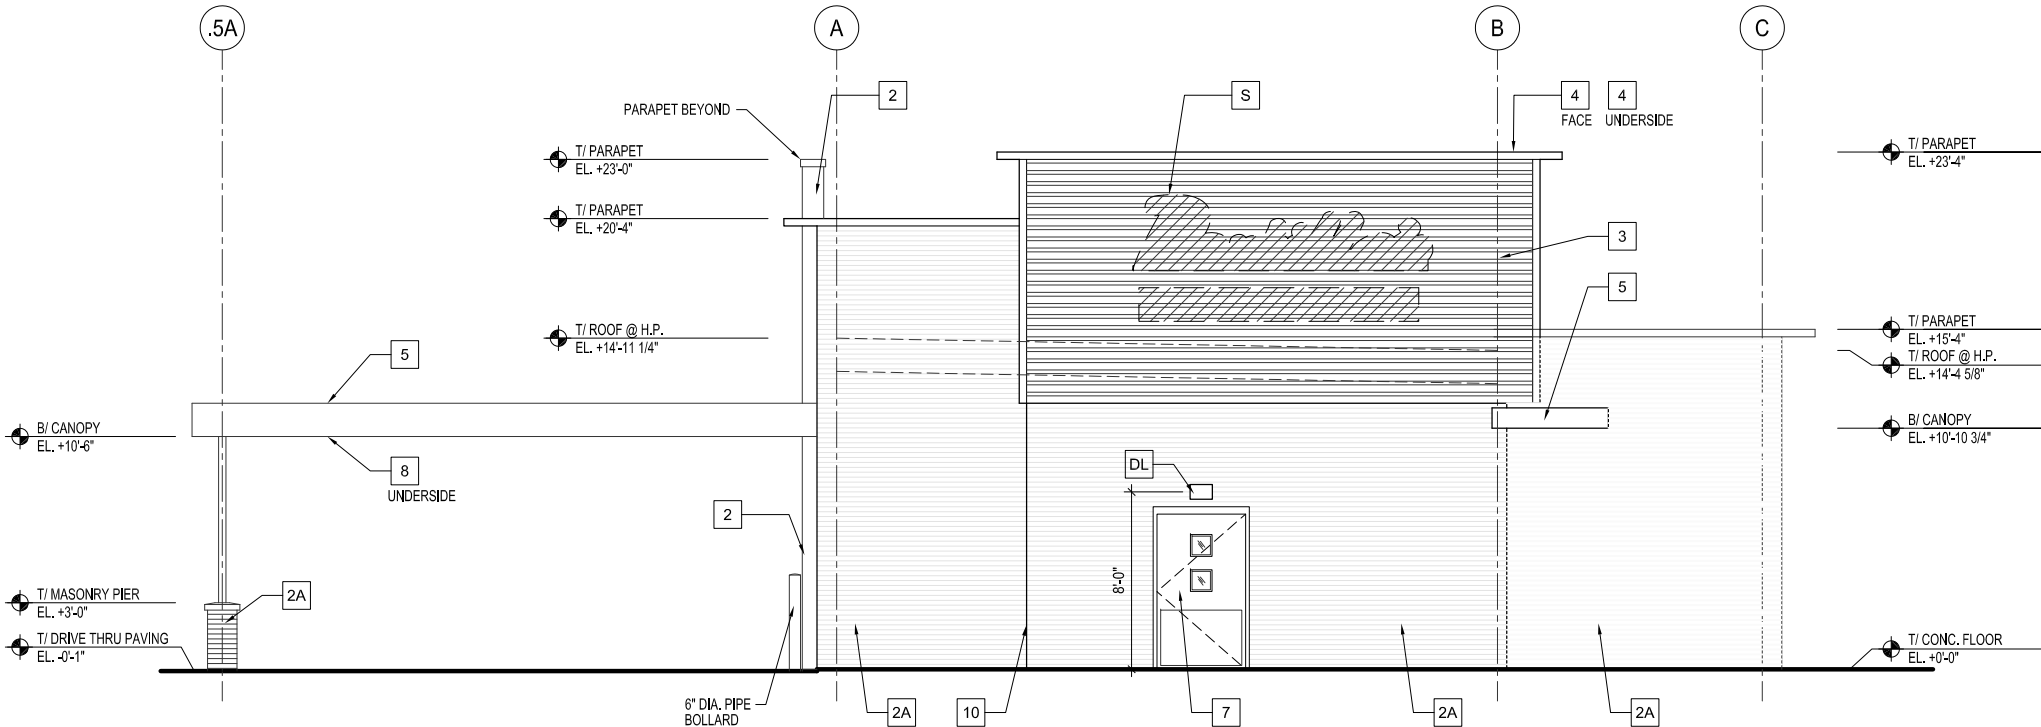


SIDE - SOUTH ELEVATION
Scale: N.T.S.

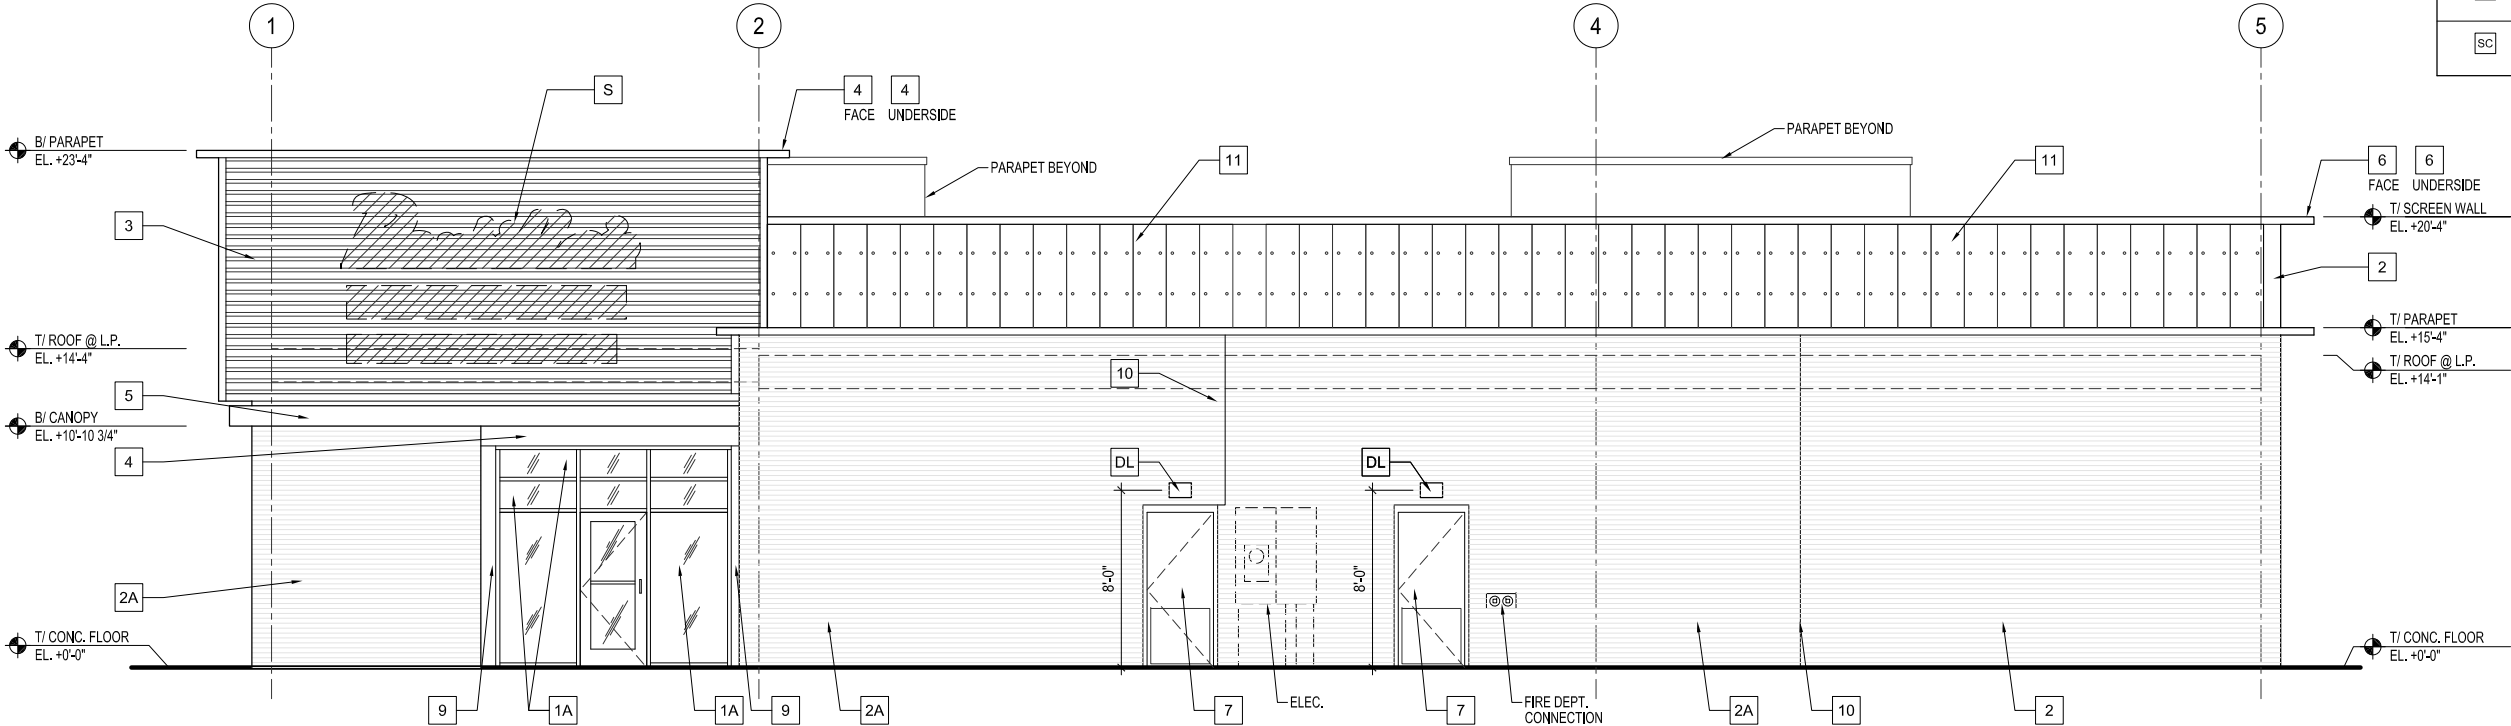


FRONT - EAST ELEVATION
Scale: N.T.S.

MATERIAL SCHEDULE		
KEY NOTE	MATERIAL	MATERIAL SPECIFICATION
1A	ALUMINUM STOREFRONT	2"W x 4-1/2"D THERMALLY BROKEN PRE-FIN. ALUM. STOREFRONT W/ 1" INSULATED GLASS CENTER SET. OLD CASTLE SERIES 3000 OUTSIDE GLAZED OR EQUAL. COLORS: GLASS "SOLAR GRAY" SOLARBAN 60 (TEMPERED AS REQUIRED.), ALUM. CLEAR ANOD.
1B	ALUMINUM STOREFRONT	2"W x 4-1/2"D THERMALLY BROKEN PRE-FIN. ALUM. STOREFRONT W/ 1" INSULATED GLASS CENTER SET. OLD CASTLE SERIES 3000 OUTSIDE GLAZED OR EQUAL. COLORS: GLASS, CLEAR (TEMPERED AS REQUIRED.), ALUM. CLEAR ANOD.
2	BRICK VENEER	BRICK VENEER RUNNING BOND MANUFACTURER: GLEN-GERY COLOR: CARDINAL RED GLAZED
2A	BRICK VENEER	BRICK VENEER RUNNING BOND MANUFACTURER: GLEN-GERY COLOR: "BLACK"
3	RIBBED METAL PANEL	HWP PANELS METAL ERA COLOR: BONE WHITE
4	BRAKE METAL/FASCIA	PREFINISHED METAL SOFFIT BOX/FASCIA METAL ERA OR EQUAL CITADEL COLOR: SLATE GRAY
5	BRAKE METAL/FASCIA	PREFINISHED METAL SOFFIT BOX/FASCIA METAL ERA OR EQUAL CITADEL COLOR: SLATE GRAY
6	BRAKE METAL/FASCIA	PRE-FINISHED SOFFIT PANELS 850 SOFFIT PANELS, ALUM. WITH TRIM, METAL ERA OR EQUAL, CITADEL COLOR: REGAL RED
7	PAINT	PAINT DOOR AND FRAME PAINT: SW6258 TRICORN BLACK
8	PAINT DECK	PAINT CEILING OF EXPOSED METAL SURFACES PAINT: SW6868 REAL RED
9	BREAK METAL	COLOR: TO MATCH CLEAR ANODIZED ALUMINUM
10	CONTROL JOINT	VEENER CONTROL JOINT. COLOR TO MATCH ADJACENT BRICK VENEER COLOR.
11	FIBER CEMENT BOARD	NICHHA ARCHITECTURAL WALL PANEL; CONCRETE TEXTURED DIMPLE CONCRETE WALL PANEL "EMPIRE BLOCK"
WS	WALL SCONCE LIGHT	UP AND DOWN WALL SCONCE LIGHT, WEATHERED PATINA FINISH
S	SIGNAGE	EXTERIOR SIGNAGE, REFER TO SIGNAGE DRAWINGS
DL	WALL MOUNTED DOWNLIGHT	WALL MOUNTED ARM DOWNLIGHT REFER TO ELECTRICAL DRAWINGS
SC	SECURITY CAMERA	WALL MOUNTED SECURITY CAMERA, SEE ELECT. DRAWINGS



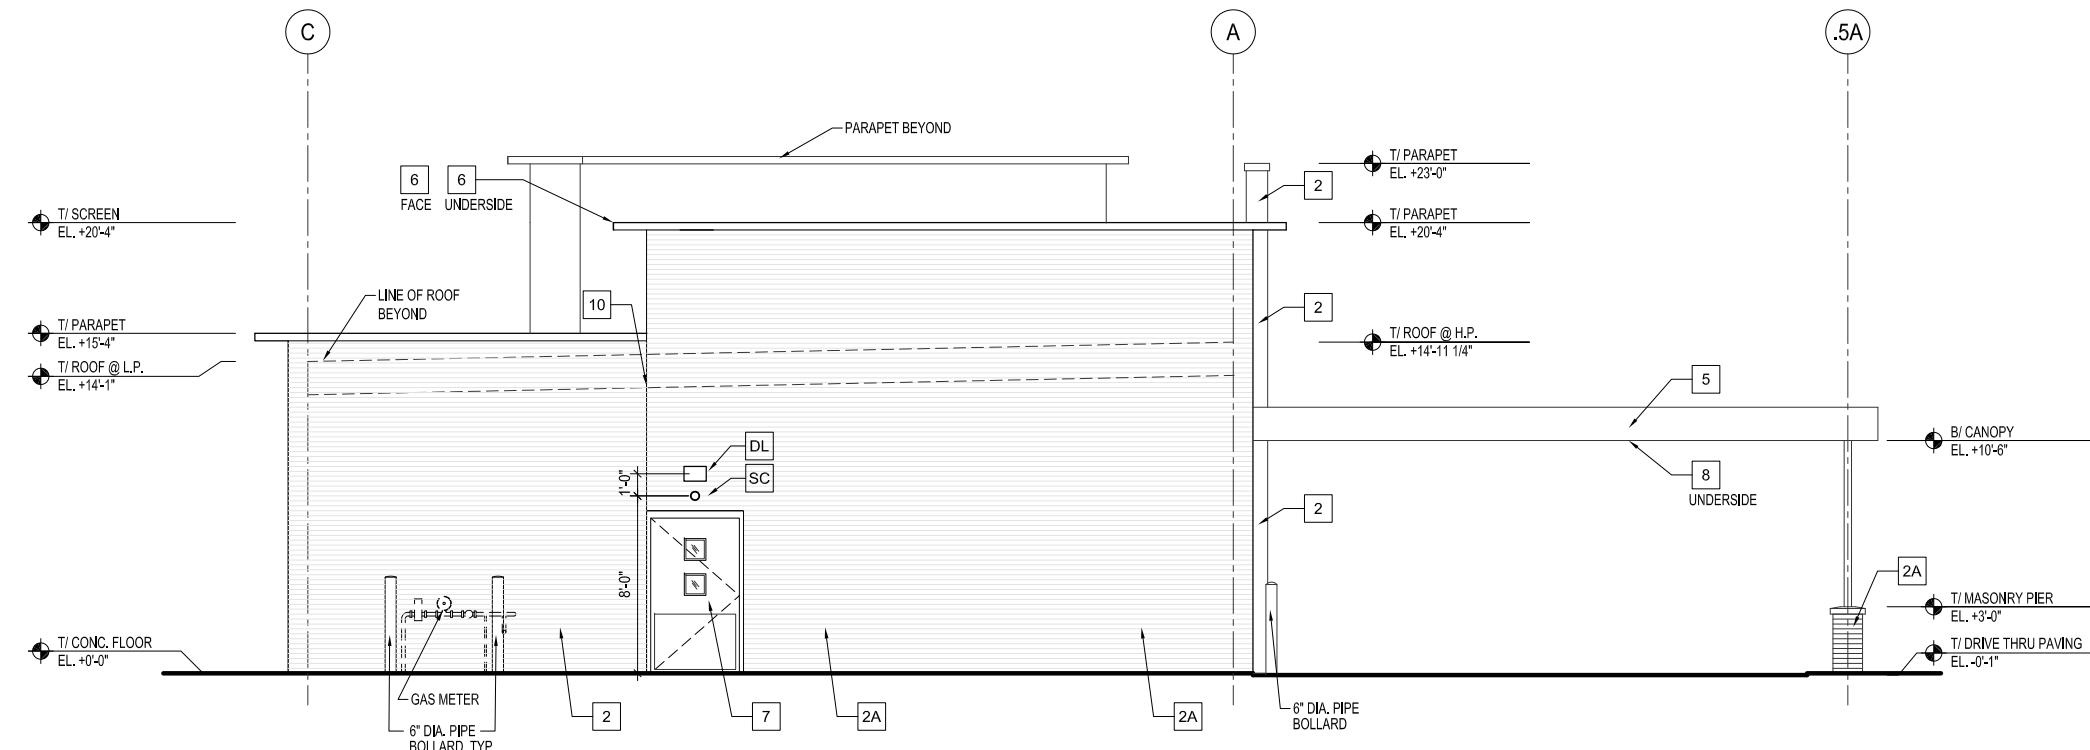


REAR - NORTH ELEVATION
Scale: N.T.S.

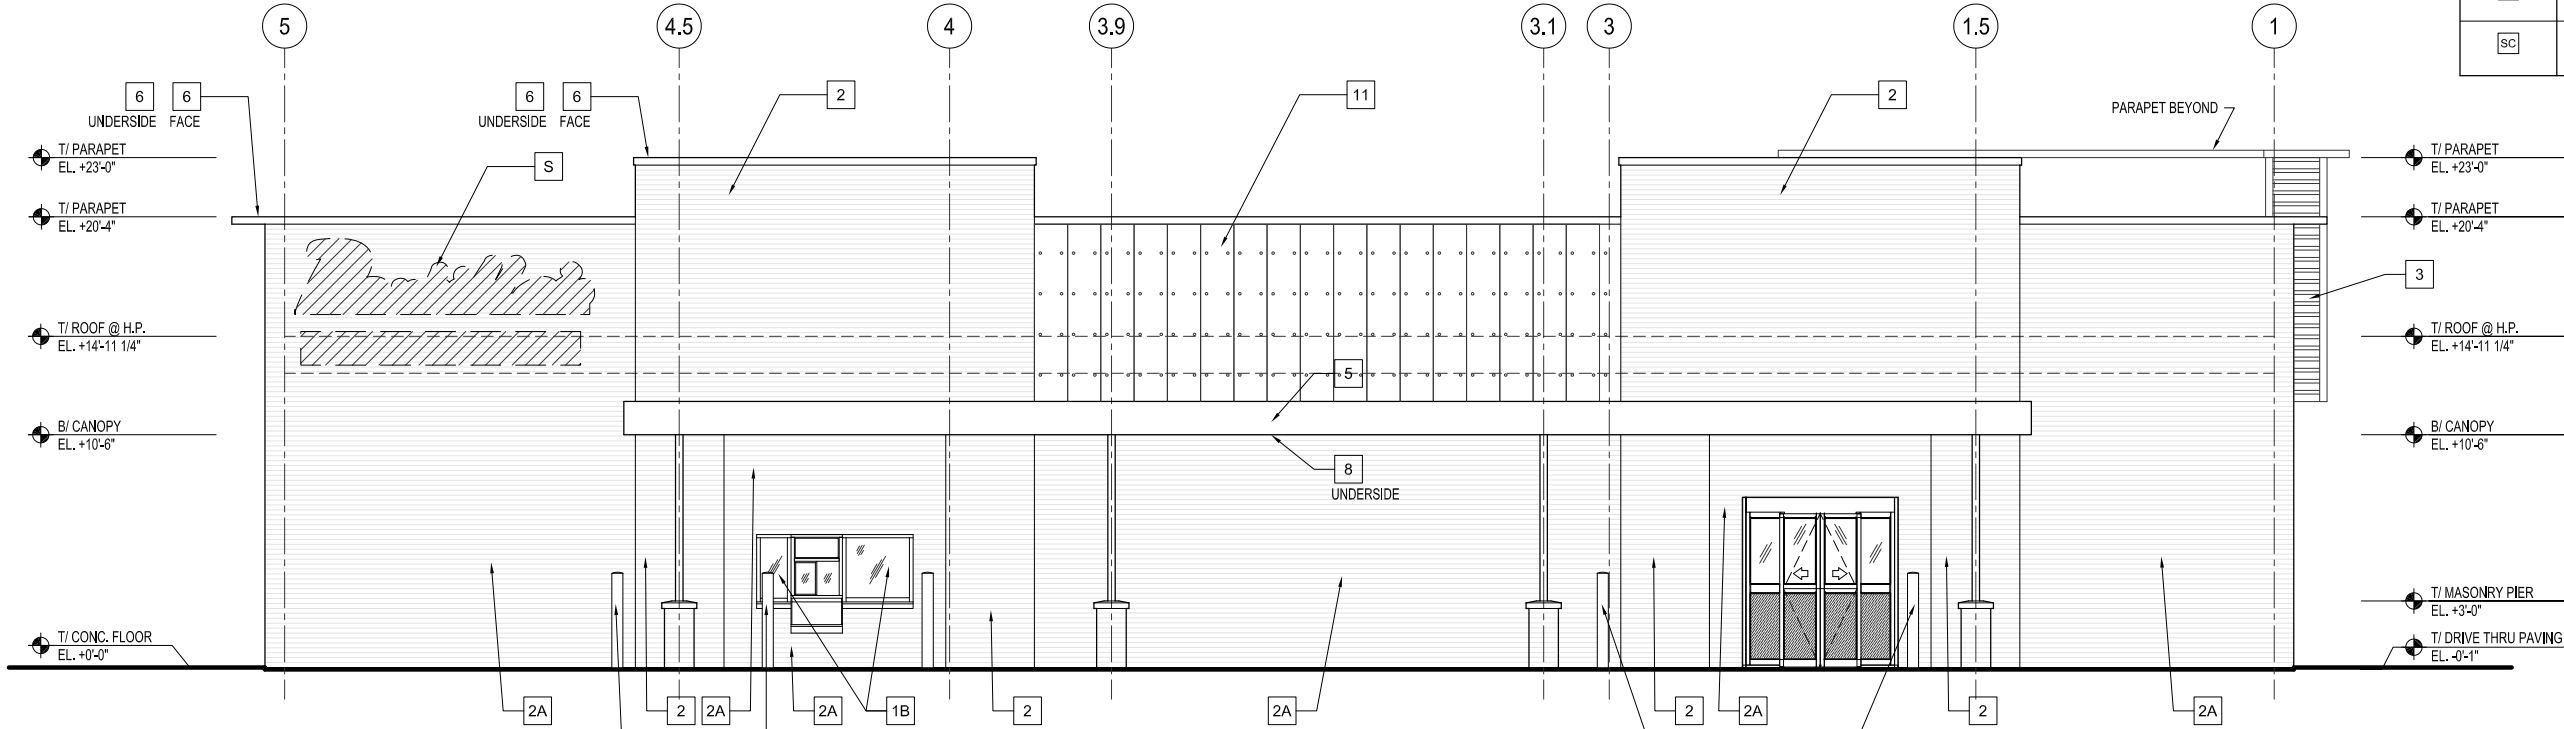

DRIVE-THRU - WEST ELEVATION
Scale: N.T.S.


MATERIAL SCHEDULE		
KEY NOTE	MATERIAL	MATERIAL SPECIFICATION
1A	ALUMINUM STOREFRONT	2"W x 4-1/2"D THERMALLY BROKEN PRE-FIN. ALUM. STOREFRONT W/ 1" INSULATED GLASS CENTER SET. OLD CASTLE SERIES 3000 OUTSIDE GLAZED OR EQUAL. COLORS: GLASS: "SOLAR GRAY" SOLARBAN 60 (TEMPERED AS REQUIRED); ALUM. CLEAR ANOD.
1B	ALUMINUM STOREFRONT	2"W x 4-1/2"D THERMALLY BROKEN PRE-FIN. ALUM. STOREFRONT W/ 1" INSULATED GLASS CENTER SET. OLD CASTLE SERIES 3000 OUTSIDE GLAZED OR EQUAL. COLORS: GLASS: CLEAR (TEMPERED AS REQUIRED); ALUM. CLEAR ANOD.
2	BRICK VENEER	BRICK VENEER RUNNING BOND MANUFACTURER: GLEN-GERY COLOR: CARDINAL RED GLAZED
2A	BRICK VENEER	BRICK VENEER RUNNING BOND MANUFACTURER: GLEN-GERY COLOR: "BLACK"
3	RIBBED METAL PANEL	HWP PANELS METAL ERA COLOR: BONE WHITE
4	BRAKE METAL/FASCIA	PREFINISHED METAL SOFFIT BOX/FASCIA METAL ERA OR EQUAL. CITADEL COLOR: SLATE GRAY
5	BRAKE METAL/FASCIA	PREFINISHED METAL SOFFIT BOX/FASCIA METAL ERA OR EQUAL. CITADEL COLOR: SLATE GRAY
6	BRAKE METAL/FASCIA	PREFINISHED SOFFIT PANELS 850 SOFFIT PANELS, ALUM. WITH TRIM, METAL ERA OR EQUAL. CITADEL COLOR: REGAL RED
7	PAINT	PAINT DOOR AND FRAME PAINT: SW6258 TRICORN BLACK
8	PAINT DECK	PAINT CEILING OF EXPOSED METAL SURFACES PAINT: SW6868 REAL RED
9	BREAK METAL	COLOR: TO MATCH CLEAR ANODIZED ALUMINUM
10	CONTROL JOINT	VENEER CONTROL JOINT. COLOR TO MATCH ADJACENT BRICK VENEER COLOR.
11	FIBER CEMENT BOARD	NICHHA ARCHITECTURAL WALL PANEL; CONCRETE TEXTURED DIMPLE CONCRETE WALL PANEL "EMPIRE BLOCK"
WS	WALL SCONCE LIGHT	UP AND DOWN WALL SCONCE LIGHT, WEATHERED PATINA FINISH
S	SIGNAGE	EXTERIOR SIGNAGE, REFER TO SIGNAGE DRAWINGS
DL	WALL MOUNTED DOWNLIGHT	WALL MOUNTED ARM DOWNLIGHT REFER TO ELECTRICAL DRAWINGS
SC	SECURITY CAMERA	WALL MOUNTED SECURITY CAMERA, SEE ELECT. DRAWINGS



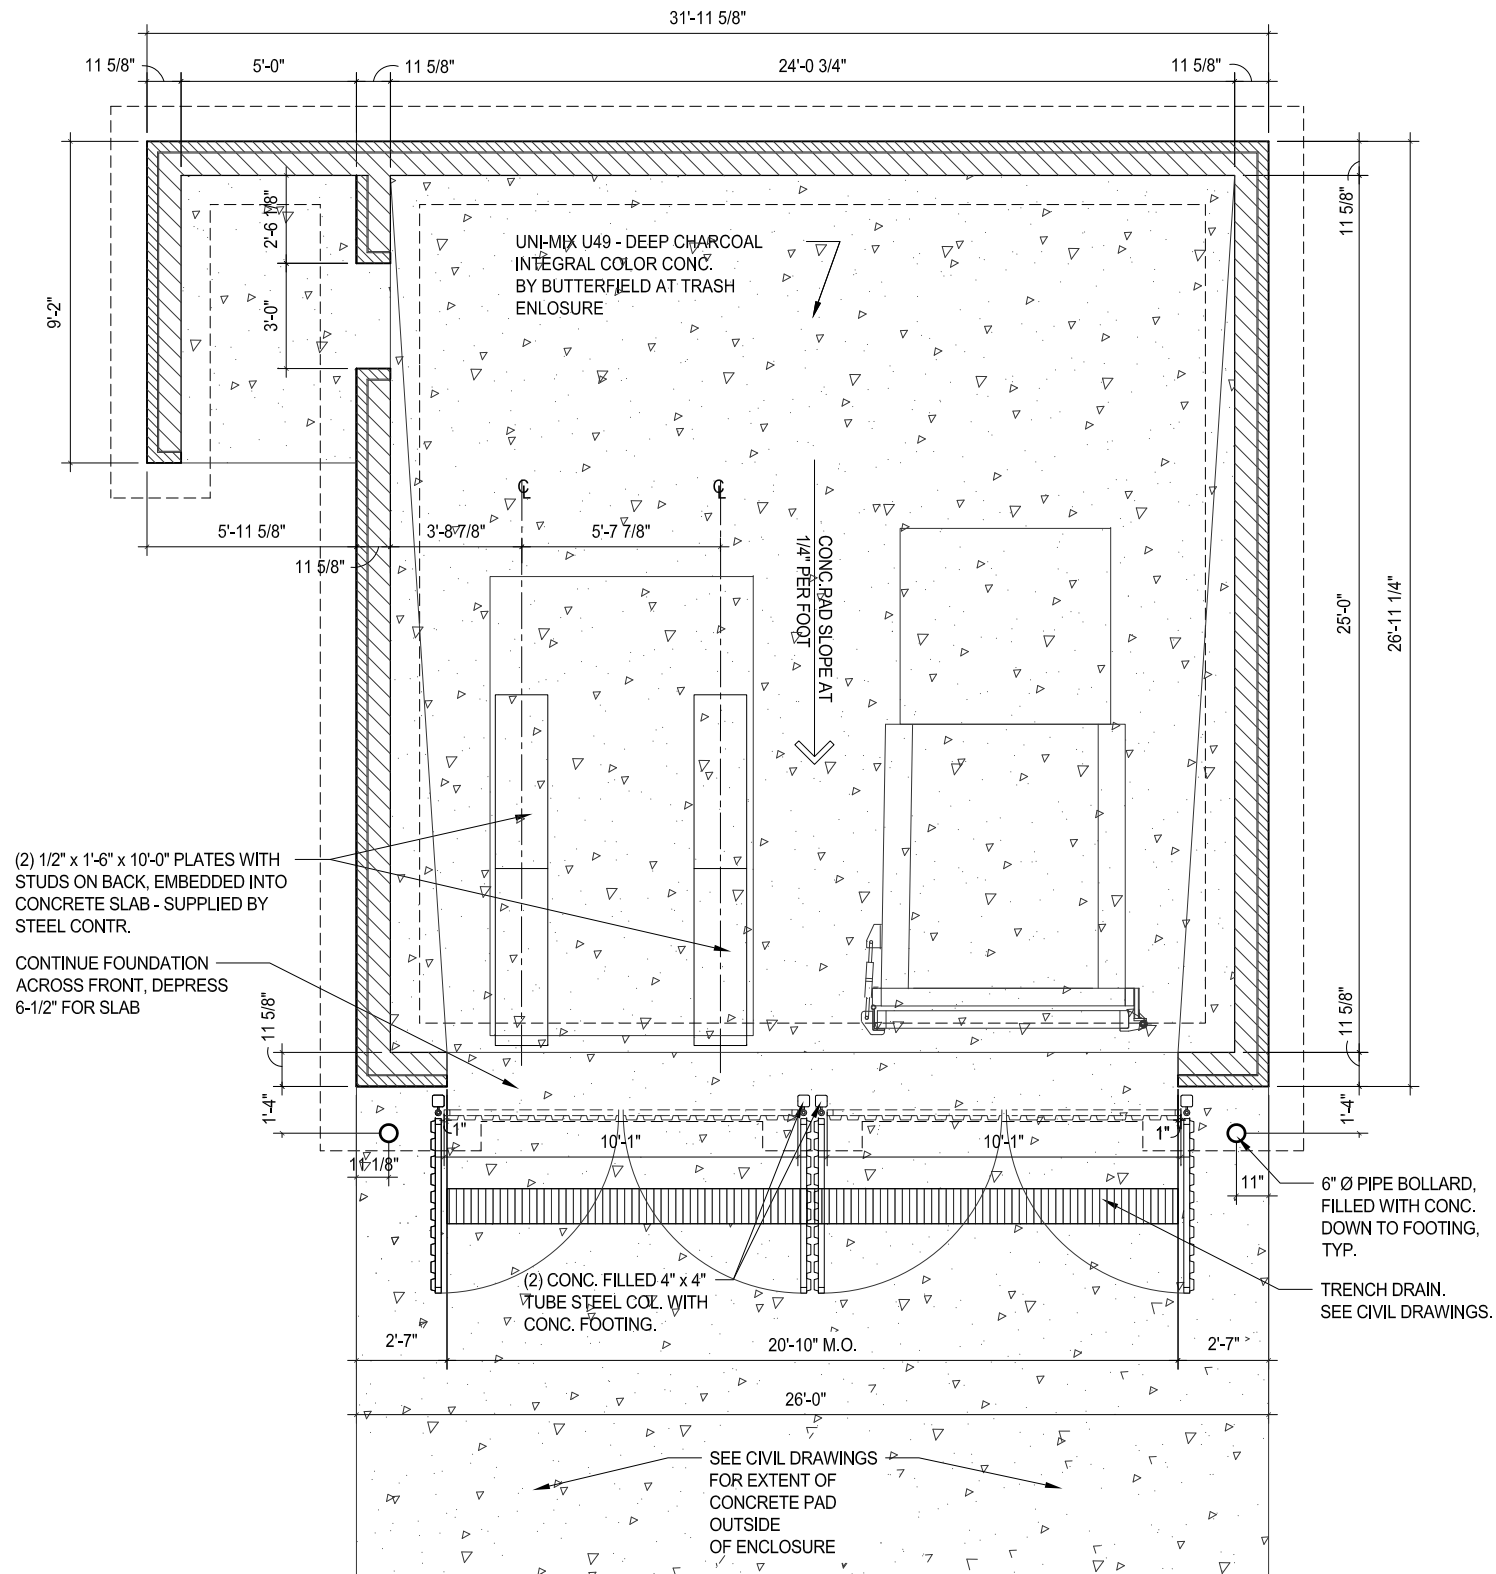


TRASH ENCLOSURE - PLAN

Scale: N.T.S.

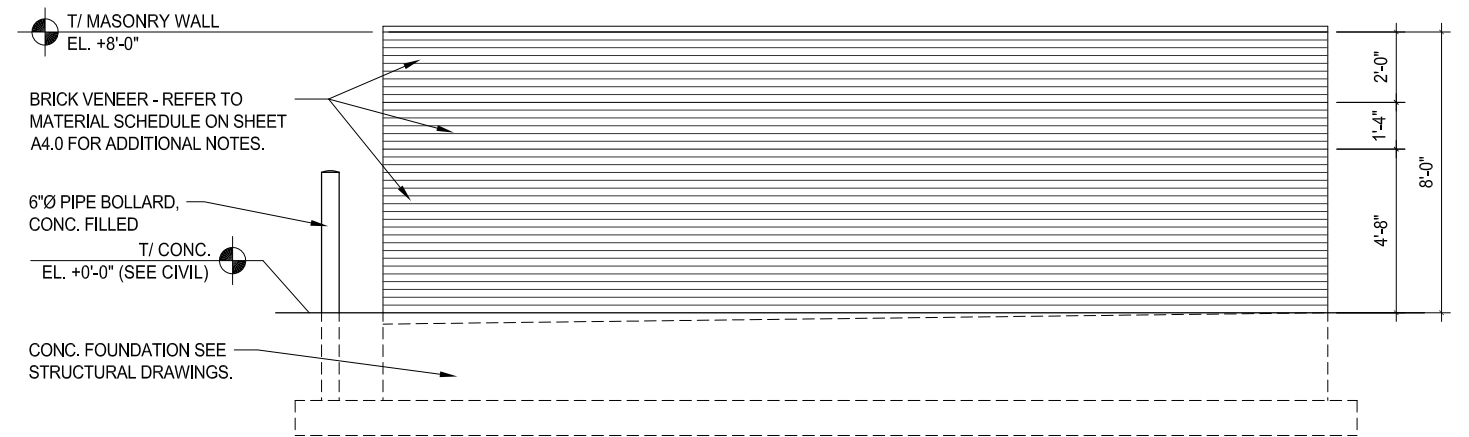

TRASH ENCLOSURE - SIDE ELEV.

Scale: N.T.S.

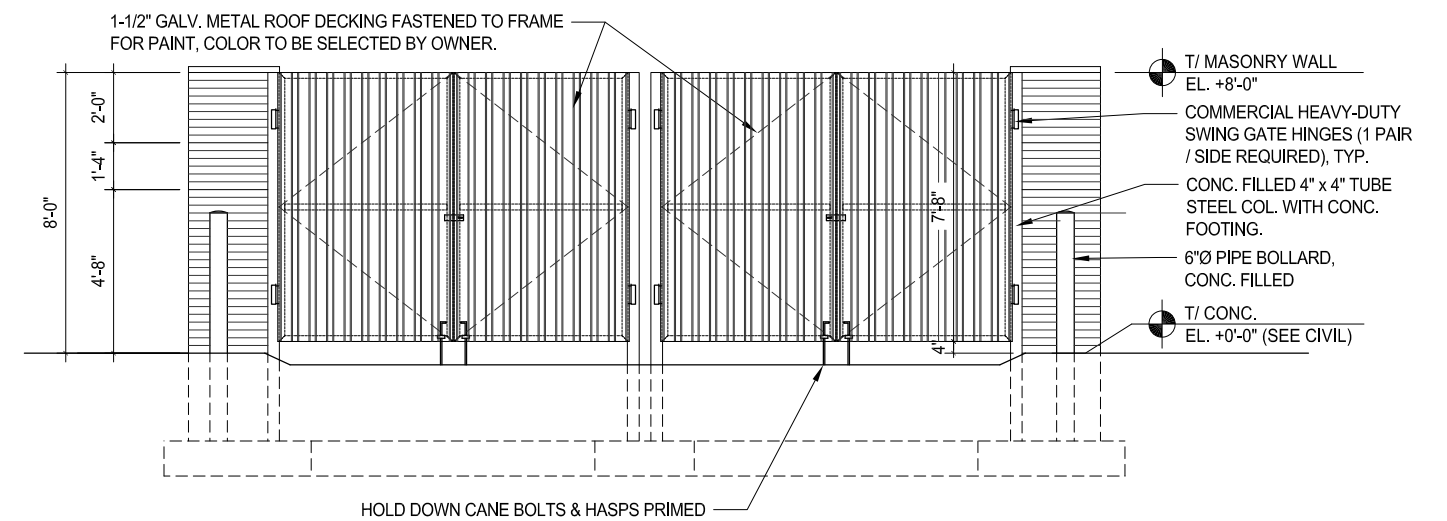

TRASH ENCLOSURE - FRONT ELEV.

Scale: N.T.S.


New Pick-Up Concept v1.0

FEBRUARY 5th, 2024




Portillo's - Pick-Up Restaurant
20 ORLAND SQUARE DRIVE, ORLAND PARK, IL



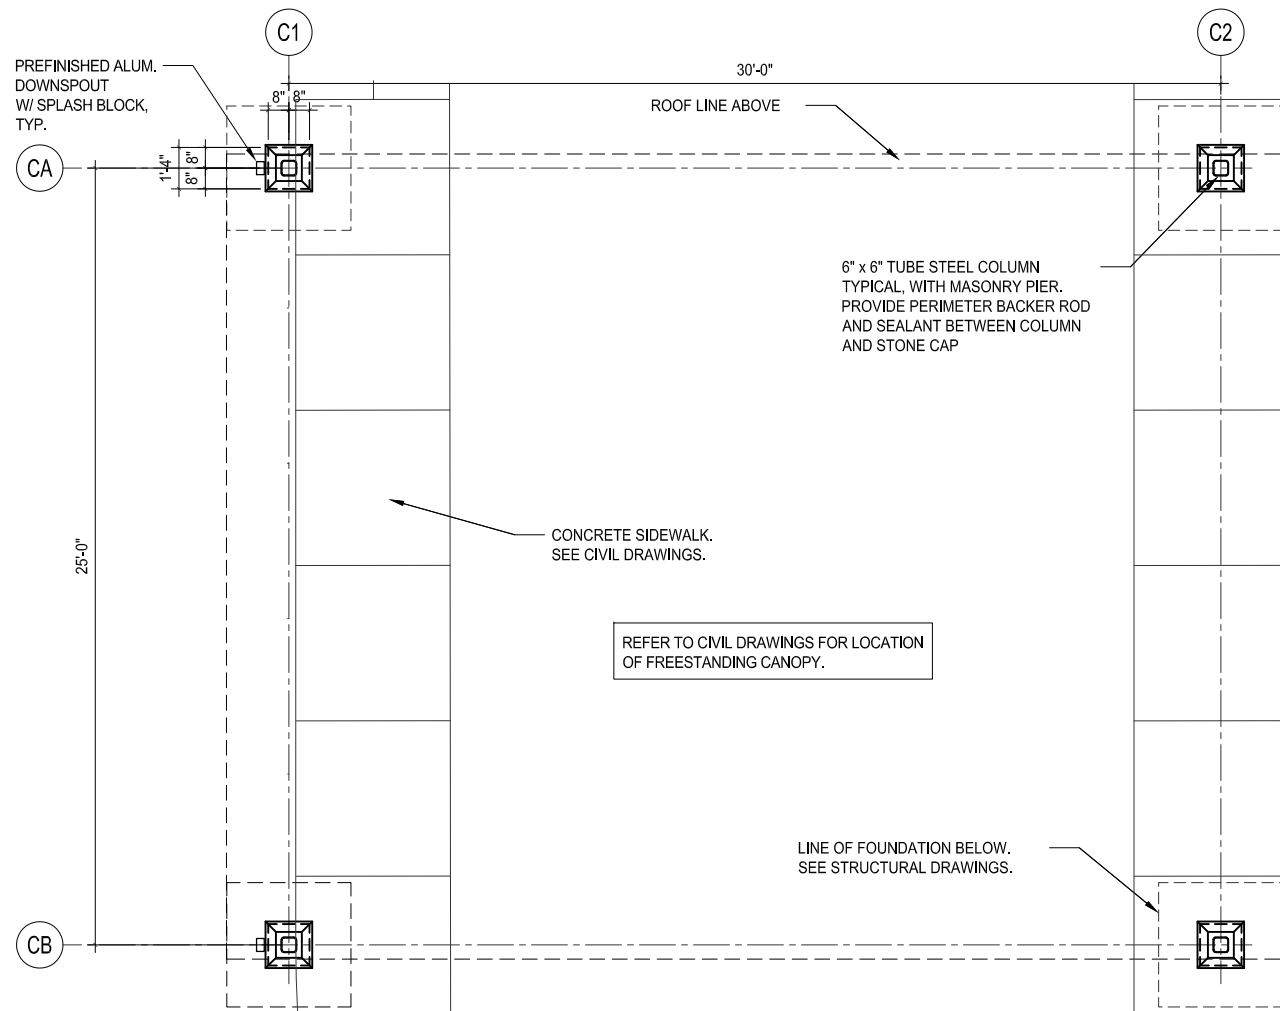


CREW CANOPY - PLAN

Scale: N.T.S.

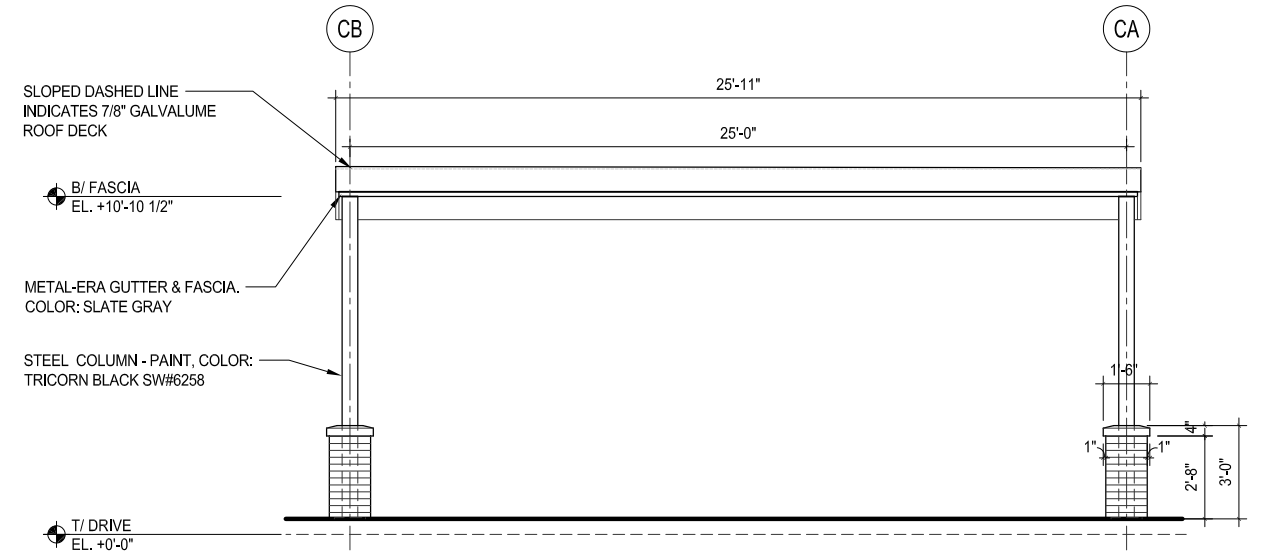


CREW CANOPY - SOUTH ELEV.

Scale: N.T.S.

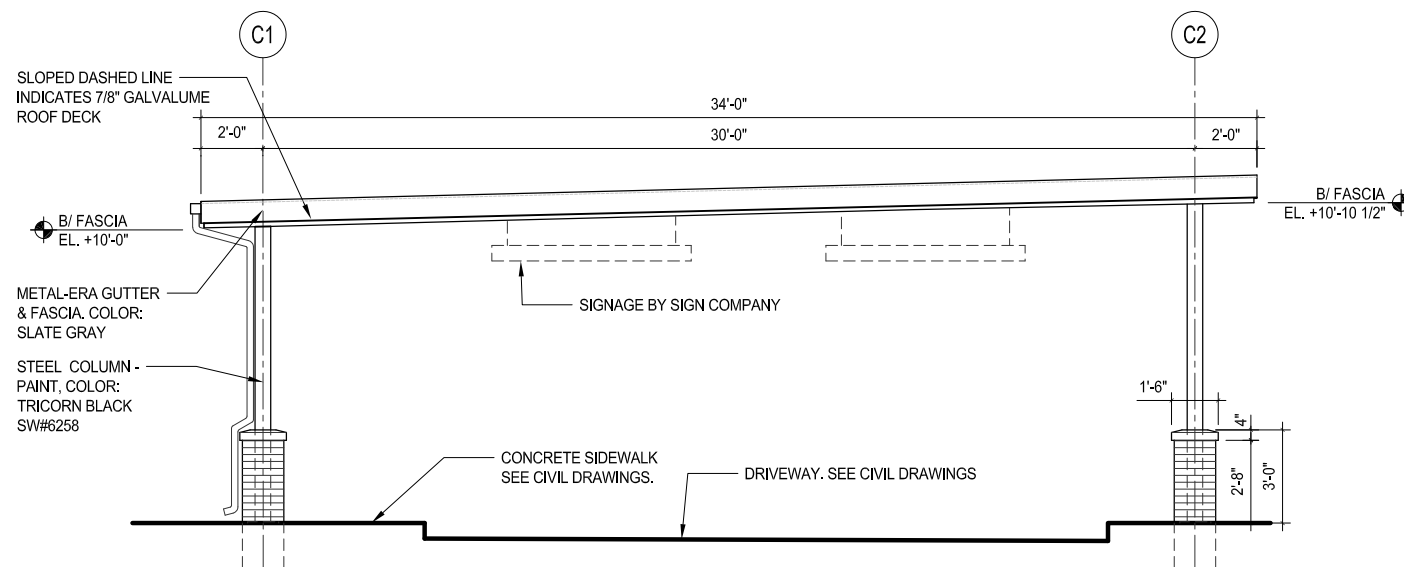

CREW CANOPY - WEST ELEV.

Scale: N.T.S.

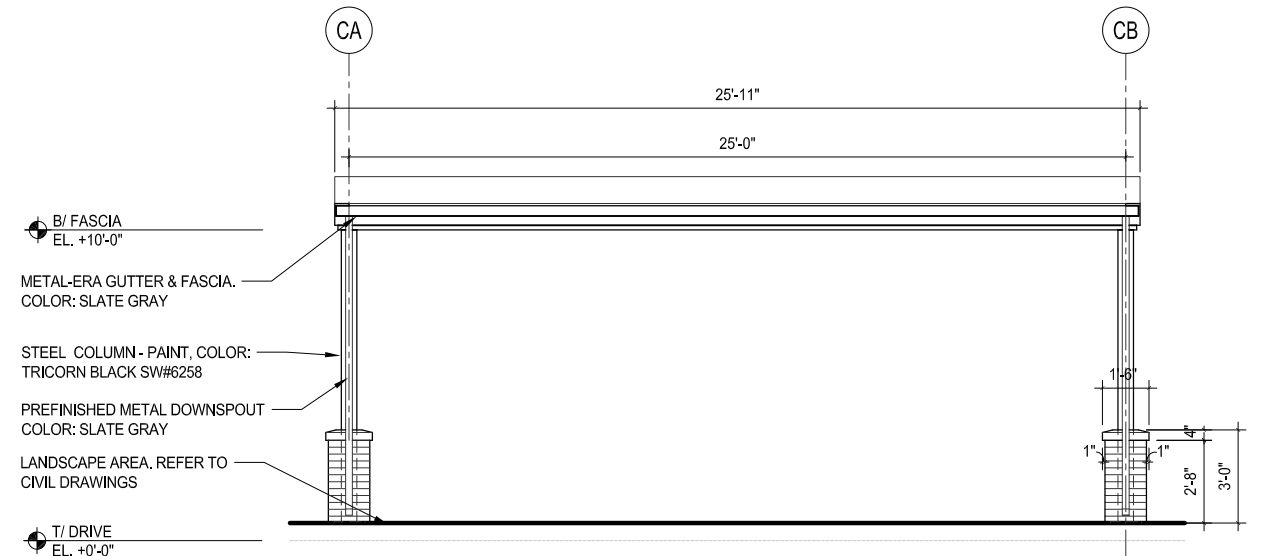

CREW CANOPY - NORTH ELEV.

Scale: N.T.S.

 
New Pick-Up Concept v1.0

FEBRUARY 5th, 2024




Portillo's - Pick-Up Restaurant
20 ORLAND SQUARE DRIVE, ORLAND PARK, IL





MetalEra: Matte Black

 

MetalEra: Bone White




MetalEra: Cardinal (REGAL) Red



MetalEra: Slate Gray



Glen-Gery Brick: "Black"

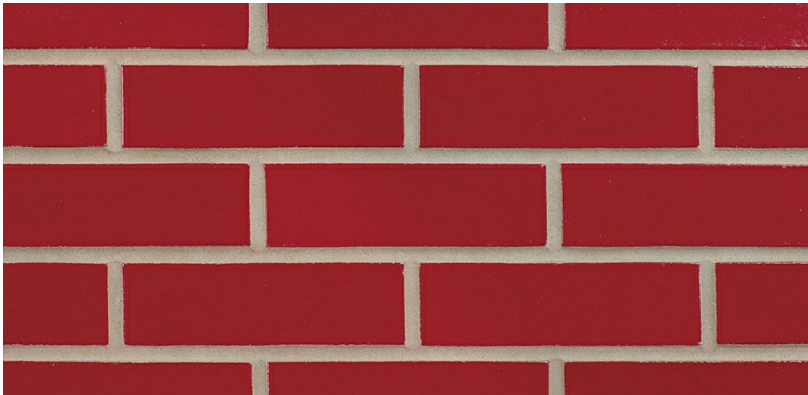

Glen-Gery Brick: Cardinal Red Glazed or equal



Nichiha Fiber Cement Panel Empire Block

MATERIAL SCHEDULE		
KEY NOTE	MATERIAL	MATERIAL SPECIFICATION
1A	ALUMINUM STOREFRONT	2"W x 4-1/2"D THERMALLY BROKEN PRE-FIN. ALUM. STOREFRONT W/ 1" INSULATED GLASS CENTER SET, OLD CASTLE SERIES 3000 OUTSIDE GLAZED OR EQUAL COLORS: GLASS, "SOLAR GRAY" SOLARBAN 60 (TEMPERED AS REQUIRED.), ALUM. CLEAR ANOD.
1B	ALUMINUM STOREFRONT	2"W x 4-1/2"D THERMALLY BROKEN PRE-FIN. ALUM. STOREFRONT W/ 1" INSULATED GLASS CENTER SET, OLD CASTLE SERIES 3000 OUTSIDE GLAZED OR EQUAL COLORS: GLASS, CLEAR (TEMPERED AS REQUIRED.), ALUM. CLEAR ANOD.
2	BRICK VENEER	BRICK VENEER RUNNING BOND MANUFACTURER: GLEN-GERY COLOR: CARDINAL RED GLAZED
2A	BRICK VENEER	BRICK VENEER RUNNING BOND MANUFACTURER: GLEN-GERY COLOR: "BLACK"
3	RIBBED METAL PANEL	HWP PANELS METAL ERA COLOR: BONE WHITE
4	BRAKE METAL/FASCIA	PREFINISHED METAL SOFFIT BOX/FASCIA METAL ERA OR EQUAL COLOR: MATTE BLACK
5	BRAKE METAL/FASCIA	PREFINISHED METAL SOFFIT BOX/FASCIA METAL ERA OR EQUAL CITADEL COLOR: SLATE GRAY
6	BRAKE METAL/FASCIA	PRE-FINISHED SOFFIT PANELS 850 SOFFIT PANELS, ALUM. WITH TRIM, METAL ERA OR EQUAL CITADEL COLOR: REGAL RED
7	PAINT	PAINT DOOR AND FRAME PAINT: SW6258 TRICORN BLACK
8	PAINT DECK	PAINT CEILING OF EXPOSED METAL SURFACES PAINT: SW6888 REAL RED
9	BREAK METAL	COLOR: TO MATCH CLEAR ANODIZED ALUMINUM
10	CONTROL JOINT	VENEER CONTROL JOINT. COLOR TO MATCH ADJACENT BRICK VENEER COLOR.
11	FIBER CEMENT BOARD	NICHIHA ARCHITECTURAL WALL PANEL: CONCRETE TEXTURED DIMPLE CONCRETE WALL PANEL 'EMPIRE BLOCK'
WS	WALL SCONCE LIGHT	UP AND DOWN WALL SCONCE LIGHT, WEATHERED PATINA FINISH
S	SIGNAGE	EXTERIOR SIGNAGE, REFER TO SIGNAGE DRAWINGS
DL	WALL MOUNTED DOWNLIGHT	WALL MOUNTED ARM DOWNLIGHT REFER TO ELECTRICAL DRAWINGS
SC	SECURITY CAMERA	WALL MOUNTED SECURITY CAMERA. SEE ELECT. DRAWINGS



Portillo's Orland Park, IL - Exterior Material & Color Palette Board

Orland Park, IL - Building Streetview 3D Color Rendering for Reference



Orland Park, IL - Monument Sign Color Rendering for Reference




Portillo's Orland Park, IL - Entry Corner Rendering




Portillo's Orland Park, IL - Rear Corner Rendering



Portillo's Orland Park, IL - Front Elevation Rendering

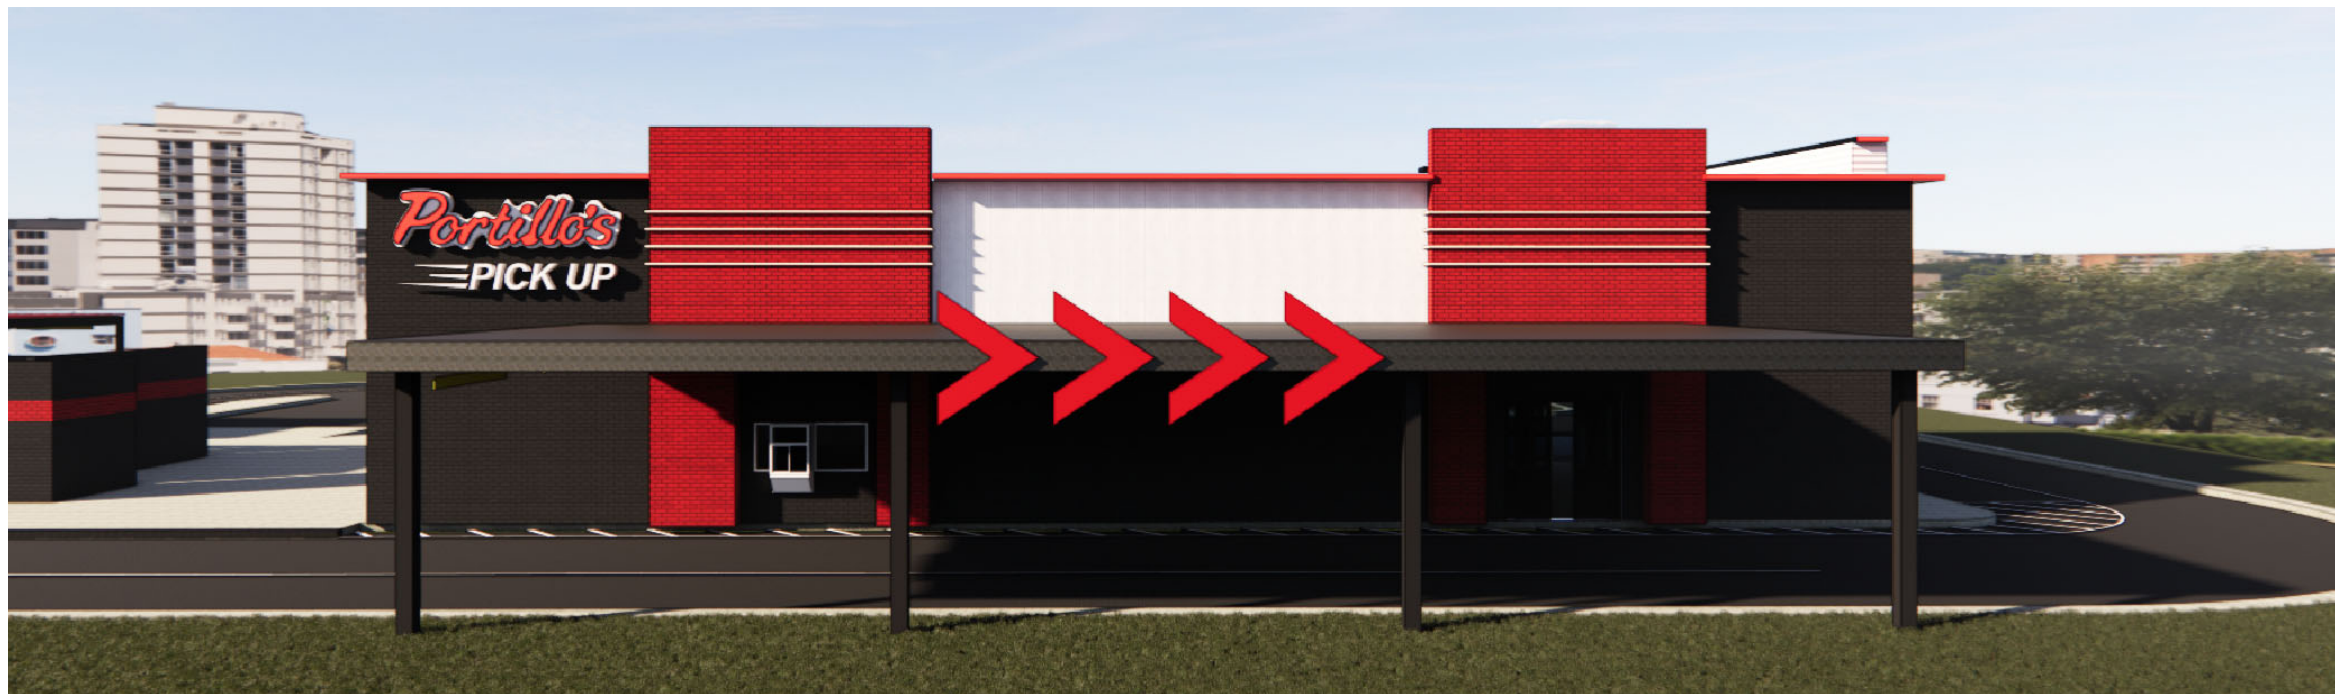

Portillo's Orland Park, IL - Drive-Thru Elevation Rendering




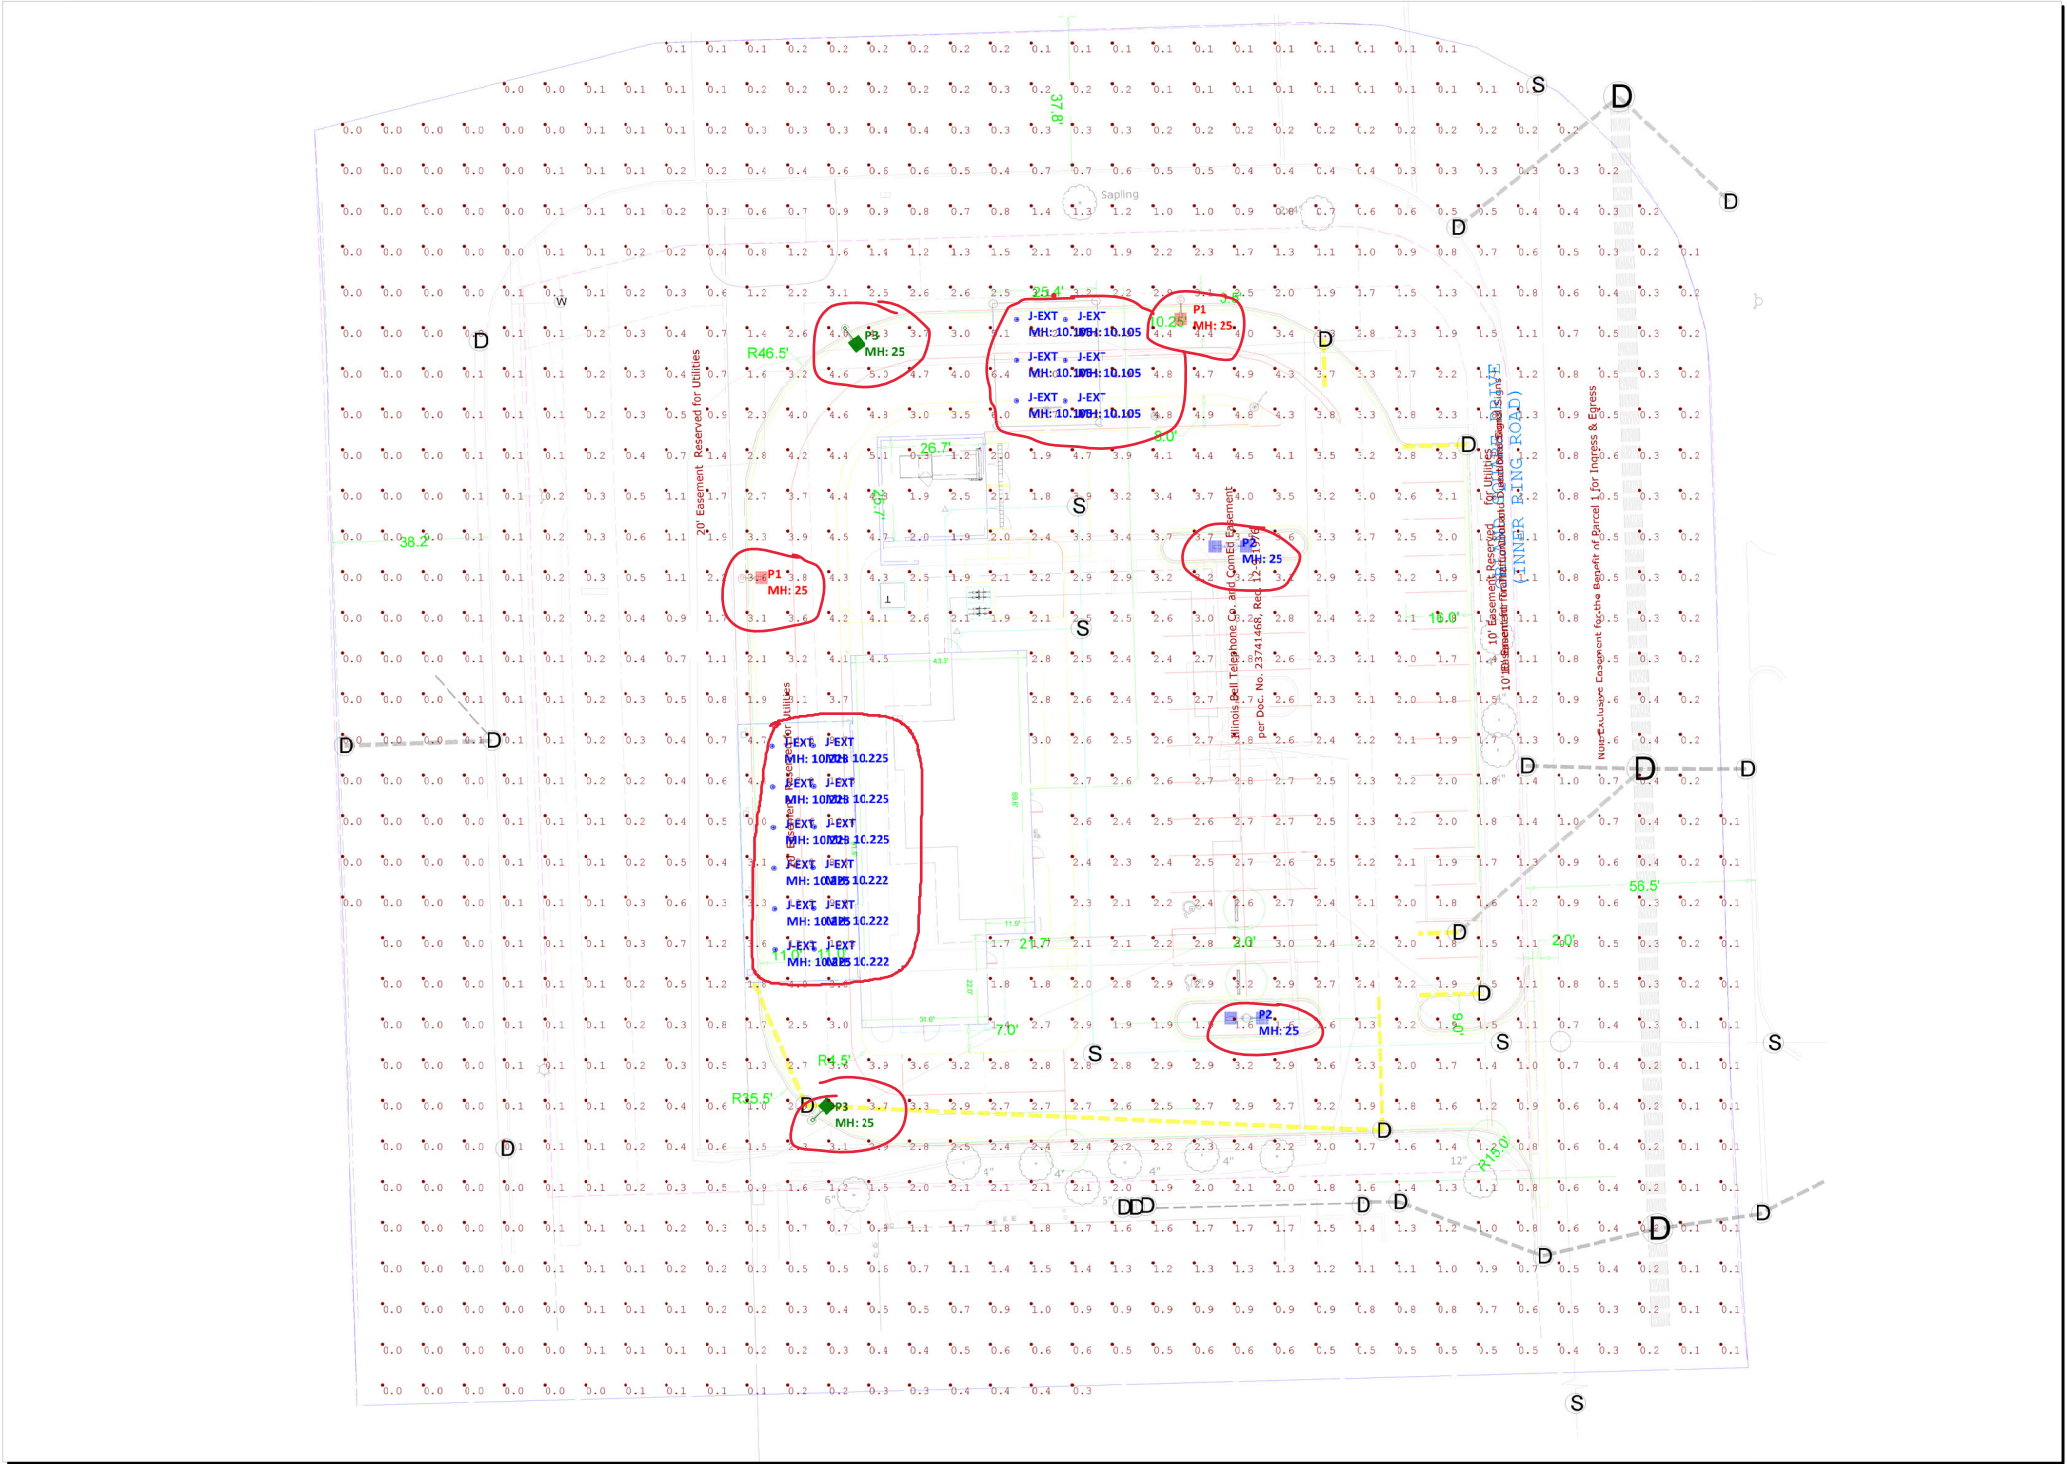


Luminaire Schedule				
Symbol	Qty	LLF	Description	Type
	18	1.000	LDN4 40_10 LO4AR LSS	J-EXT
	2	1.000	DSX1 LED P6 40K 80CRI T2M	P1
	2	1.000	DSX1 LED P6 40K 80CRI T5W	P2
	2	1.000	DSX1 LED P6 40K 80CRI TFTM	P3

**This document contains confidential and proprietary information of KSA Lighting & Controls. This document may only be used by or for the benefit of KSA Lighting & Controls representatives and customers. This lighting layout is not a professional engineering drawing and is provided for informational purposes only, without warranty as to accuracy, completeness, reliability or otherwise. KSA Lighting & Controls is not responsible for specifying the light fixtures or illumination requirements for any specific project, nor is it responsible for meeting municipal or building code requirements. It is the obligation of the end-user to consult with a professional engineering advisor to determine whether this lighting layout meets the applicable project requirements for lighting system performance, safety, suitability and effectiveness for use in a particular application. Field verification is recommended when calculations are based on end-user or customer-provided information. End-user environment and application (including, but not limited to, voltage variation and dirt accumulation) can cause actual field performance to differ from the calculated photometric performance represented in this lighting layout. In no event will KSA Lighting & Controls be responsible for any loss resulting from any use of this drawing.

Calculation Summary						
Label	CalcType	Units	Avg	Max	Min	Avg/Min
Object_12_Planar	Illuminance	Fc	1.40	16.5	0.0	N.A.

- Notes :
1. Calculation Work Plane : Ground Level
 2. Fixture Mounting Height : 25'
 3. Calculation Point Spacing : 10' x10'

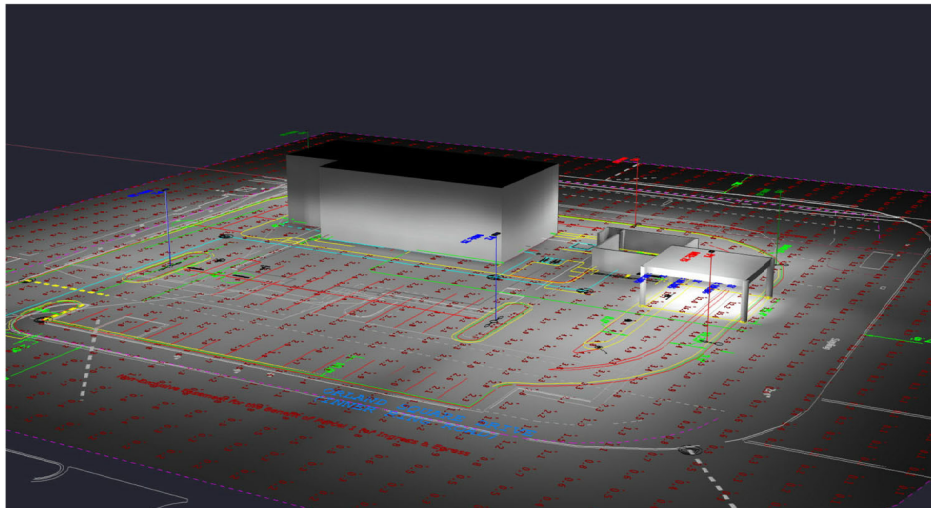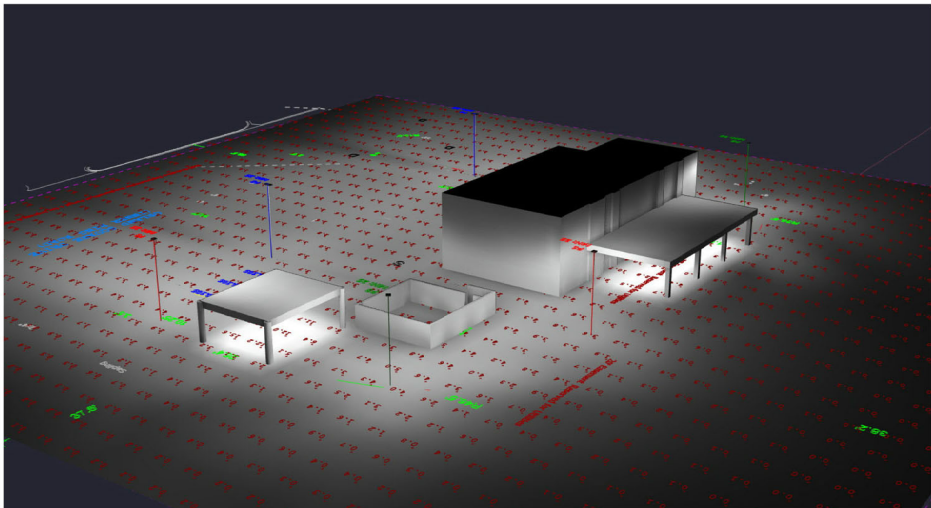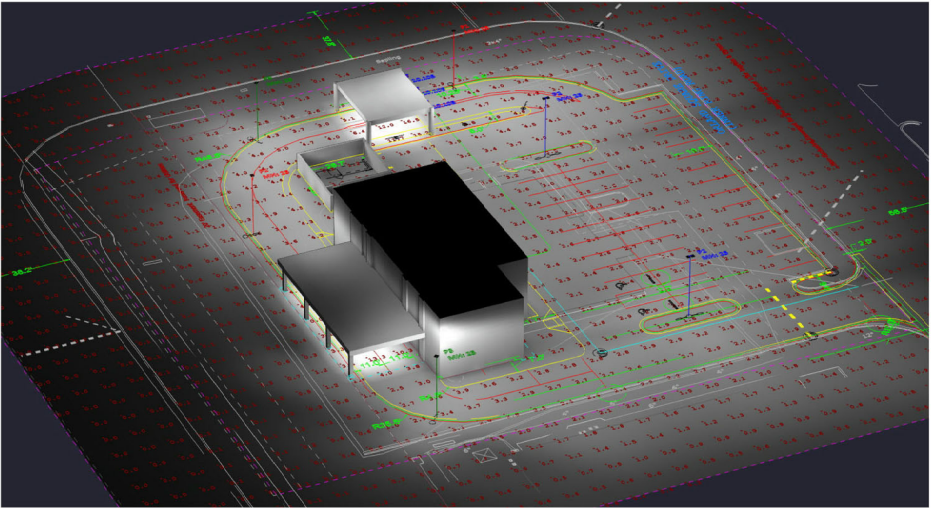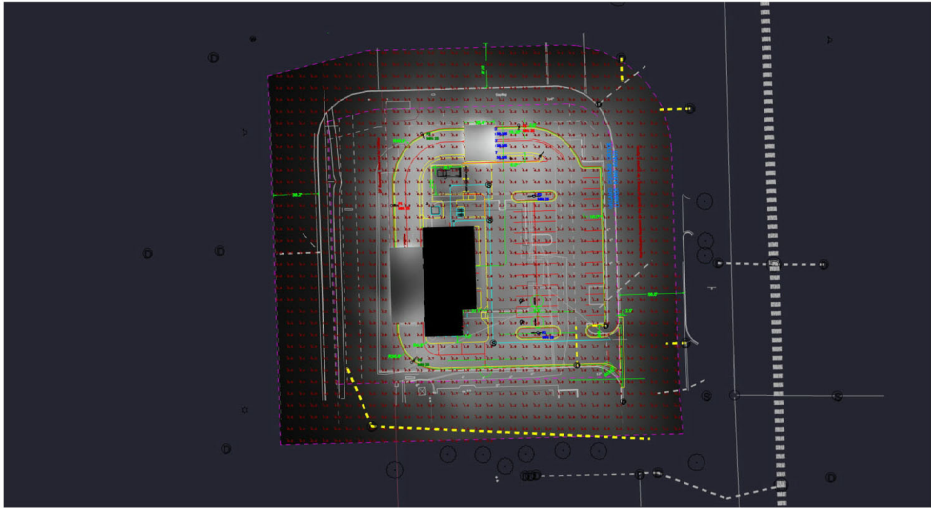

Luminaire Schedule				
Symbol	Qty	LLF	Description	Type
	18	1.000	LDN4 40' 10' LO4AR LSS	J-EXT
	2	1.000	DSX1 LED P6 40K 80CRI T2M	P1
	2	1.000	DSX1 LED P6 40K 80CRI T5W	P2
	2	1.000	DSX1 LED P6 40K 80CRI TFTM	P3

**This document contains confidential and proprietary information of KSA Lighting & Controls. This document may only be used by or for the benefit of KSA Lighting & Controls representatives and customers. This lighting layout is not a professional engineering drawing and is provided for informational purposes only, without warranty as to accuracy, completeness, reliability or otherwise. KSA Lighting & Controls is not responsible for specifying the light fixtures or illumination requirements for any specific project, nor is it responsible for meeting municipal or building code requirements. It is the obligation of the end-user to consult with a professional engineering advisor to determine whether this lighting layout meets the applicable project requirements for lighting system performance, safety, suitability and effectiveness for use in a particular application. Field verification is recommended when calculations are based on end-user or customer-provided information. End-user environment and application (including, but not limited to, voltage variation and dirt accumulation) can cause actual field performance to differ from the calculated photometric performance represented in this lighting layout. In no event will KSA Lighting & Controls be responsible for any loss resulting from any use of this drawing.

Calculation Summary							
Label	CalcType	Units	Avg	Max	Min	Avg/Min	Max/Min
Object_12_Planar	Illuminance	Fc	1.40	16.5	0.0	N.A.	N.A.

- Notes :
1. Calculation Work Plane : Ground Level
 2. Fixture Mounting Height : 25'
 3. Calculation Point Spacing : 10' x10'

Drawn By: Scott Shellberg
Date: 2/7/2024
Notes:



Portillo's - Pick-Up Restaurant

20 ORLAND SQUARE DRIVE, ORLAND PARK, IL

