


ABBREVIATIONS

AF	ABOVE FINISHED FLOOR
AGL	ABOVE GRADE LEVEL
AMSL	ABOVE MEAN SEA LEVEL
APPROX	APPROXIMATE
AWG	AMERICAN WIRE GAUGE
BLDG	BUILDING
BTS	BASE TRANSMISSION STATION
CCD	CITY OF CHICAGO DATUM
CLR	CLEAR
COL	COLUMN
CONC	CONCRETE
CND	CONDUIT
DWG	DRAWING
FT	FOOT(FEET)
EGS	EQUIPMENT GROUND BAR
ELEC	ELECTRICAL
EMT	ELECTRICAL METALLIC TUBING
ELEV	ELEVATION
EQUIP	EQUIPMENT
EXISTING	EXISTING
EXT	EXTERIOR
FND	FOUNDATION
GA	GAUGE
GALV	GALVANIZED
GPS	GLOBAL POSITIONING SYSTEM
GND	GROUND
MAX	MAXIMUM
MFR	MANUFACTURER
MGB	MASTER GROUND BAR
MIN	MINIMUM
NTS	NOT TO SCALE
O.C.	ON CENTER
OE/OT	OVERHEAD ELECTRIC/TELCO
PCS	PERSONAL COMMUNICATIONS SERVICES
RGS	RIGID GALVANIZED STEEL
IN	INCHES
INT	INTERIOR
LB/FT	POUND(S)
SF	SQUARE FOOT
STL	STEEL
TYP	TYPICAL
UE/UT	UNDERGROUND ELECTRIC/TELCO
UNO	UNLESS NOTED OTHERWISE
VF	VERIFY IN FIELD
W	WITH
XTMR	TRANSFORMER
E	CENTERLINE
PLATE	PLATE

SYMBOLS

	UTILITY POLE
	WORK POINT
	REVISION
	MASONRY
	BRICK
	CONCRETE
	EARTH
	STEEL
	GRAVEL
	CENTER LINE
	PROPERTY LINE
	LEASE LINE
	EASEMENT LINE
	CHAIN LINK FENCE
	WOOD FENCE
	BELOW GRADE ELECTRIC
	BELOW GRADE TELEPHONE
	OVERHEAD ELECTRIC/TELEPHONE
	SECTION REFERENCE

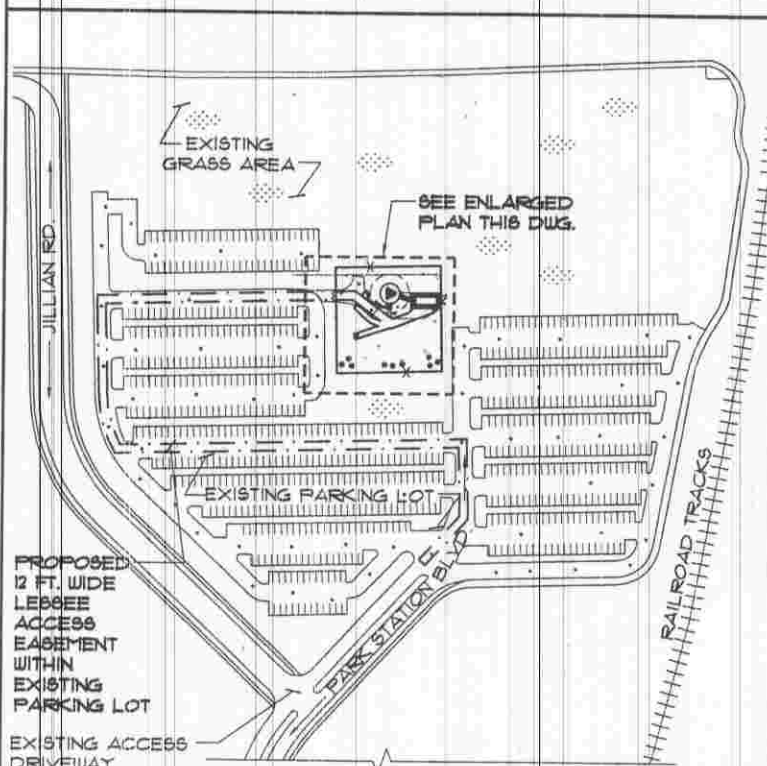


KEY PLAN

SCALE: N.T.S.

1

SITE PLAN

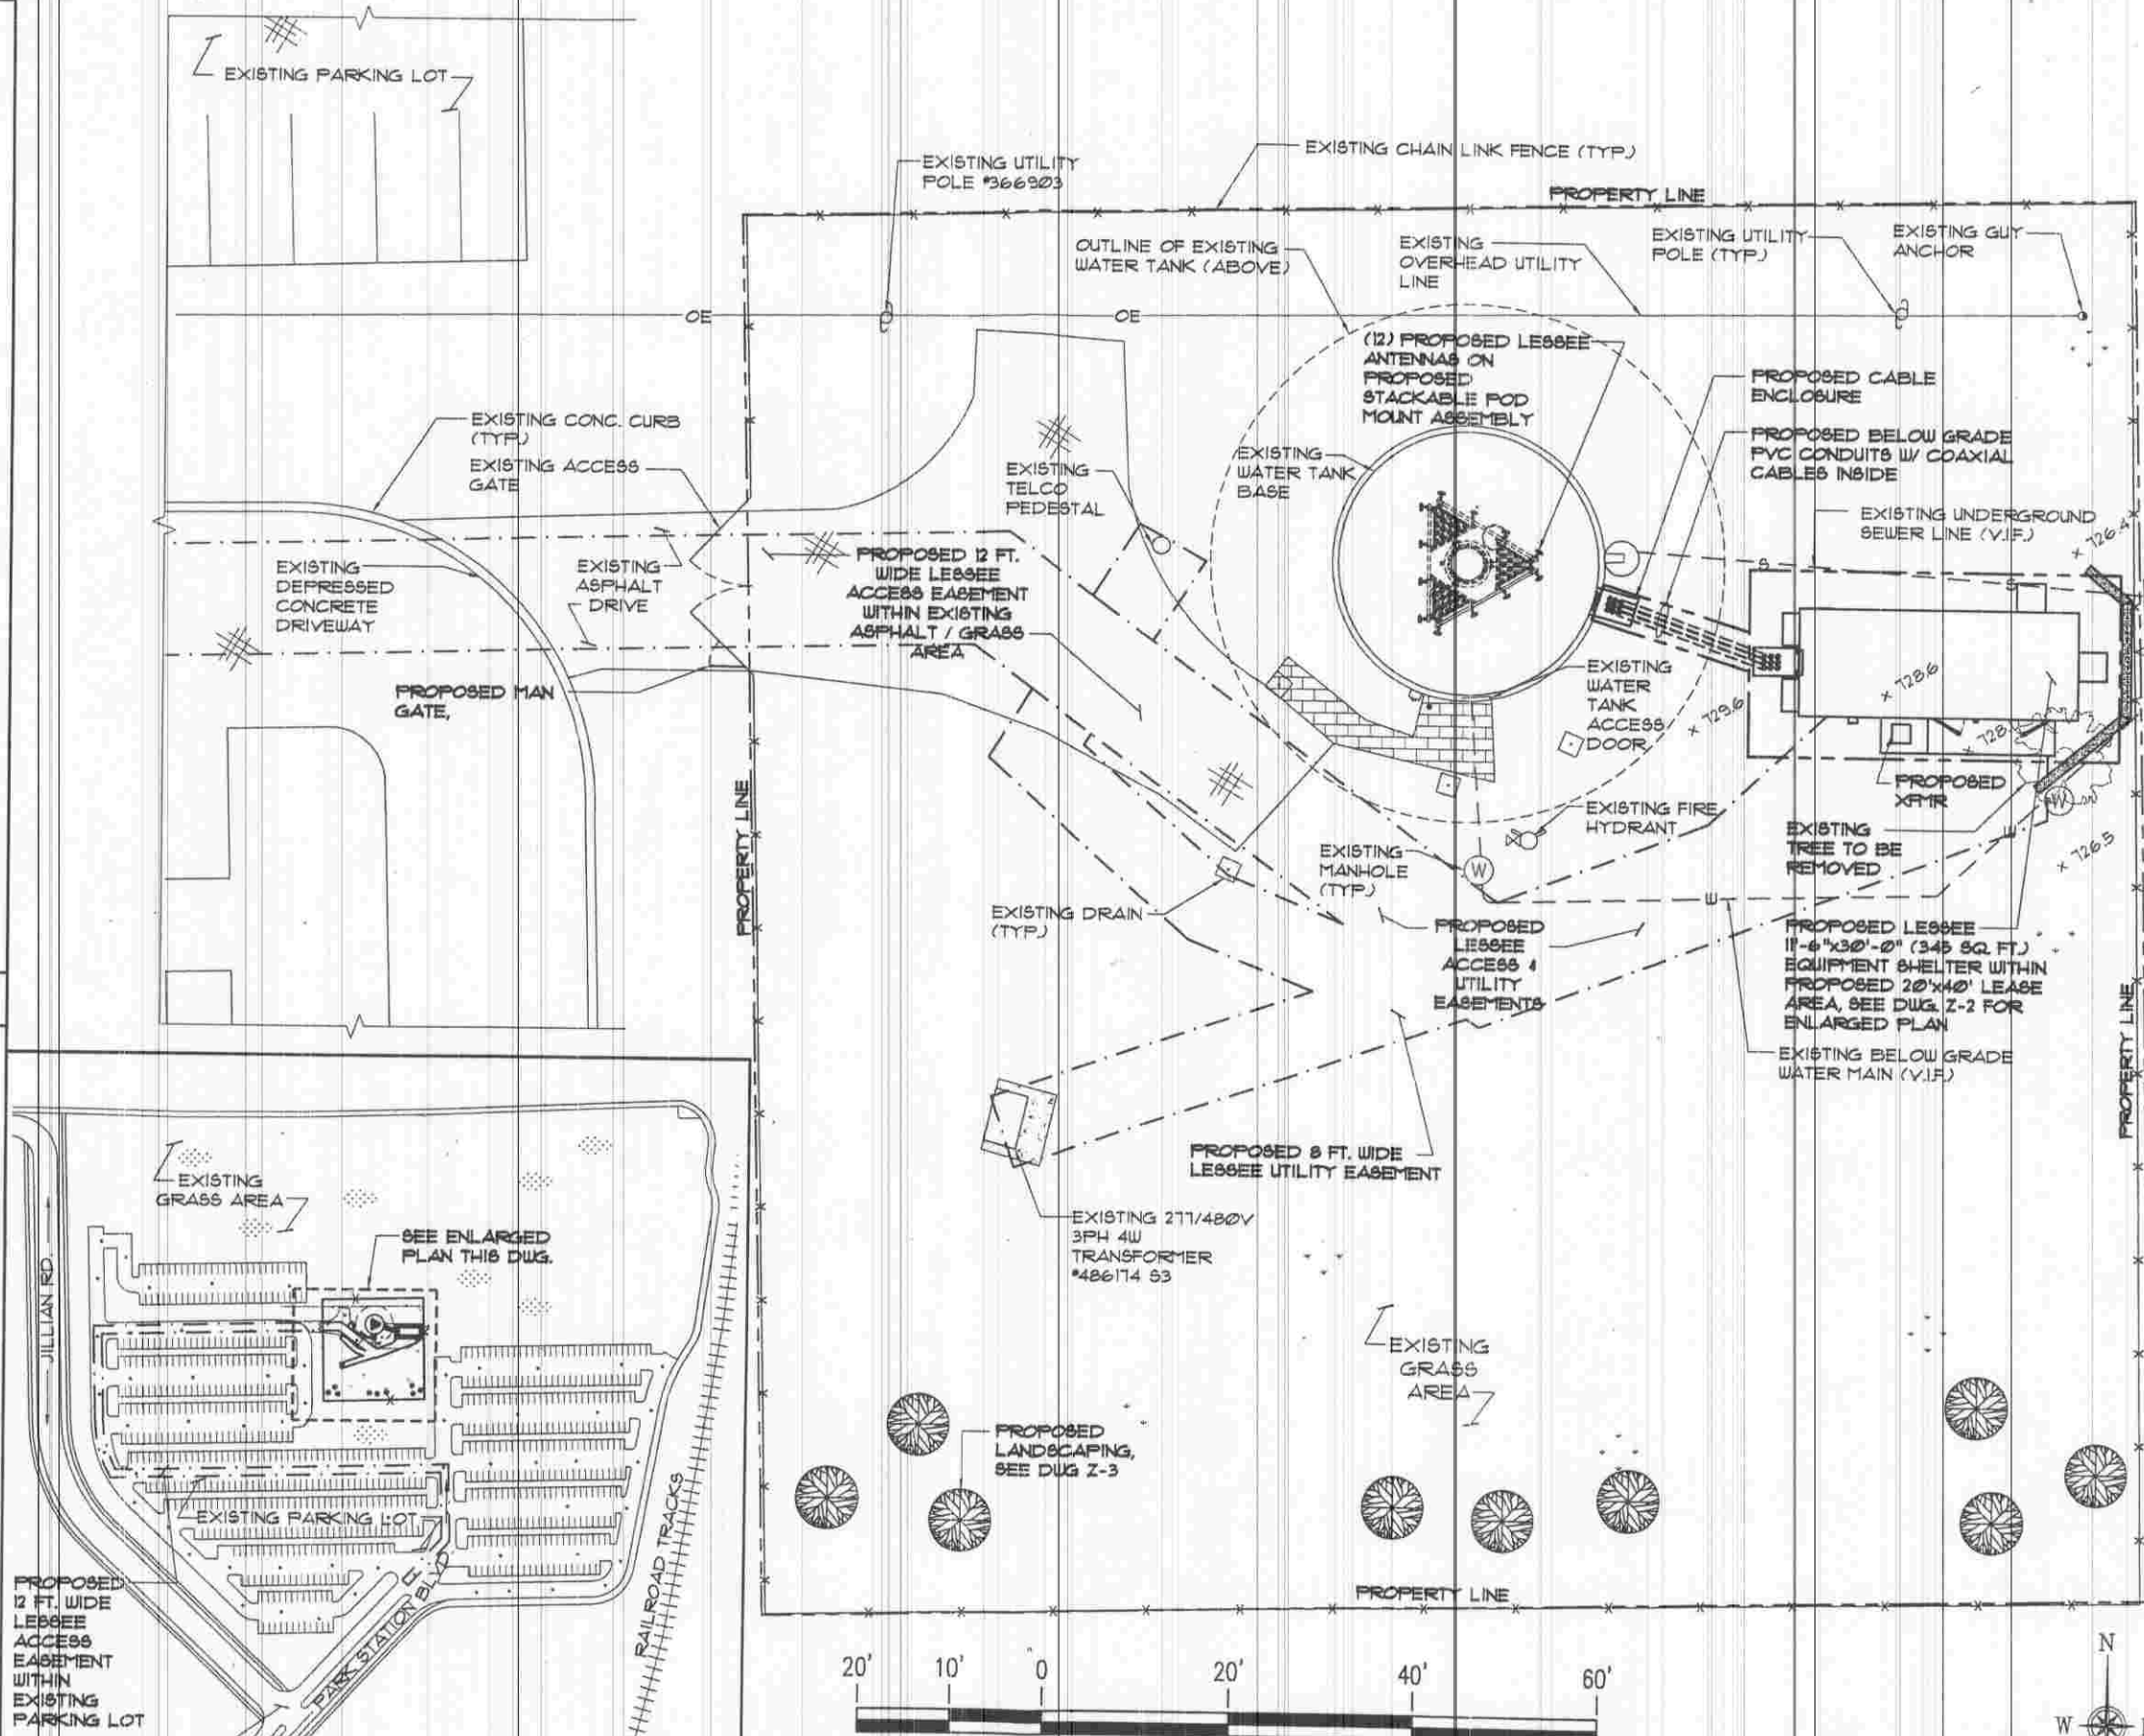

Chicago SMSA

Limited Partnership
d/b/a Verizon Wireless
1515 Woodfield Rd.
Suite 1400,
Schaumburg, IL 60173

Fullerton
Engineering Consultants

9100 W. Higgins Rd, Suite 800
Rosemont, Illinois 60018
Tel. 847-292-0100
Fax 847-292-0105

THIS DRAWING IS THE PROPERTY OF FULLERTON ENGINEERING CONSULTANTS, INC. IT IS FOR THE EXCLUSIVE USE OF THIS PROJECT. ANY RE-USE OF THIS DRAWING WITHOUT THE EXPRESSED WRITTEN CONSENT OF FULLERTON ENGINEERING CONSULTANTS, INC. IS PROHIBITED.

SITE NAME

RT. 7 & WEST

LOCATION NUMBER

187771

PROJECT NUMBER

2008284367

SITE ADDRESS

1501 PARK STATION BLVD.
ORLAND PARK, IL 60467

#	DATE	REVISIONS	
	05/15/09	ZONING	AU
	08/14/09	ZONING	AU

CHECKED BY: RI

APPROVED BY: MB

DATE SIGNED:

EXPIRATION DATE:

SHEET TITLE

SITE PLAN

SHEET NUMBER

Z-1

SCALE: 1"=20'-0"

2