


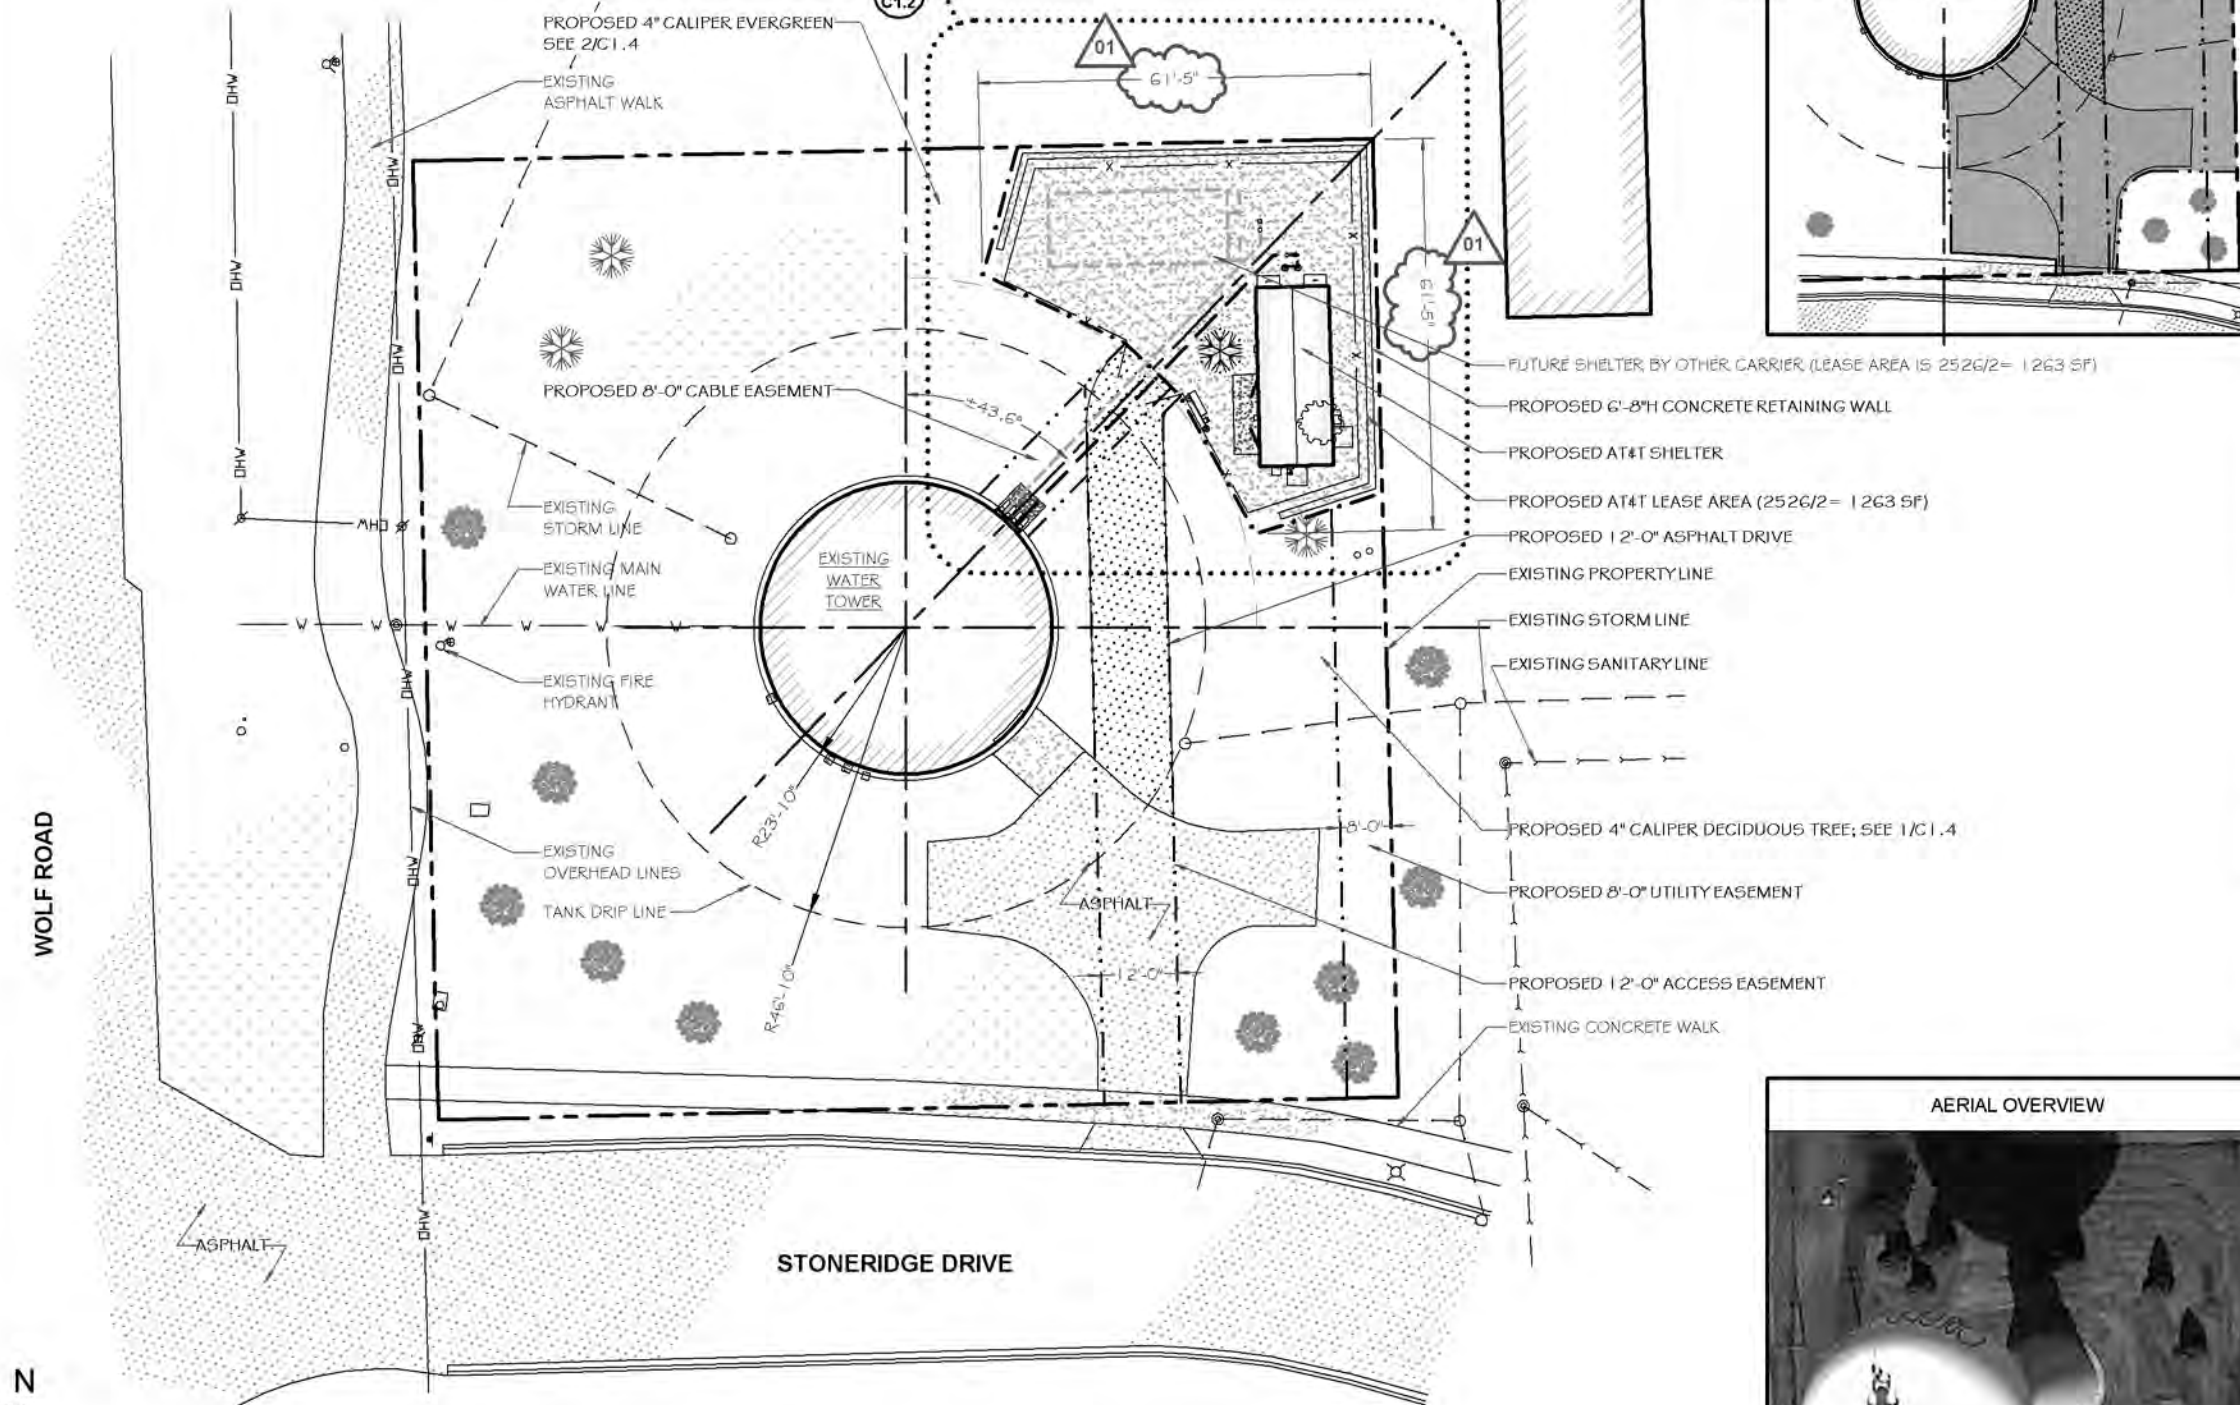

MANHOLE/VALVE VAULT
CATCH BASIN
CURB INLET
VALVE (INDIVIDUAL SERVICE)
FIRE HYDRANT
STREET LIGHT/LIGHT POST
UTILITY/POWER POLE
GUY WIRE/ANCHOR
TELEPHONE PEDESTAL
ELECTRIC METER
GAS METER
TRAFFIC SIGNAL
TRAFFIC SIGNAL BOX
SIGN
MAIL BOX
HANDHOLE
DRAINPIPE
FES (AT END OF PIPE)
CHAIN LINK FENCE
WOOD FENCE
DEPRESSED CURB
CONCRETE CURB & GUTTER
SANITARY SEWER
STORM SEWER
WATER MAIN
OVERHEAD ELECTRIC
UNDERGROUND ELECTRIC
OVERHEAD TELEPHONE
UNDERGROUND TELEPHONE
GAS LINE
CABLE LINE
BUSH/SHRUB
TREE DECIDUOUS
TREE NON-DECIDUOUS
DRAINAGE ARROW
CONTOUR LINE
SPOT ELEVATION
TOP OF FOUNDATION
TOP OF CONCRETE/CAISSON
FINISHED FLOOR
ABOVE GROUND LEVEL
BOUNDARY LINE
CONCRETE
ASPHALT
GRAVEL
BRICK
NEW BUILDING/EQUIPMENT
EXISTING BUILDING
LEASE SITE
ACCESS EASEMENT


SCALE: 1" = 30'-0"



FRONT YARD :	N/A
SIDE YARD :	N/A
REAR YARD :	N/A

NOTE: CONTRACTOR TO VERIFY IN FIELD ALL DIMENSIONS, MATERIALS, AND BUILDING CONDITIONS FOR CONFORMITY TO THESE DRAWINGS BEFORE ORDERING MATERIAL OR FABRICATING ANY ASSEMBLIES

SCALE: 1" = 50'-0"

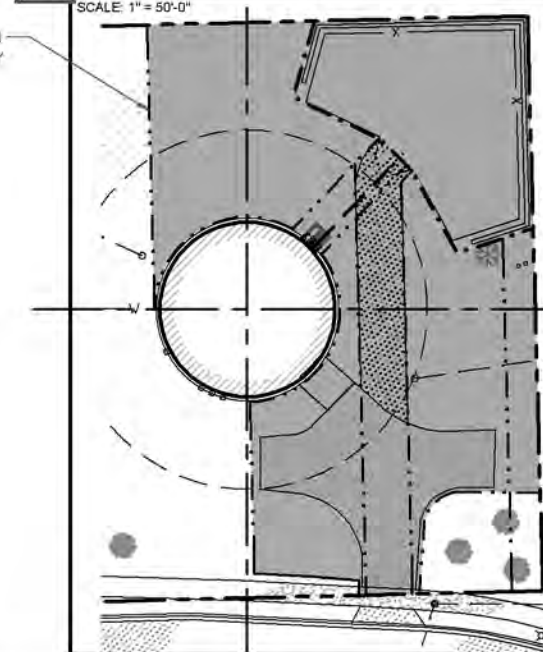

at&t
AT&T WIRELESS, INC.
930 NATIONAL PARKWAY
SCHAUMBURG, IL 60173

MasTec
Network Solutions



forge

FORGE SERVICES, INC.
T: (630) 264-6485
F: (630) 206-0419
2210 MIDWEST RD. STE 213
OAK BROOK, IL 60523

kamry
CONSULTING ENGINEERS

406 MEADOW RIDGE
PROSPECT HEIGHTS, IL 60070

TEL (347) 670-7413
FAX (347) 850-2609

WWW.KAMRYENG.COM

CHECKED BY: FB

REV	DATE	DESCRIPTION
A	7/12/2013	ISSUED FOR V.1 LE
B	7/17/2013	ISSUED FOR V.190 CDS
C	7/29/2013	ISSUED FOR V.290 CDS
D	8/21/2013	ISSUED FOR V.390 CDS
E	9/25/2013	ZONING AND PERMIT
01	11/1/2013	REVISION

CONSTRUCT ONLY FROM DRAWINGS
MARKED "ISSUED FOR CONSTRUCTION"



DATE SIGNED: _____


EXPIRES

© 2013 FORGE SERVICES, INC. ALL RIGHTS RESERVED.

WATER TOWER

SITE PLAN

C1.1

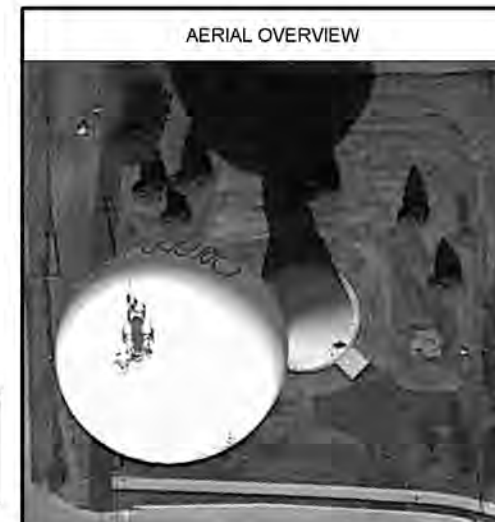


THIS DRAWING IS SCALED FOR 11x17 PAPER (U.S. GOVT. "TABULO")

LEGEND

- | | |
|--|----------------------------|
| | MANHOLE/VALVE VAULT |
| | CATCH BASIN |
| | CURB INLET |
| | VALVE (INDIVIDUAL SERVICE) |
| | FIRE HYDRANT |
| | STREET LIGHT/LIGHT POST |
| | UTILITY/POWER POLE |
| | GUY WIRE/ANCHOR |
| | TELEPHONE PEDESTAL |
| | ELECTRIC METER |
| | GAS METER |
| | TRAFFIC SIGNAL |
| | TRAFFIC SIGNAL BOX |
| | SIGN |
| | MAIL BOX |
| | HANDHOLE |
| | DRAINPIPE |
| | FES (AT END OF PIPE) |
| | CHAIN LINK FENCE |
| | WOOD FENCE |
| | DEPRESSED CURB |
| | CONCRETE CURB & GUTTER |
| | SANITARY SEWER |
| | STORM SEWER |
| | WATER MAIN |
| | OVERHEAD ELECTRIC |
| | UNDERGROUND ELECTRIC |
| | OVERHEAD TELEPHONE |
| | UNDERGROUND TELEPHONE |
| | GAS LINE |
| | CABLE LINE |
| | BUSH/SHRUB |
| | TREE DECIDUOUS |
| | TREE NON-DECIDUOUS |
| | DRAINAGE ARROW |
| | CONTOUR LINE |
| | SPOT ELEVATION |
| | TOP OF FOUNDATION |
| | TOP OF CONCRETE/CAISSON |
| | FINISHED FLOOR |
| | ABOVE GROUND LEVEL |
| | BOUNDARY LINE |
| | CONCRETE |
| | ASPHALT |
| | GRAVEL |
| | BRICK |
| | NEW BUILDING/EQUIPMENT |
| | EXISTING BUILDING |
| | LEASE SITE |
| | ACCESS EASEMENT |

ENLARGED SITE PLAN

SCALE: 1/8" = 1'-0"

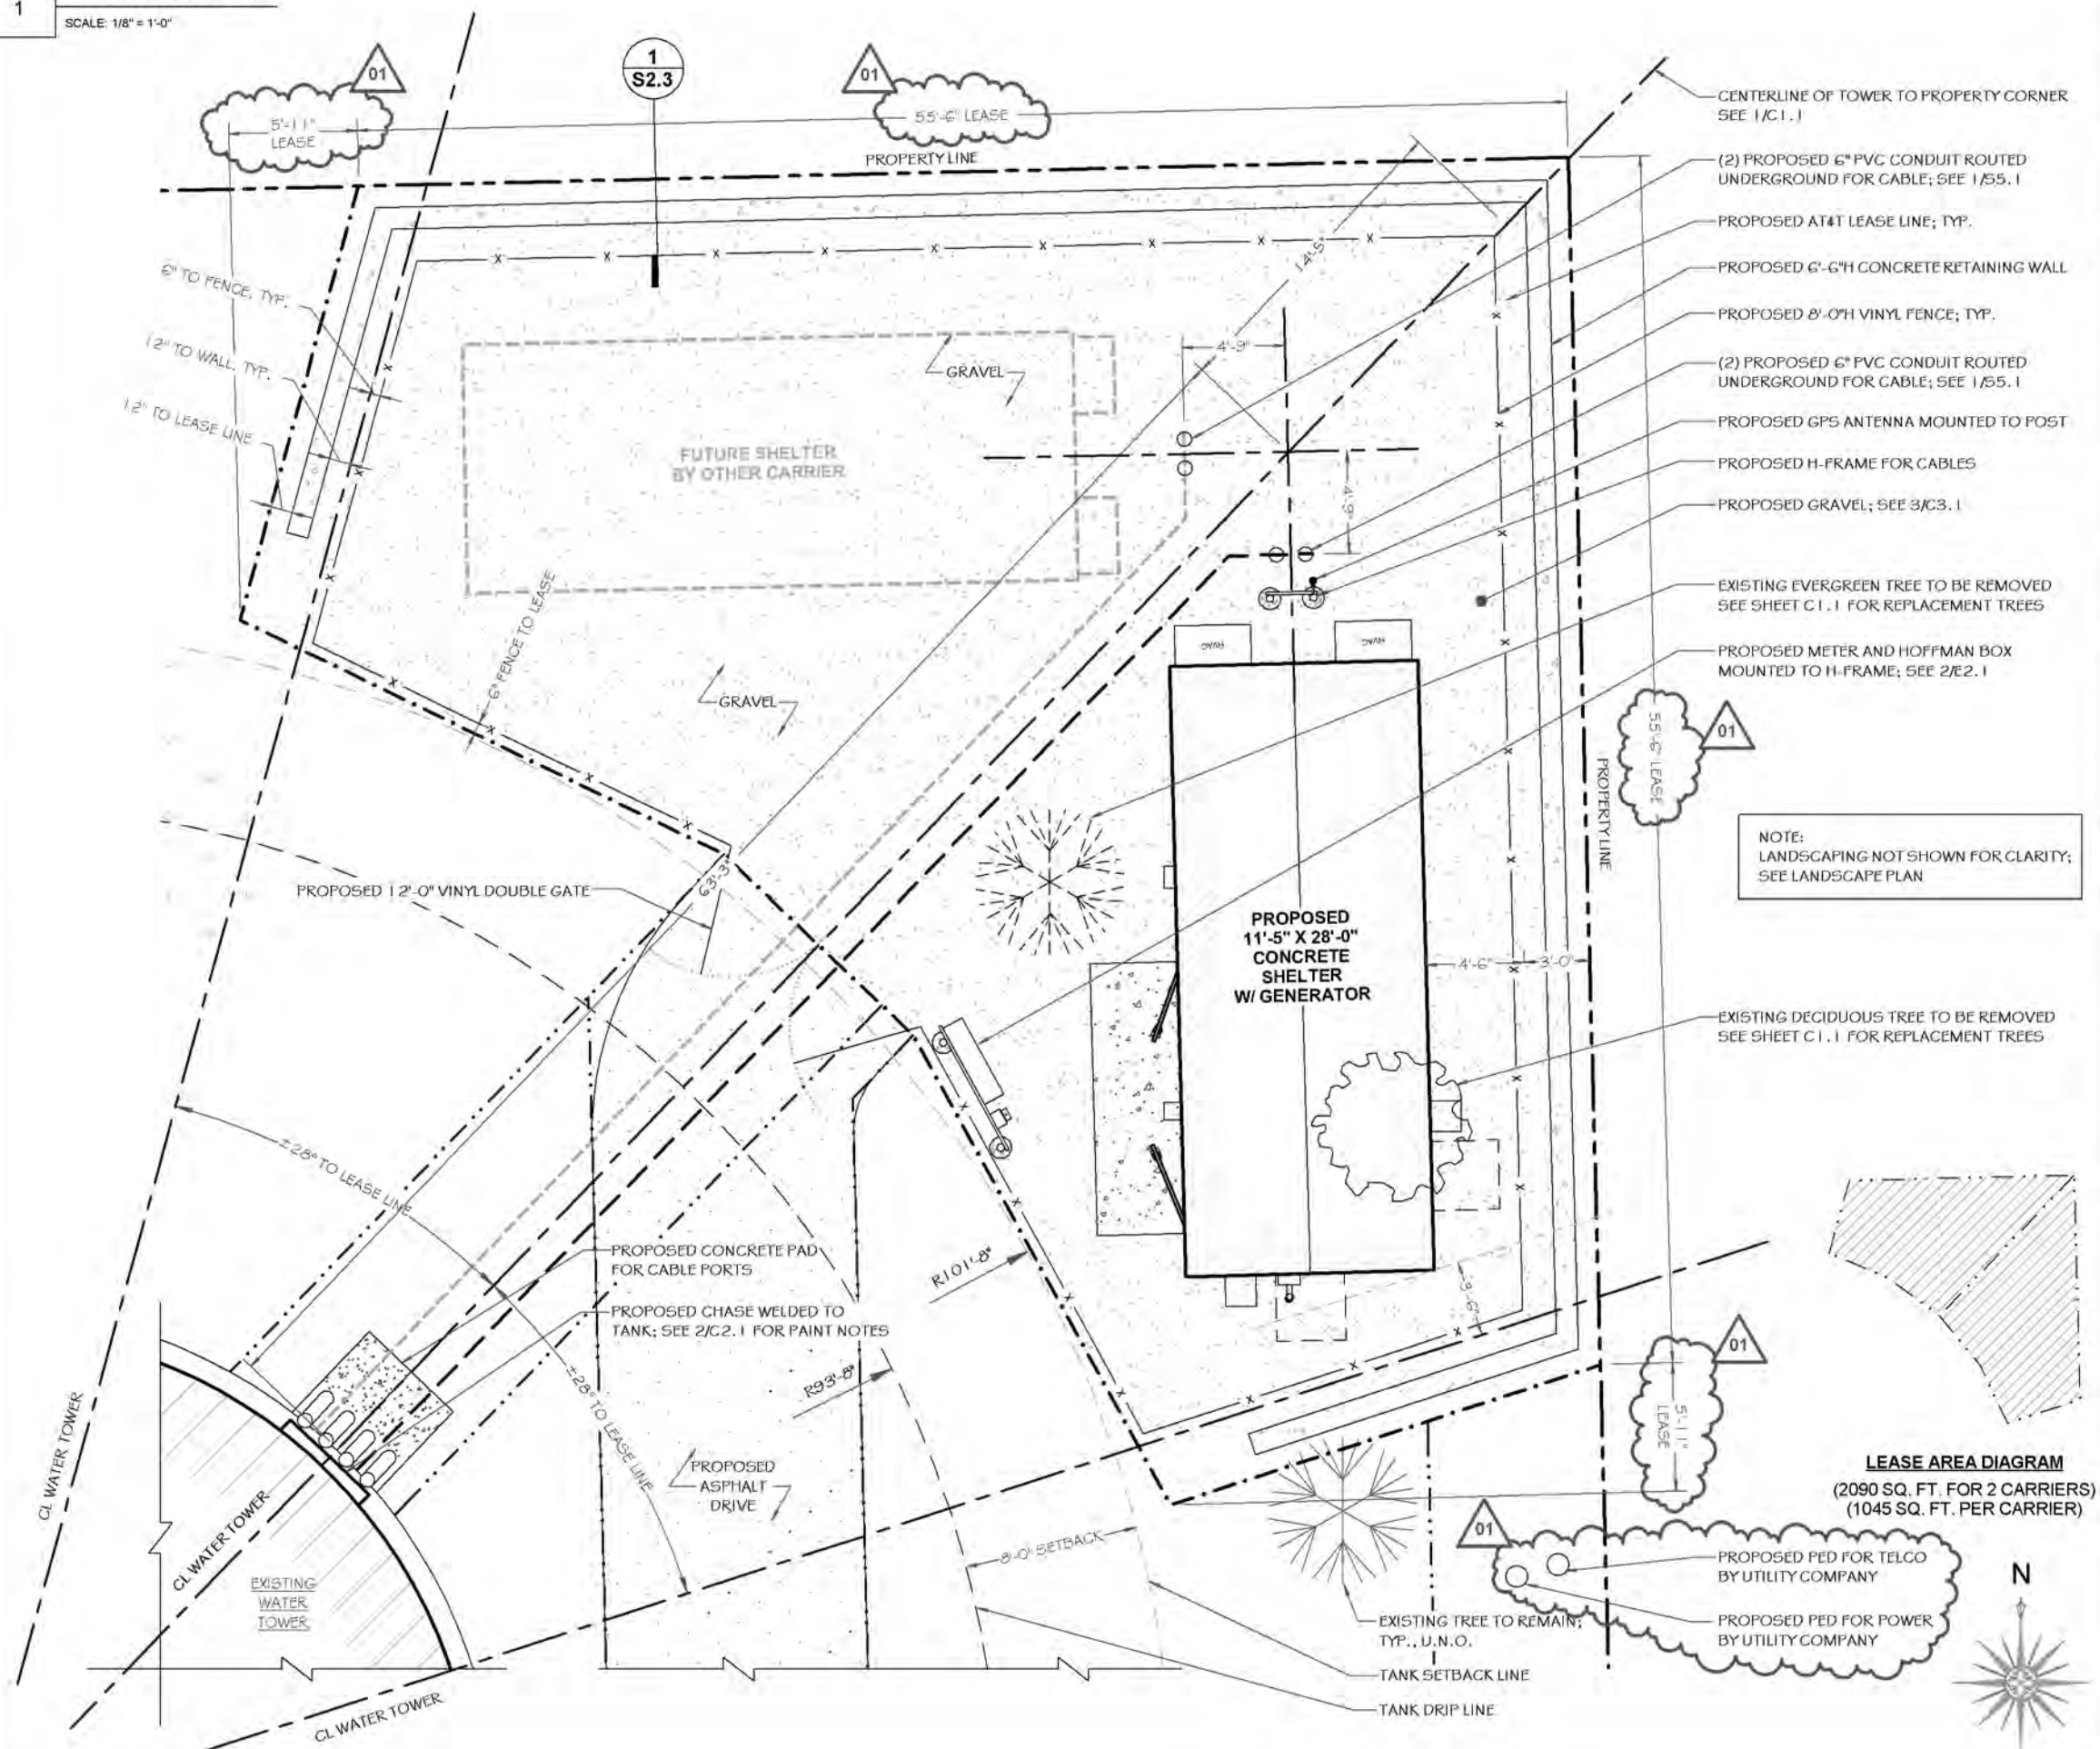

MasTec
Network Solutions



kamry
CONSULTING ENGINEERS

308 MEADOW RIDGE
PROSPECT HEIGHTS, IL 60070

TEL (347) 670-7413
FAX (347) 850-2609

WWW.KAMRYENG.COM

FORGE PROJECT NO: 6263

DRAWN BY: TL

CHECKED BY: FB

REV	DATE	DESCRIPTION
A	7/12/2013	ISSUED FOR V.1 LE
B	7/17/2013	ISSUED FOR V.190 CDS
C	7/29/2013	ISSUED FOR V.290 CDS
D	8/21/2013	ISSUED FOR V.390 CDS
E	9/25/2013	ZONING AND PERMIT
01	11/11/2013	REVISION

CONSTRUCT ONLY FROM DRAWINGS
MARKED "ISSUED FOR CONSTRUCTION"



DATE SIGNED: _____

EXPIRES _____

© 2013 FORGE SERVICES, INC. ALL RIGHTS RESERVED.

IL0683
ORLAND PARK WT

17801 S WOLF RD
ORLAND PARK, IL 60467
WATER TOWER

ENLARGED SITE PLAN

C1.2

THIS DRAWING IS SCALED FOR 11X17 PAPER (U.S. GOVT. "TABLOID")

