

BOARD APPROVED

Case No: 2011 - 0482

Date: 11/19/2012


W/Conditions: X

W/Out Conditions:

VILLAGE OF ORLAND PARK

Date: 11/19/2012

VILLAGE OF ORLAND PARK

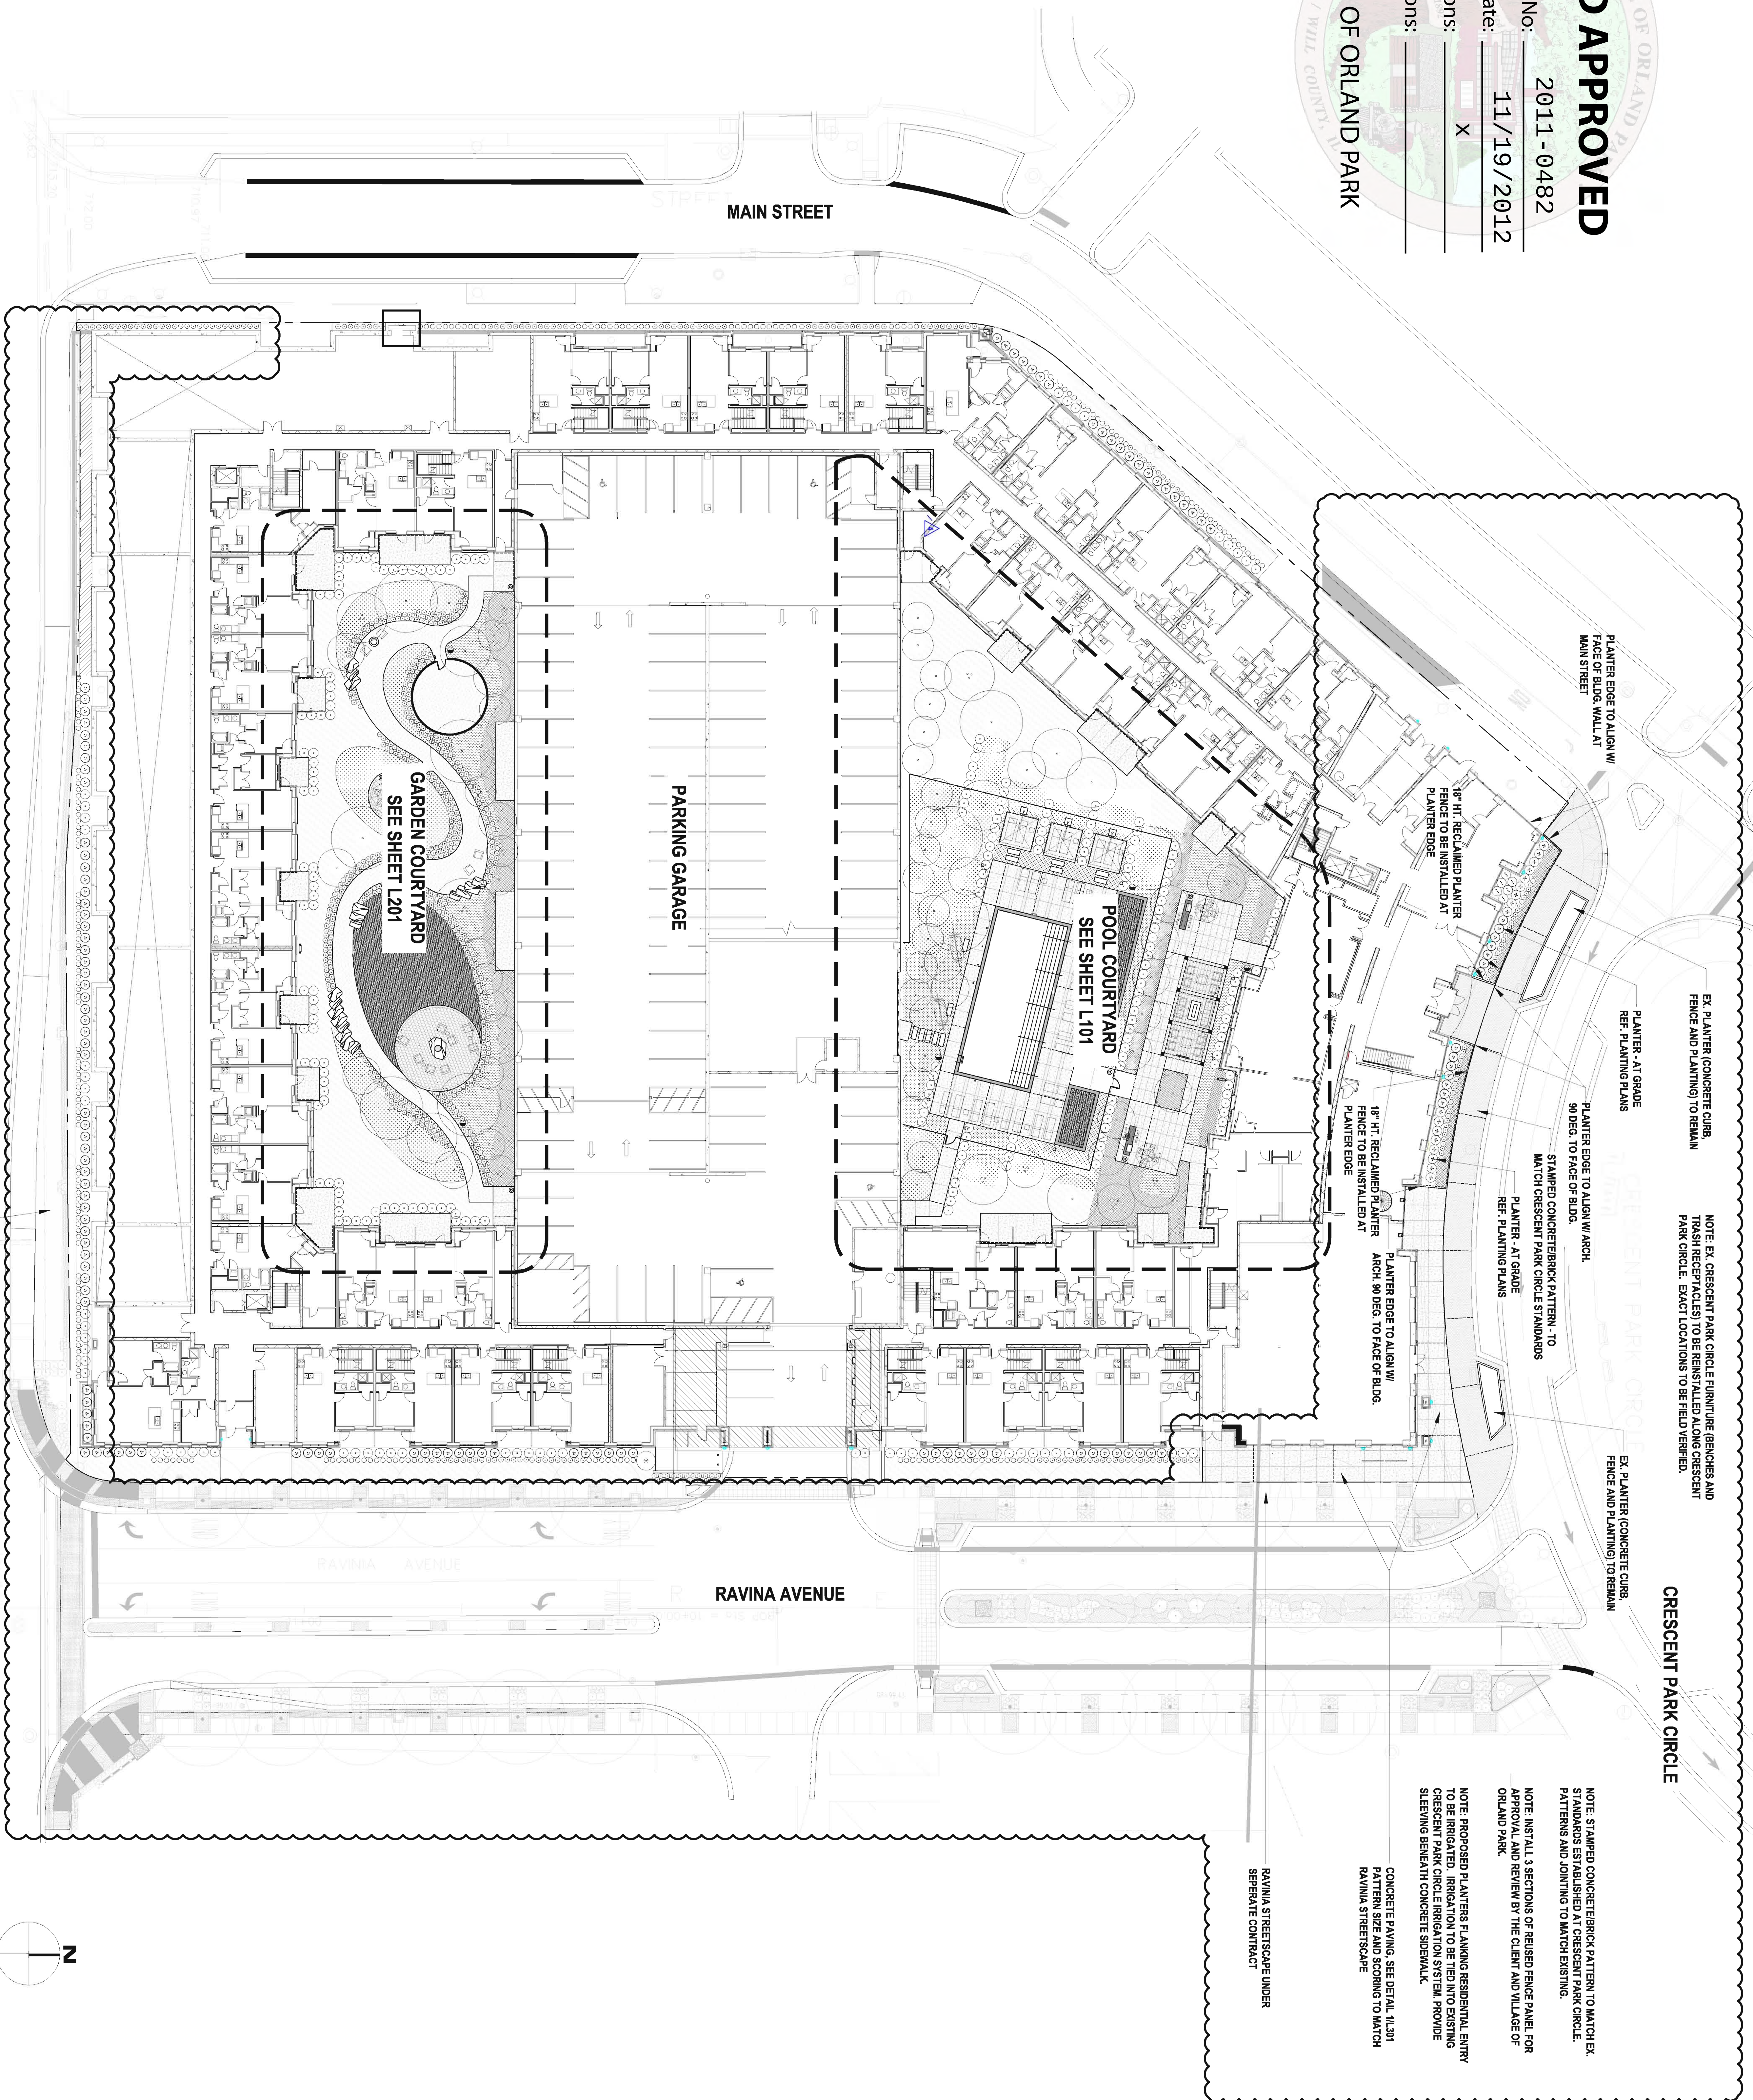

CRESCENT PARK CIRCLE

NOTE: EX. CRESCENT PARK CIRCLE FURNITURE (BENCHES AND TRASH RECEPTACLES) TO BE REINSTALLED ALONG CRESCENT PARK CURB. EVACUATION LOCATIONS TO BE FIELD VERIFIED.

REF. PLANTING PLANS

PLANTER EDGE TO ALIGN W/
FACE OF BLDG. WALL AT
MAIN STREET

TER EDGE TO ALIGN W/ ARCH.

EX. PLANTER (CONCRETE CURB, FENCE AND PLANTING) TO REMAIN

NOTE: STAMPED CONCRETE/BRICK PATTERN TO MATCH EX STANDARDS ESTABLISHED AT CRESCENT PARK CIRCUIT

NOTE: STAMPED CONCRETE/BRICK PATTERN TO MATCH EXISTING STANDARDS ESTABLISHED AT CRESCENT PARK CIRCLE. PATTERNS AND JOINTING TO MATCH EXISTING.

NOTE: INSTALL 3 SECTIONS OF REUSED FENCE PANEL FOR APPROVAL AND REVIEW BY THE CLIENT AND VILLAGE OF ORLAND PARK.

NOTE: PROPOSED PLANTERS FLANKING RESIDENTIAL ENTRY TO BE IRRIGATED. IRRIGATION TO BE TIED INTO EXISTING CRESCENT PARK CIRCLE IRRIGATION SYSTEM. PROVIDE SLEEPING BENEATH CONCRETE SIDEWALK.

CONCRETE PAVING, SEE DETAIL 1/L301
PATTERN SIZE AND SCORING TO MATCH
RAVINIA STREETSCAPE

RAVINIA STREETSCAPE UNDER
SEPERATE CONTRACT

DESIGN COLLECTIVE

ARCHITECTURE, PLANNING, INTERIORS
WWW.DESIGNCOLLECTIVE.COM

601 EAST PRATT STREET, SUITE 300
BALTIMORE, MARYLAND 21202
T: 410.685.6655 F: 410.539.6242

312 BLACKWELL STREET, SUITE 100
DURHAM, NORTH CAROLINA 27701
T: 919.381.9322 F: 919.381.9323

DESIGN COLLECTIVE, INC. ALL RIGHTS RESERVED		DATE
ISSUED FOR		
<u>1. LANDSCAPE REVISIONS</u>		2012.09.10
<u>2. STREETSCAPE/LANDSCAPE REVISIONS</u>		2012.08.17
<u>1. ISSUED FOR PERMIT</u>		2012.04.13
<u>2. LANDSCAPE REVISIONS</u>		2012.04.13
<u>2. STREETSCAPE/LANDSCAPE REVISIONS</u>		2012.04.13
<u>1. ISSUED FOR PERMIT</u>		2012.04.13
<u>2. LANDSCAPE REVISIONS</u>		2012.04.13
<u>2. STREETSCAPE/LANDSCAPE REVISIONS</u>		2012.04.13
<u>1. ISSUED FOR PERMIT</u>		2012.04.13
<u>2. LANDSCAPE REVISIONS</u>		2012.04.13
<u>2. STREETSCAPE/LANDSCAPE REVISIONS</u>		2012.04.13
<u>1. ISSUED FOR PERMIT</u>		2012.04.13

OWNER / DEVELOPER
METRA TRIANGLE FC,
LLC.

**8900 KEYSTONE CROSSING
SUITE 200
INDIANAPOLIS, INDIANA 46240
PROJECT NAME
9750 ON THE PARK**

PROJECT ADDRESS
DOWNTOWN ORLAND PARK,
ILLINOIS

PROJECT MANAGEMENT
DCI Project No. 678-11
Owner Project No. ----
Drawn by AG Checked by BR

SEAL



SHEET TITLE
OVERALL PLAN

SCALE
1" = 20'-0"

100

BOARD APPROVED

Case No: 2011 -0482

Date: 11/19/2012

W/Conditions: X

W/Out Conditions:

VILLAGE OF ORLAND PARK



MASTER MATERIALS LEGEND

1	1	CONCRETE PAVING - TYPE A COLOR: STANDARD GREY FINISH: LIGHT BROOM
2	1	CONCRETE PAVING - TYPE B STANDARD GREY FINISH: MEDIUM SANDBLAST
3	6	DISCOMPOSED GRANITE WITH STABILIZER COLOR: CHALKY (AGGREGATE) SIZE: SMALL 1/2"
4	5	CONCRETE LINE PAVING STYLE: ASPHALT COLOR: 80% SOUTH MOUNTAIN SAND BLEND FINISH: CHISELED SIZE: 3/8" X3' (BOTH COLORS)
5A	4	GRILL STATION - TYPE A - TYPICAL 12' X 7' GRILL STATION - TYPE B SAFETY TIERS BUILT INTO SIDE OF GRILL STATION PROVIDE LOCATION FOR OUTDOOR IMPROVISE PROVIDED BY OWNER
5B	1	GRILL STATION - TYPE B STAINLESS STEEL GAS GRILL IN GROUND MOUNTED ADJACENT TO GRILL STATION SAFETY TIERS BUILT INTO SIDE OF GRILL STATION
6A	1	FIRE PIT - TYPE A SUPPLIER: CHARLES LUCK STONE SEE L101 FOR TIER 1 EMERGENCY SHUT OFF LOCATION
6B	1	FIRE PIT - TYPE B STONE LAMIN WEATHERED OUTCROPPING QUARRY: MALCOLM SEE L101 FOR TIER 1 EMERGENCY SHUT OFF LOCATION
7A	2	POOL GATE - 48" HT - TYPICAL 12' X 7' SELF-CLIMBING FLATTING LOCKABLE POWERCOATED TUBULAR STEEL GATE TO MATCH POOL FENCE AND MEET LOCAL POOL CODES COLOR: 10% BY LANDSCAPE ARCHITECT
7B	5	DOG WALK GATE - 36" HT SELF-CLIMBING FLATTING LOCKABLE POWERCOATED TUBULAR STEEL GATE COLOR: 10% BY LANDSCAPE ARCHITECT
8A	1	POOL FENCE - 48" HT STONE LAMIN WEATHERED OUTCROPPING QUARRY: MALCOLM SEE L101 FOR TIER 1 EMERGENCY SHUT OFF LOCATION
8B	3	POWERCOATED TUBULAR STEEL FENCE ON 4" FT CONCRETE CUBES COLOR: 10% BY LANDSCAPE ARCHITECT
9	4	CONCRETE CURB - 4" HT X 12" W STANDARD GREY CONCRETE
10	1	TRELLIS MANUFACTURED BY WALPOLE (OR EQUAL) WITH REPLACEABLE SUBMERGIBLE CANVAS SHADE CANOPY (EXCEPT AT FIRE PIT) COLOR: WHITE (TO BE APPROVED BY LANDSCAPE ARCHITECT)
11	7	2X4 STEPPING STONE - TYPICAL OF 8 STONE LAMIN WEATHERED OUTCROPPING QUARRY: MALCOLM THICKNESS: 2" TYPICAL
12	2	BOULDER OUTCROPPING (GROUPINGS OF 4 AND 8 BOULDERS) SUPPLIER: CHARLES LUCK STONE BOULDER SELECTIONS TO BE APPROVED BY LANDSCAPE ARCHITECT
13	2	WATER FEATURE - TYPICAL OF 2 SUPPLIER: CHARLES LUCK STONE QUANTITY: MALCOLM SYSTEM BY AQUADUX FOUNTAIN KIT
14	2	DOG WASTE BAG STATION PROVIDE DISPENSER GREEN MOUNTED ON 3/8" BLACK METAL POST
15	2	POOL COVERS COLOR: CREAM STYLE: FRODOE SEE L101 OUTDOOR TELEVISION - PROVIDED BY OWNER
16	2	NOTE: A POOL COVER THESE COVERS ARE TO BE USED FOR POOL WINTERS USE MANUFACTURER: METRO POOL COVERS OR APPROVED EQUAL TYPE: PERMAQUAD ANCHOR: GREEN TYPE ANCHOR WITH OPTIONAL DECK FLANGE LOCATE ANCHORS PER MANUFACTURERS RECOMMENDATIONS. NOTE: A GAS CANTER 200 200 X 200 X 200 INCHES SET 1' ABOVE GRADE MOUNT BOX TO 21/2" DIA. SONOTUBE FOOTINGS 30" O.C.

DESIGN COLLECTIVE

ARCHITECTURE, PLANNING, INTERIORS
WWW.DESIGNCOLLECTIVE.COM

601 EAST PRATT STREET, SUITE 300
BALTIMORE, MARYLAND 21202
T: 410.685.6655 F: 410.539.6242

312 BLACKWELL STREET, SUITE 100
DURHAM, NORTH CAROLINA 27701
T: 919.381.9322 F: 919.381.9323



POOL COURTYARD
MATERIALS PLAN

101

BOARD APPROVED

Case No: 2011 -0482

Date: 11/19/2012

W/Conditions: X

W/Out Conditions:

VILLAGE OF ORLAND PARK



SITE FURNITURE LEGEND - POOL COURTYARD

- F1 SOFA, QTY: 1
MANUFACTURER: RESTORATION HARDWARE
STYLE: BISCAYNE SOFA
CUSHION: SUNBELLA
CUSHION COLOR: LIME
- F2 MANUFACTURER: RESTORATION HARDWARE
LOUNGE CHAIR, QTY: 10
CUSHION: SUNBELLA
CUSHION COLOR: LIME
- F3 SIDE TABLE, QTY: 2
MANUFACTURER: RESTORATION HARDWARE
STYLE: LAKESIDE SIDE TABLE
COLOR: TOBACCO
- F4 CORNER TABLE, QTY: 2
MANUFACTURER: RESTORATION HARDWARE
STYLE: LAKESIDE CORNER TABLE
COLOR: TOBACCO
- F5 CHAIR, QTY: 14
SUPPLIER: TROTONE
STYLE: BLANK CHAIR WITH WINGS
CUSHION: SUNBELLA (FAB)
FABRIC: 1153 CORNICE
- F6 SIDE TABLE, TYPE B, QTY: 12
SUPPLIER: TROTONE
STYLE: BLANK CHAIR WITH WINGS
CUSHION: SUNBELLA (FAB)
FABRIC: 1153 CORNICE
- F7 SUPPLIER: TREE MOUNT HANMOCK - BIG ARCH STAND
COLOR: ALUMINUM METALIC (ALU)
- F8 DINING TABLE, QTY: 2
MANUFACTURER: LANDSCAPE FORMS
STYLE: 42" DIA DINING TABLE WITH UMBRELLA HOLE
CUSHION: SUNBELLA (FAB)
CUSHION COLOR: SMOOTH FINISH
COLOR: STONE/CLOD
- F9 DINING CHAIR, QTY: 8
MANUFACTURER: LANDSCAPE FORMS
STYLE: CATHAN ALUMINUM DINING CHAIR
- F10 DINING TABLE UMBRELLA, QTY: 2
MANUFACTURER: LANDSCAPE FORMS
STYLE: CATHAN ALUMINUM DINING CHAIR
COLOR: CINQUE
- F11 TRASH CAN, QTY: 3
SUPPLIER: TEACH CO. BUSINESS PRODUCTS
RECYCLABLE: CHARCOAL - PHILMERSCH
- F12 SHADE UMBRELLA, QTY: 3
SUPPLIER: WWJ FAYTON UMBRELLAS.COM (FOR EQUAL)
CUSHION: SUNBELLA (FAB)
CUSHION COLOR: BLACK
- F13 OUTDOOR BAR STOOL, QTY: 8
SUPPLIER: TBD
- F14 OUTDOOR TELEVISION
SUPPLIER: SUNSHINE
MODEL: 50" 1080P
COLOR: BLACK

DESIGN COLLECTIVE

ARCHITECTURE, PLANNING, INTERIORS
WWW.DESIGNCOLLECTIVE.COM

601 EAST PRATT STREET, SUITE 300
BALTIMORE, MARYLAND 21202
T: 410.685.6655 F: 410.539.6242

312 BLACKWELL STREET, SUITE 100
DURHAM, NORTH CAROLINA 27701
T: 919.381.9322 F: 919.381.9323

DESIGN COLLECTIVE, INC. ALL RIGHTS RESERVED
ISSUED FOR PERMIT
DATE
2012.09.10
2. LANDSCAPE REVISIONS
2012.04.13

OWNER/DEVELOPER
METRA TRIANGLE FC,
LLC.

8900 KEYSTONE CROSSING
SUITE 200
INDIANAPOLIS, INDIANA 46240
PROJECT NAME
9750 ON THE PARK

PROJECT ADDRESS
DOWNTOWN ORLAND PARK,
ILLINOIS
PROJECT MANAGEMENT
DCI Project No. 678-11
Owner Project No. 678-11
Drawn by AG Checked by BR
SEAL



SHEET TITLE
POOL COURTYARD
FURNITURE PLAN

SCALE
1/8" = 1'-0"

SHEET NUMBER

L102

BOARD APPROVED


Case No: 2011-0482

Date: 11/19/2012

W/Conditions: X

W/Out Conditions:


VILLAGE OF ORLAND PARK

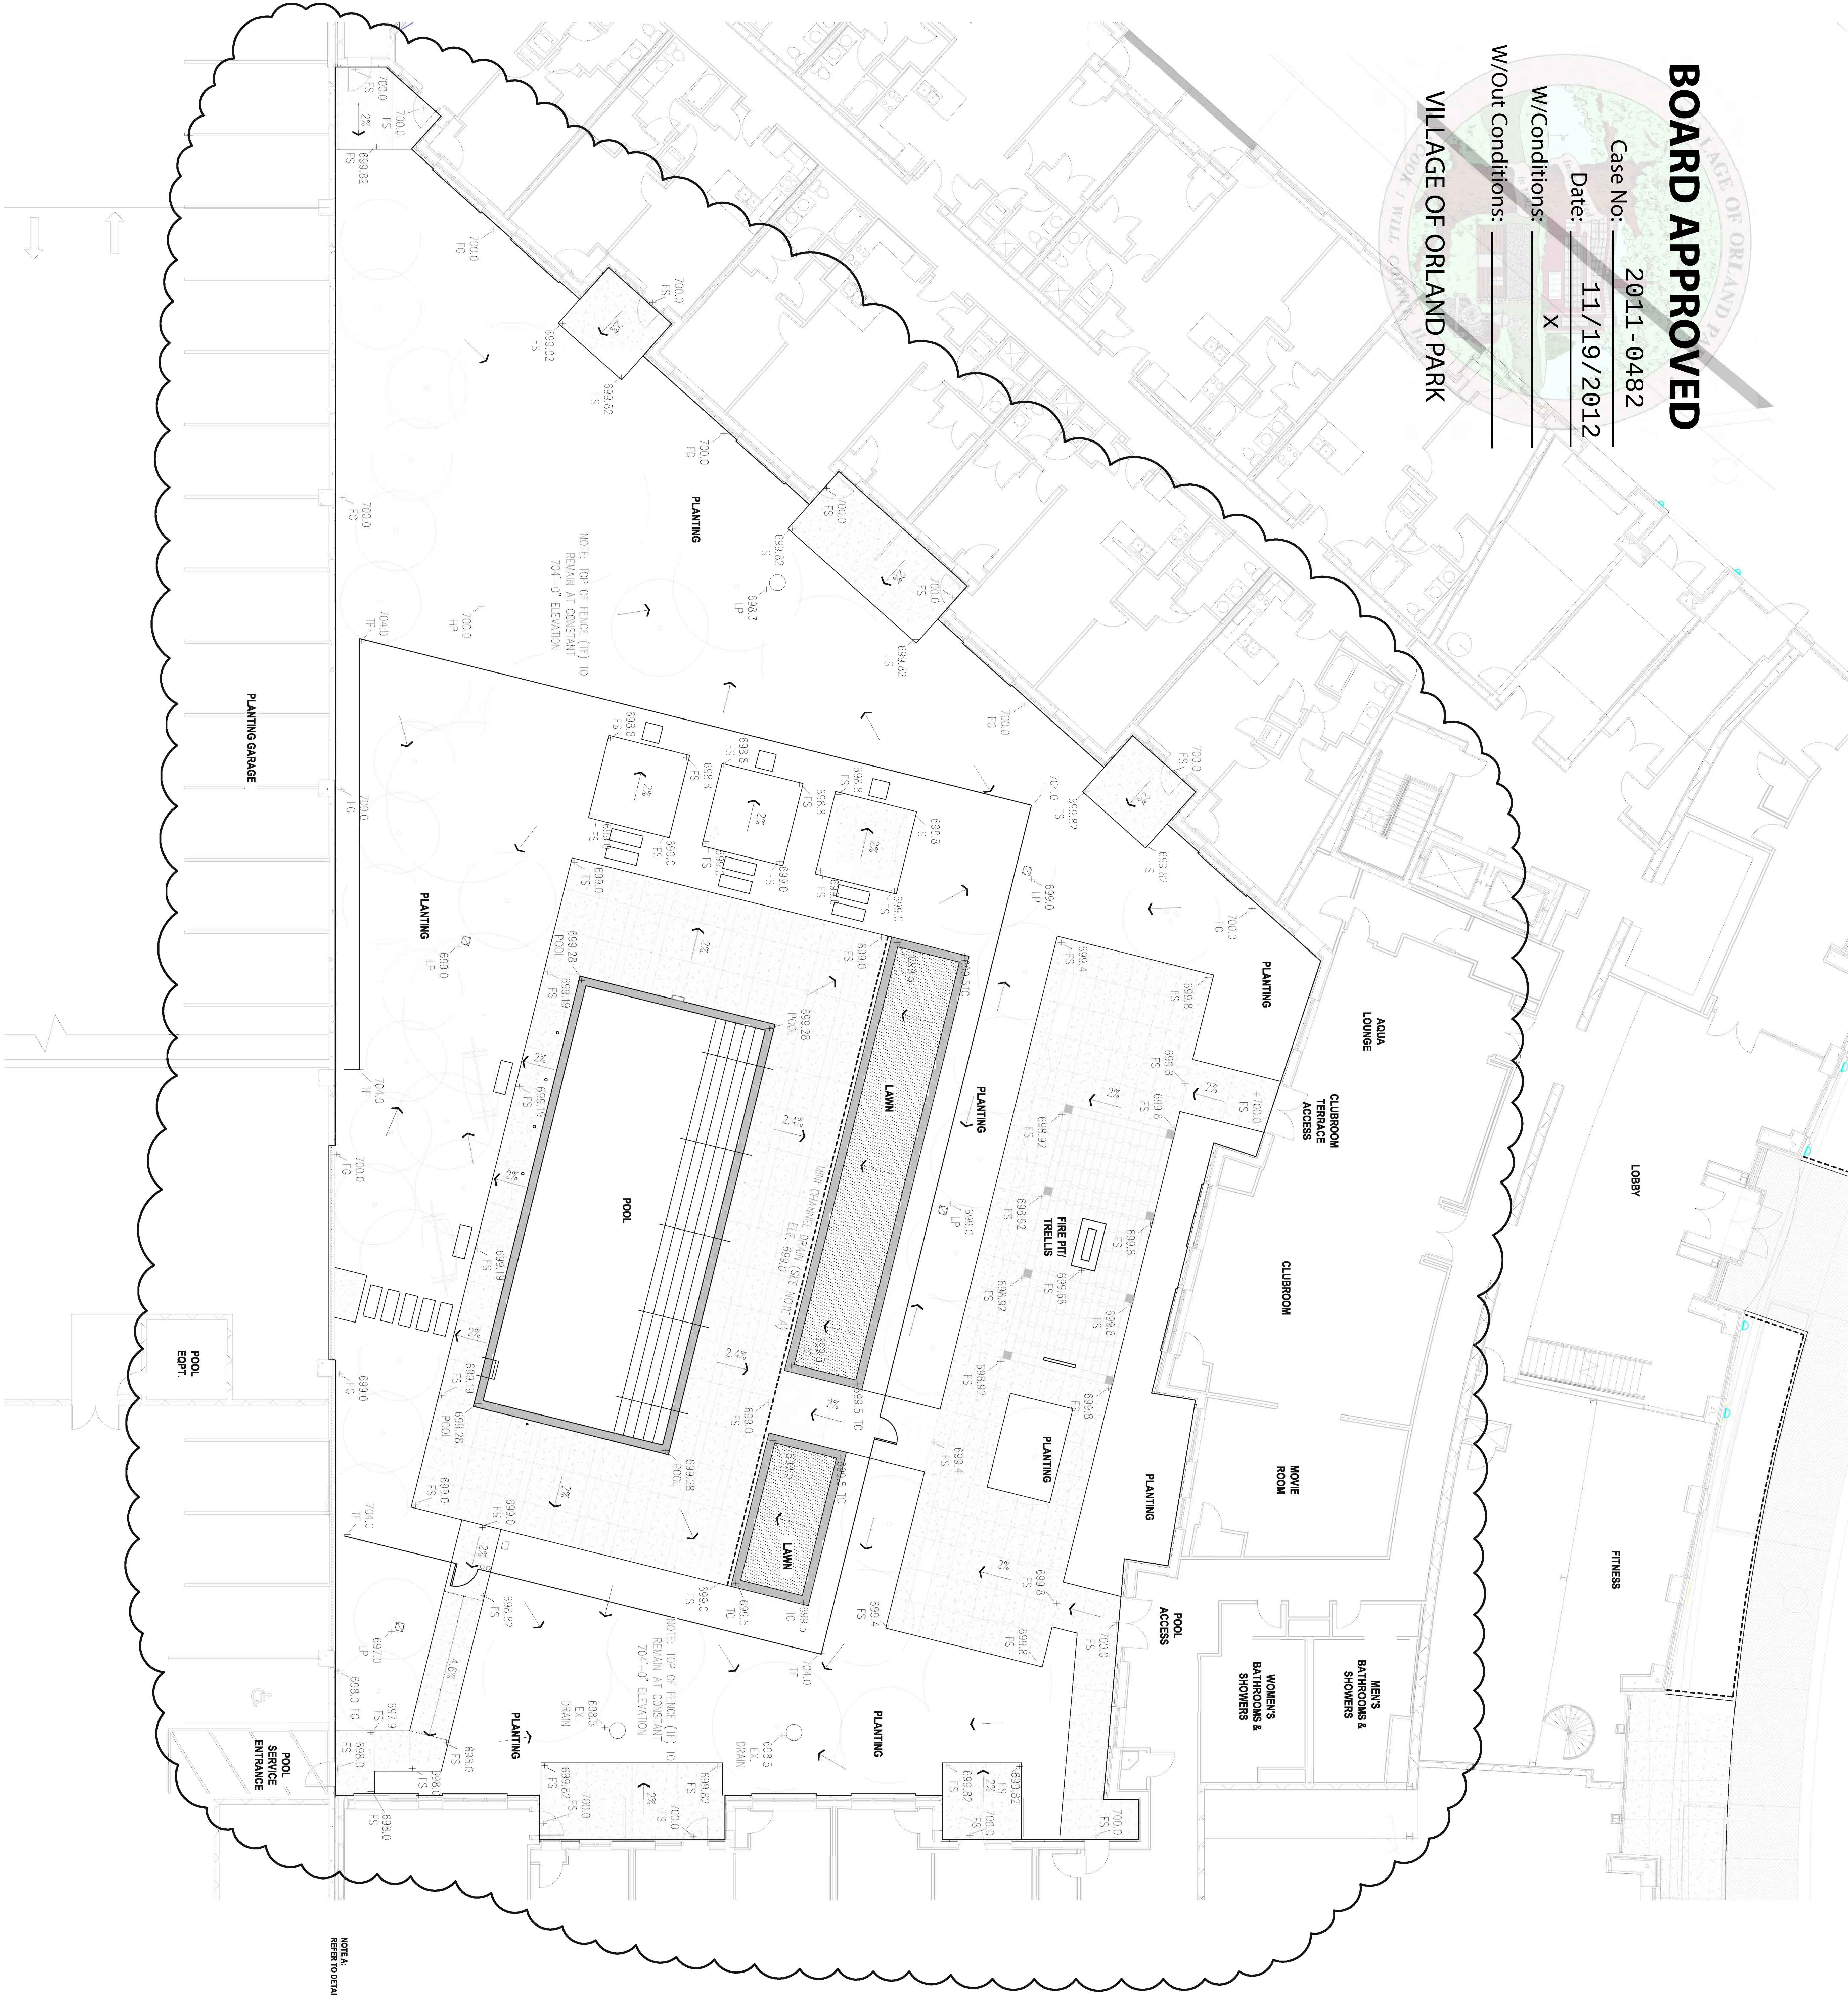

LEGEND - ABBREVIATIONS

TC	TOP OF CURB
TF	TOP OF FENCE
FS	FINISH SURFACE
FG	FINISH GRADE
LP	LOW POINT (DRAIN)

NOTE A:
NOT SET TO DETAIL. ADAPT FOR MIN. CHANNEL DRAIN SYSTEM

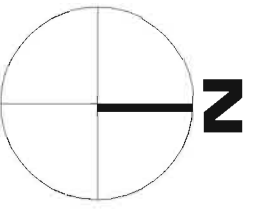

DESIGN COLLECTIVE

ARCHITECTURE, PLANNING, INTERIORS
WWW.DESIGNCOLLECTIVE.COM

601 EAST PRATT STREET, SUITE 300
BALTIMORE, MARYLAND 21202
T: 410.685.6655 F: 410.539.6242

312 BLACKWELL STREET, SUITE 100
DURHAM, NORTH CAROLINA 27701
T: 919.381.9322 F: 919.381.9323

ISSUED FOR PERMIT

NO.	DATE	DESCRIPTION
1.	2012.09.10	LANDSCAPE REVISIONS
2.	2012.04.13	ISSUED FOR PERMIT

OWNER / DEVELOPER
METRA TRIANGLE FC,
LLC.

8900 KESTONE CROSSING
SUITE 200
INDIANAPOLIS, INDIANA 46240
PROJECT NAME
9750 ON THE PARK

PROJECT ADDRESS
DOWNTOWN ORLAND PARK,
ILLINOIS

PROJECT MANAGEMENT
DCI Project No. 678-11
Owner Project No. ---
Drawn by AG Checked by BR
SCALE



SHEET TITLE
POOL COURTYARD
GRADING PLAN

SCALE
1/8" = 1'-0"

SHEET NUMBER

L103

BOARD APPROVED

Case No: 2011 - 0482

Date: 11/19/2012

W/Conditions: X

W/Out Conditions:

VILLAGE OF ORLAND PARK



DESIGN COLLECTIVE

ARCHITECTURE, PLANNING, INTERIORS
WWW.DESIGNCOLLECTIVE.COM

601 EAST PRATT STREET, SUITE 300
BALTIMORE, MARYLAND 21202
T: 410.685.6655 F: 410.539.6242

312 BLACKWELL STREET, SUITE 100
DURHAM, NORTH CAROLINA 27701
T: 919.381.9322 F: 919.381.9323

DESIGN COLLECTIVE, INC. ALL RIGHTS RESERVED	
ISSUED FOR	DATE
1. LANDSCAPE REVISIONS	2012.09.10
2. ISSUED FOR PERMIT	2012.04.13
3. ISSUED FOR PERMIT	2012.04.13
4. ISSUED FOR PERMIT	2012.04.13
100. ISSUED FOR PERMIT	2012.04.13

OWNER / DEVELOPER
METRA TRIANGLE FC,
LLC.

8900 KEYSTONE CROSSING
SUITE 200
INDIANAPOLIS, INDIANA 46240
PROJECT NAME
9750 ON THE PARK

PROJECT ADDRESS
DOWNTOWN ORLAND PARK,
ILLINOIS

PROJECT MANAGEMENT
DCI Project No. 678-11
Owner Project No. 678-11
Drawn by AG Checked by BR
SEAL



SHEET TITLE
POOL COURTYARD
LAYOUT PLAN

SCALE
1/8" = 1'-0"

SHEET NUMBER

L104

BOARD APPROVED


Case No: 2011 -0482

Date: 11/19/2012

W/Conditions: X

W/Out Conditions:

VILLAGE OF ORLAND PARK

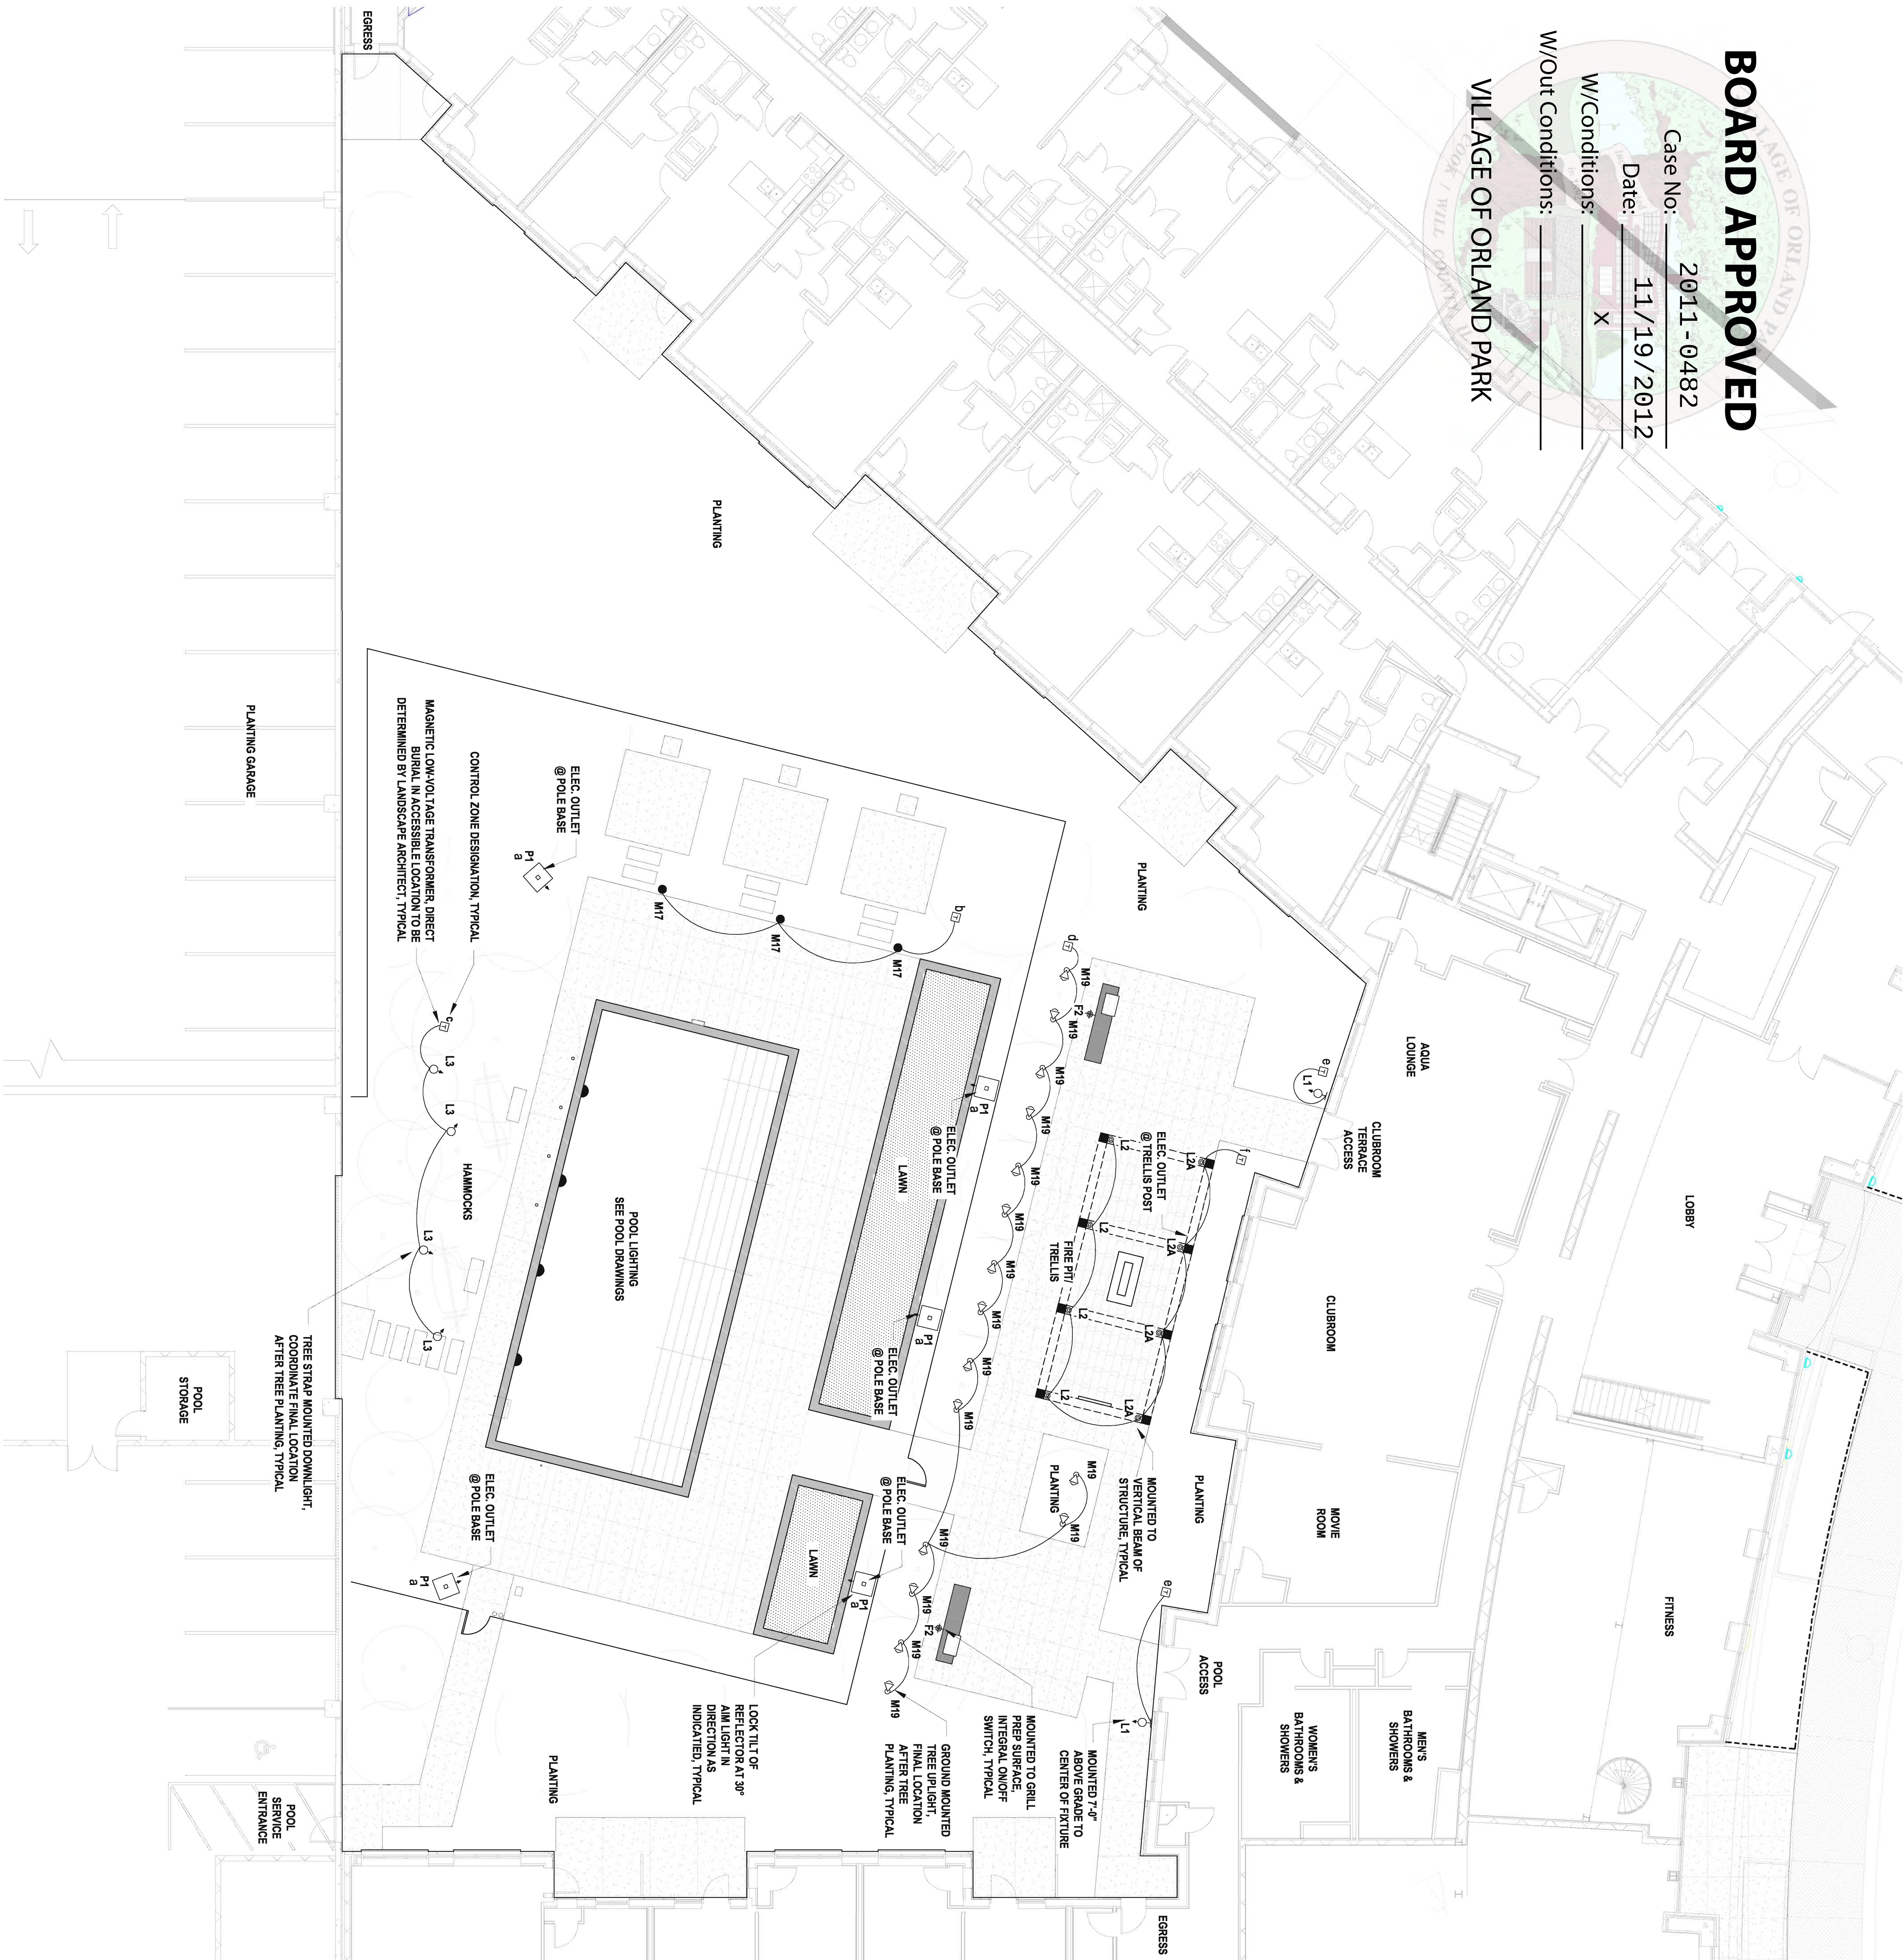

LIGHTING LEGEND

Qty.	Key	Fixture
2	F2	BARRELE LIGHT BO-08 SERIES FOCUS INDUSTRIES
2	L1	SL-16-D-4R16 WALL MOUNT FOCUS INDUSTRIES
4	L2	SL-16-D-4R16 WALL MOUNT FOCUS INDUSTRIES
4	L2A	SL-16-D-4R16 FOCUS INDUSTRIES
4	L3	PRO-02 SERIES DIRECTIONAL LIGHTS FOCUS INDUSTRIES
3	M17	AL-08-SM SERIES AREA LIGHT FOCUS INDUSTRIES
16	M19	PRO-02 SERIES DIRECTIONAL LIGHTS FOCUS INDUSTRIES
5	P1	INDIRECT INDOOR 5" SQUARE STEEL POLE ARCHITECTURAL AREA LIGHTING
8	P4	DIRECT BURIAL TRANSFORMER 08 SERIES FOCUS INDUSTRIES

NOTE:
- REFER TO LIGHTING SPECIFICATION OUTSHEETS FOR FIXTURE TYPES, ETC.
- REFER TO POOL DRAWINGS FOR POOL LIGHTS
- DIMMER SWITCHES FOR ZONES "A" THROUGH "I" TO BE LOCATED PER ARCHITECTURE DRAWINGS
- ALL LIGHTING TO BE TIME-LOCK CONTROL ONLY

DESIGN COLLECTIVE

ARCHITECTURE, PLANNING, INTERIORS
WWW.DESIGNCOLLECTIVE.COM


601 EAST PRATT STREET, SUITE 300
BALTIMORE, MARYLAND 21202
T: 410.685.6655 F: 410.539.6242

312 BLACKWELL STREET, SUITE 100
DURHAM, NORTH CAROLINA 27701
T: 919.381.9322 F: 919.381.9323

DESIGN COLLECTIVE, INC. ALL RIGHTS RESERVED	DATE
ISSUED FOR PERMIT	2012.09.10
1. LANDSCAPE REVISIONS	2012.04.13
2. ISSUED FOR PERMIT	2012.04.13
3. ISSUED FOR PERMIT	2012.04.13
4. ISSUED FOR PERMIT	2012.04.13
100. ISSUED FOR PERMIT	2012.04.13

OWNER/DEVELOPER
METRA TRIANGLE FC,
LLC.
8900 KEYSTONE CROSSING
SUITE 200
INDIANAPOLIS, INDIANA 46240
PROJECT NAME
9750 ON THE PARK

PROJECT ADDRESS
DOWNTOWN ORLAND PARK,
ILLINOIS
PROJECT MANAGEMENT
DCI Project No. 678-11
Owner Project No. 678-11
Drawn by AG Checked by BR
SEAL

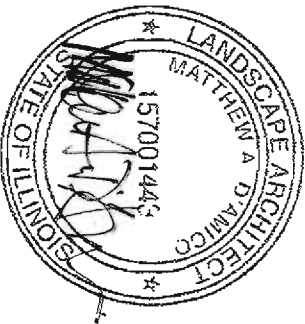

SHEET TITLE
POOL COURTYARD
LIGHTING PLAN

SCALE
1/8" = 1'-0"

SHEET NUMBER

L105

BOARD APPROVED


Case No: 2011 - 0482

Date: 11/19/2012

W/Conditions: X

W/Out Conditions:

VILLAGE OF ORLAND PARK

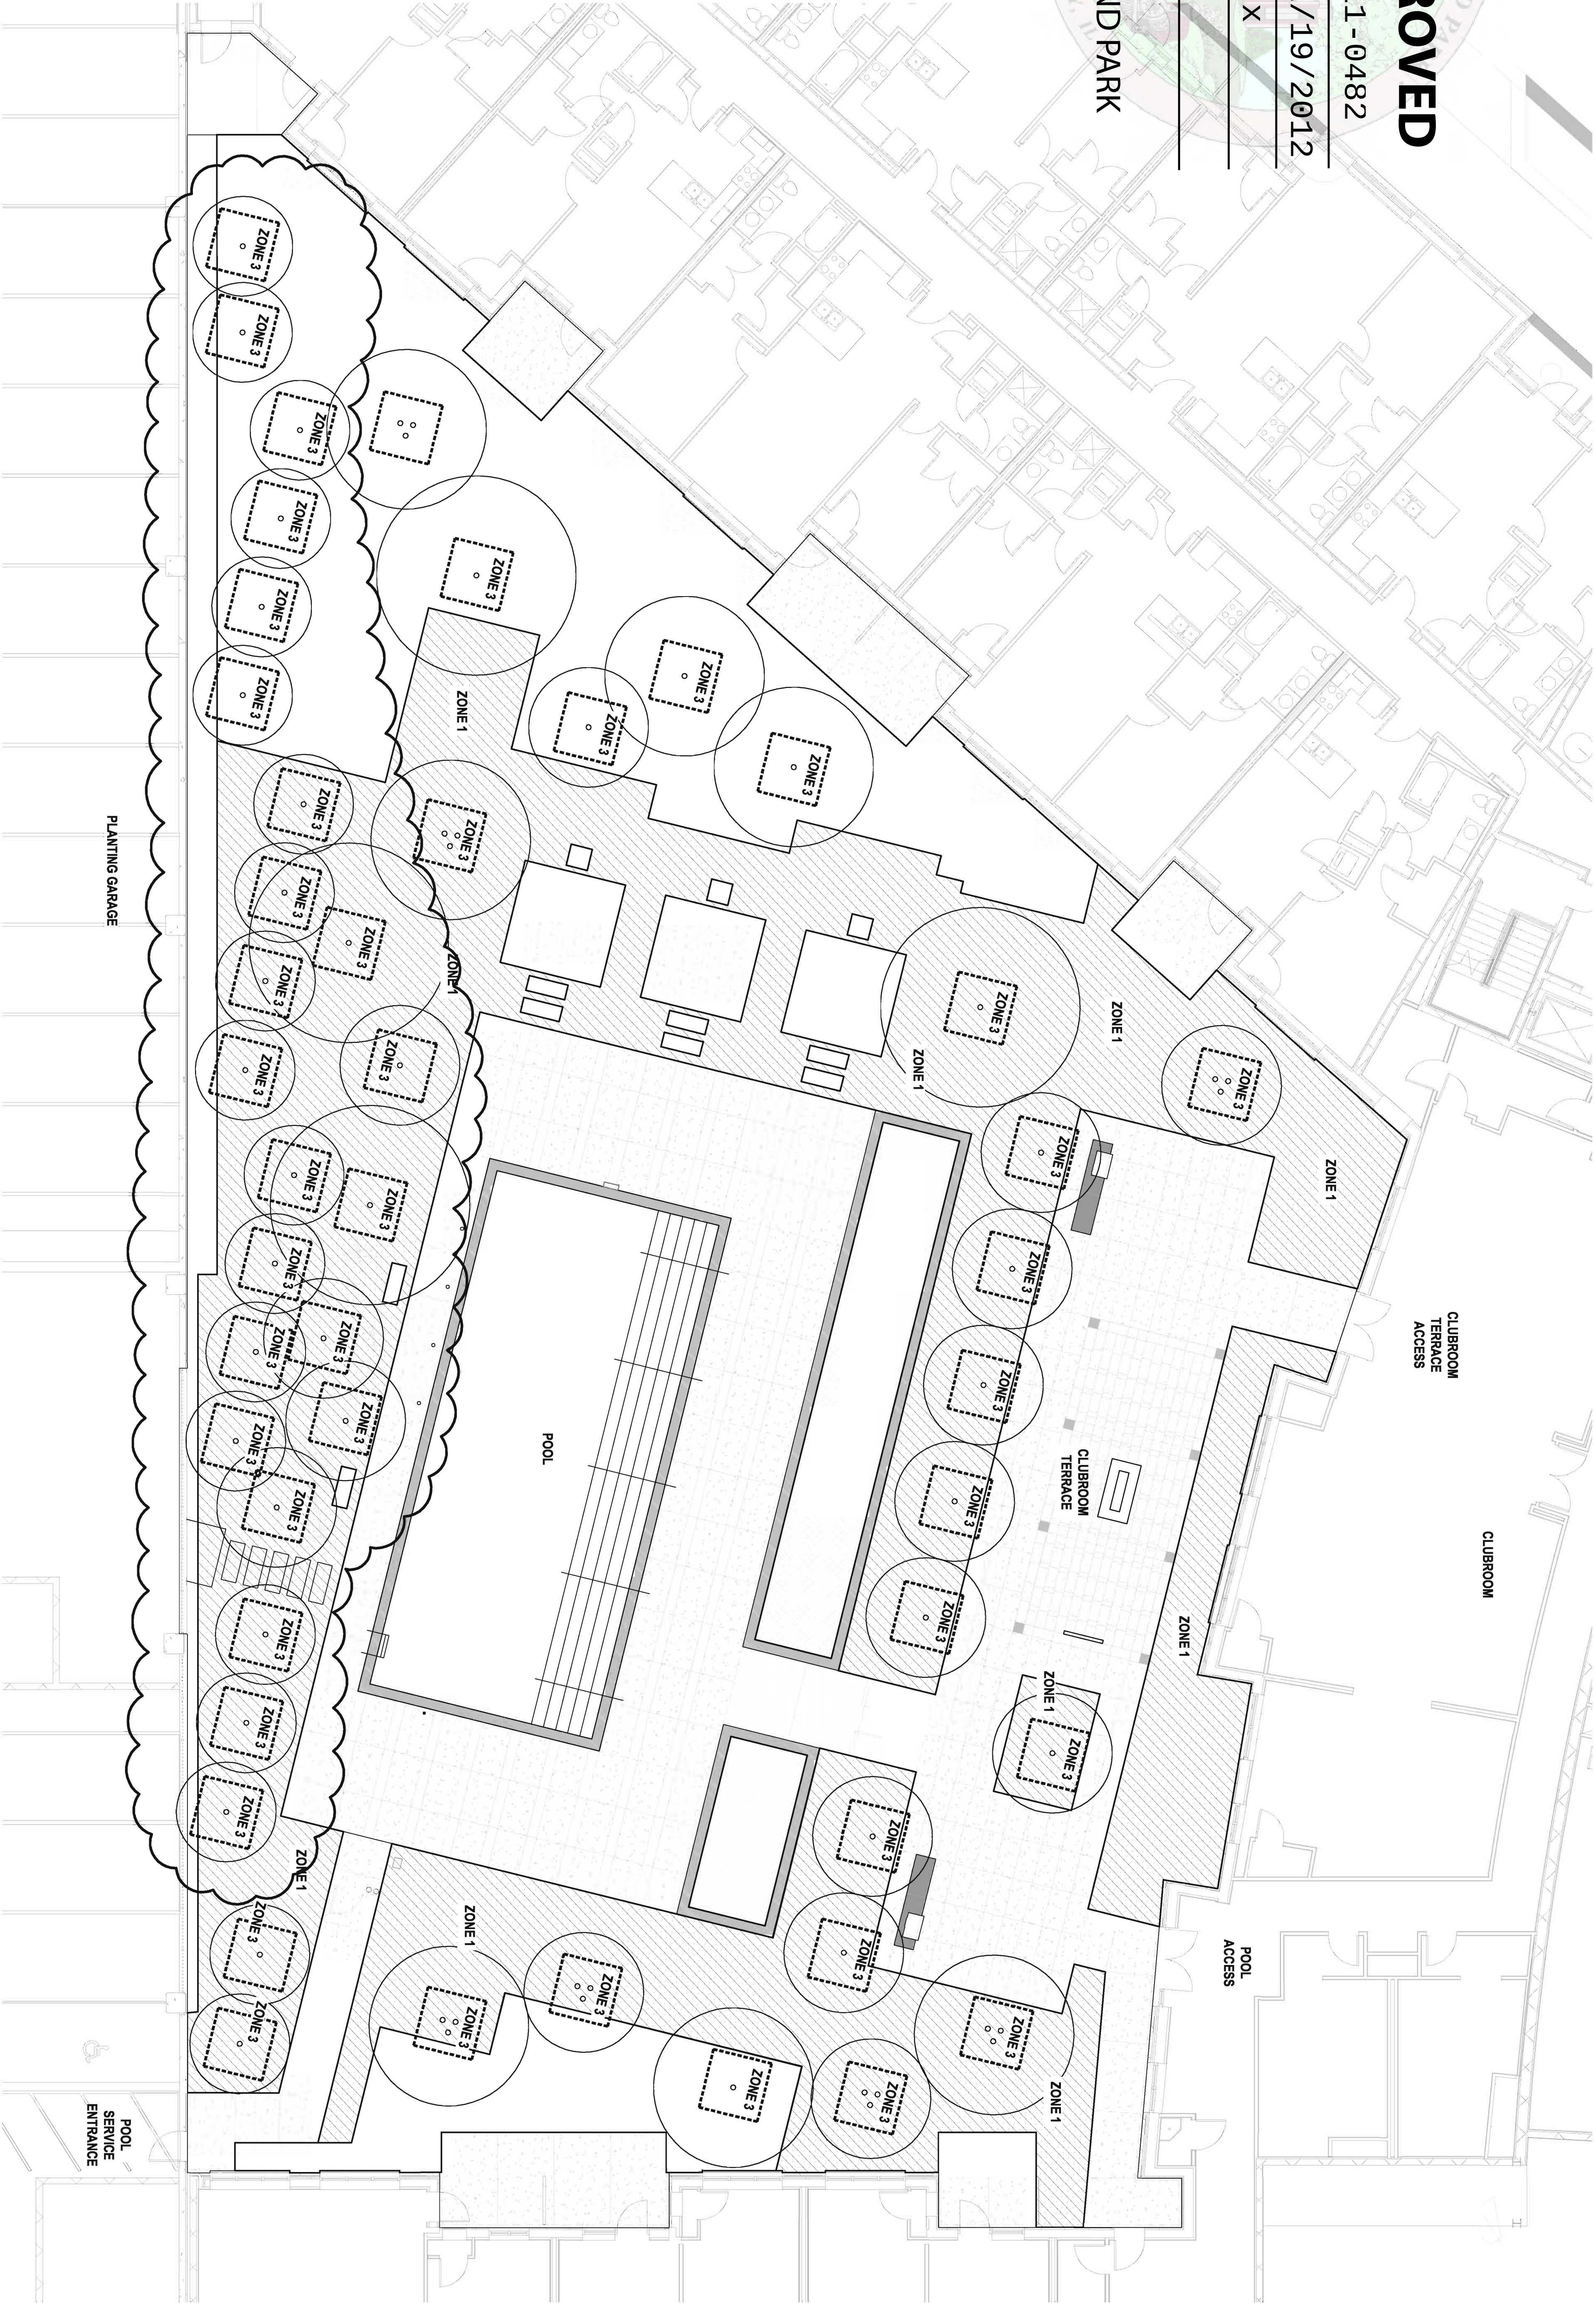

LANDSCAPE IRRIGATION GUIDELINES

- ZONE 1 - DRIP IRRIGATION ON SEPARATE VALVES
- ZONE 2 - POP UP SPRINK IRRIGATION ON SEPARATE VALVES
- ZONE 3 - POP UP FLOOD BUBBLERS - FOR TREES - ON SEPARATE VALVES

NOTES:

- THE EXTENT OF THE LANDSCAPE WILL BE WATERED USING A HIGH-EFFICIENCY AUTOMATIC IRRIGATION SYSTEM OPERATED BY CONTROLLER(S), LOCATION TO BE APPROVED BY LANDSCAPE ARCHITECT.
- FLOW CONTROL WILL BE ADDRESSED BY THE USE OF A FLOW SENSOR AND MASTER VALVE. WATER USAGE WILL BE MANAGED THROUGH THE CORRECT VALVING OF ZONES 1,3 AND PROPER USE OF IRRIGATION DRIP LINES AND BUBBLERS.
- FINAL IRRIGATION DESIGN AND EQUIPMENT LOCATION TO BE APPROVED BY LANDSCAPE ARCHITECT, INCLUDING: BLACKFLOW PREVENTOR, IRRIGATION CONTROLLER, VALVE BOXES, RAIN SENSOR, HOSE BIBS, ETC.
- IRRIGATION CONTROLLER TO BE LOCATED IN POOL EQUIPMENT ROOM OR MECHANICAL ROOM AS APPROVED BY LANDSCAPE ARCHITECT.
- ALL VALVE BOXES TO BE LOCATED IN PLANTING AREAS AS APPROVED BY LANDSCAPE ARCHITECT.
- CONTRACTOR TO ACCOMODATE IRRIGATION LATERALS AND CONDUIT THROUGH HARDSCAPE.

DESIGN COLLECTIVE

ARCHITECTURE, PLANNING, INTERIORS
WWW.DESIGNCOLLECTIVE.COM

601 EAST PRATT STREET, SUITE 300
BALTIMORE, MARYLAND 21202
T: 410.685.6655 F: 410.539.6242

312 BLACKWELL STREET, SUITE 100
DURHAM, NORTH CAROLINA 27701
T: 919.381.9322 F: 919.381.9323

DESIGN COLLECTIVE, INC. ALL RIGHTS RESERVED	
ISSUED FOR	DATE
1. LANDSCAPE REVISIONS	2012.09.10
2. ISSUED FOR PERMIT	2012.04.13
3. LANDSCAPE REVISIONS	2012.04.13
4. LANDSCAPE REVISIONS	2012.04.13
5. LANDSCAPE REVISIONS	2012.04.13
100. LANDSCAPE REVISIONS	2012.04.13

OWNER / DEVELOPER
METRA TRIANGLE FC, LLC.
8900 KEYSTONE CROSSING
SUITE 200
INDIANAPOLIS, INDIANA 46240
PROJECT NAME
9750 ON THE PARK

PROJECT ADDRESS
DOWNTOWN ORLAND PARK, ILLINOIS
PROJECT MANAGEMENT
DCI Project No. 678-11
Owner Project No. 678-11
Drawn by AG Checked by BR
SEAL



SHEET TITLE
POOL COURTYARD IRRIGATION PLAN

SCALE
1/8" = 1'-0"

SHEET NUMBER

L106

BOARD APPROVED

Case No: 2011 - 0482

Date: 11/19/2012


W/Conditions:

X

W/Out Conditions:

COURTYARD ACCESS

VILLAGE OF ORLAND PARK

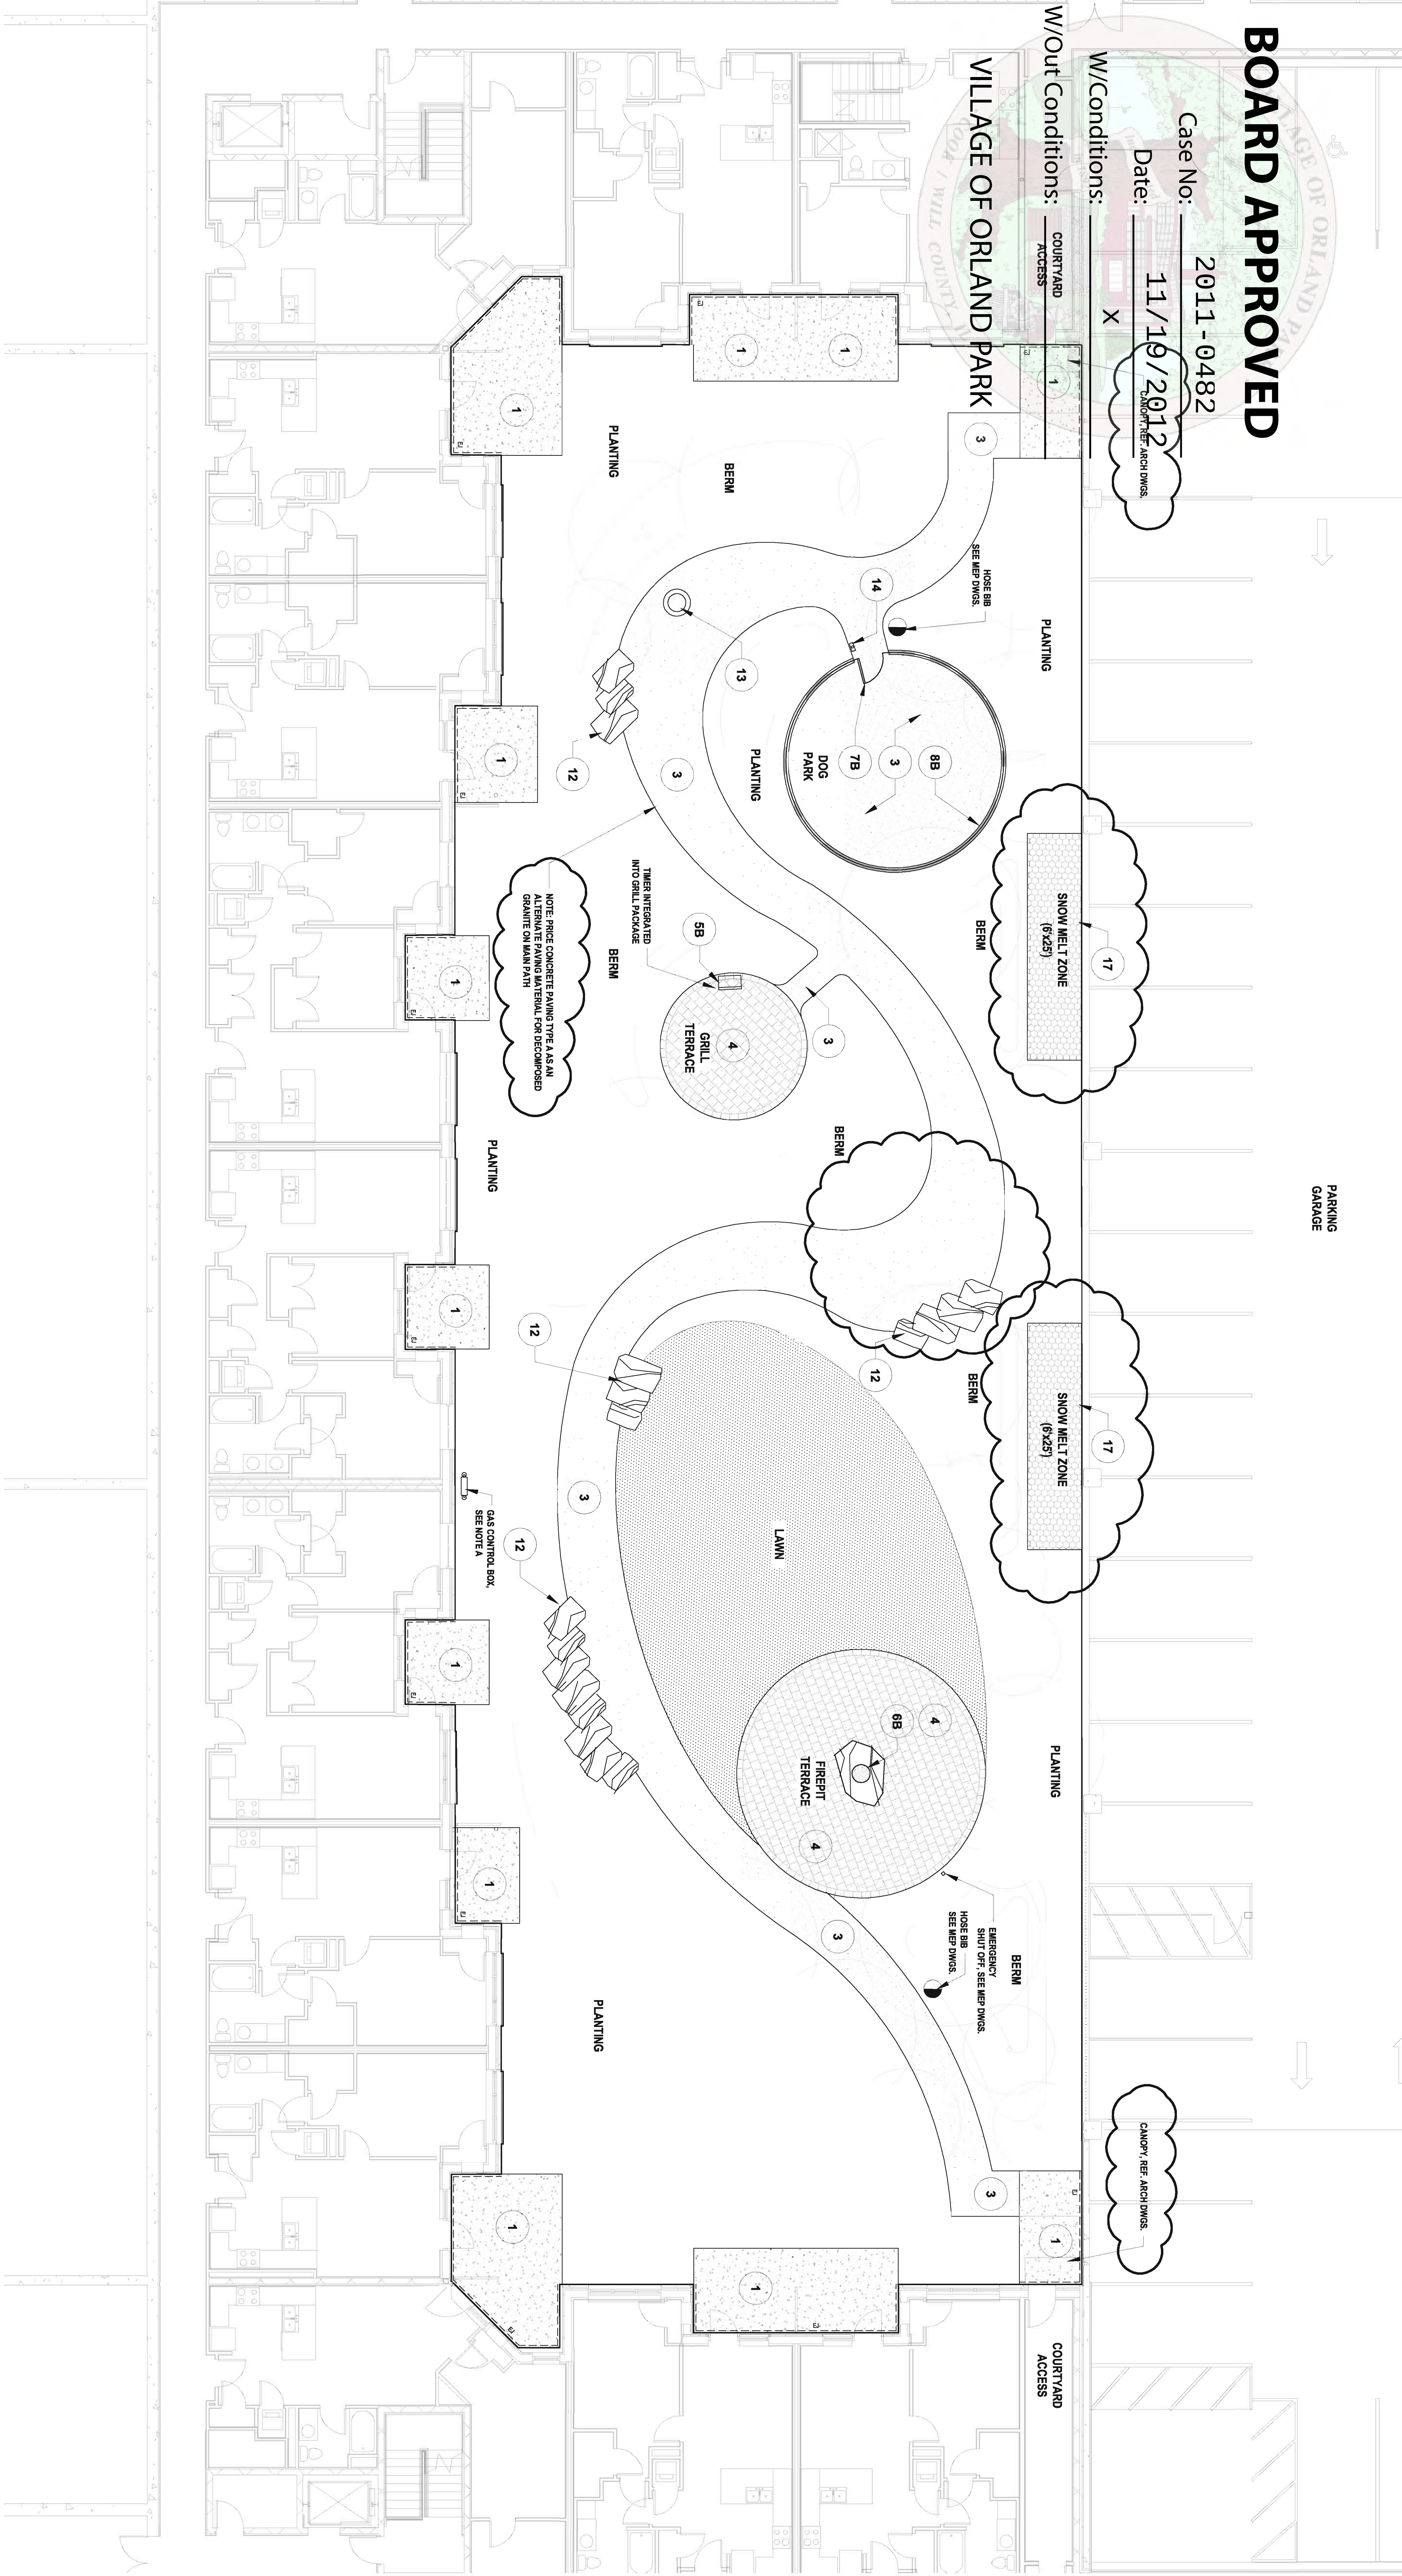

MASTER MATERIALS LEGEND

1	1	CONCRETE PAVING - TYPE A COLOR: STANDARD GREY FINISH: LIGHT BROOK
2	1	CONCRETE PAVING - TYPE B STANDARD GREY FINISH: MEDIUM SANDBLAST
3	6	DECOMPOSED GRANITE WITH STABILIZER SUPPLIER: CHARLES LUCK STONE
4	5	ALTERNATE: CONCRETE PAVING TYPE A, SCORING TO BE PROVIDED BY LANDSCAPE ARCHITECT IF ALTERNATE IS ACCEPTED. CONCRETE UNIT PAVES SUPPLIER: HANOVER ARCHITECTURAL PAVERS COLOR: 50% SOUTH MOUNTAIN SAND BLEND 90% CHOCOLATE TAN BLEND SIZE: 6\"/>
5A	4	GRILL STATION - TYPE A - TYPICAL OF 2 STAINLESS STEEL GAS GRILL IN SINGLE SIDE BURNER AND POLISHED CONCRETE COUNTER TOP SAFETY TOWER BUILT INTO SIDE OF GRILL STATION
5B	1	GRILL STATION - TYPE B STAINLESS STEEL GAS GRILL IN DOUBLE BURNER AND POLISHED CONCRETE COUNTER TOP SAFETY TOWER BUILT INTO SIDE OF GRILL STATION

6A	1	FIRE PIT - TYPE A STONE: WALKERBUSH BUFF SUPPLIER: CHARLES LUCK STONE SEE LIST FOR TIER 1 & EMERGENCY SHUT OFF LOCATION
6B	1	FIRE PIT - TYPE B WITH WETTERIDGE OUTCROPPING SUPPLIER: CHARLES LUCK STONE QUARRY: HALLOIST SEE LIST FOR TIER 1 & EMERGENCY SHUT OFF LOCATION
7A	2	POOL GATE - 48\"/>
7B	5	SELF-CLOSING SELF-LATCHING POWERCOATED TUBULAR STEEL GATE COLOR TBA BY LANDSCAPE ARCHITECT
8A	1	POOL FENCE - 48\"/>
8B	3	DOG PARK FENCE - 36\"/>
9	4	CONCRETE CURB - 6\"/>

10	1	TRELLIS MAINLY FACTURED BY WILDALE (OR EQUAL) WITH RETRACTABLE SHIMBELLA CANVAS SHADE CANOPY (EXCEPT AT FIRE PIT) COLOR: BROWN (TO BE APPROVED BY LANDSCAPE ARCHITECT)
11	7	2\"/>
12	2	BOULDER OUTCROPPING (GROUPINGS OF 3, 4, AND 5 BOULDERS) STONE: LAMONA WEATHERED OUTCROPPING SUPPLIER: CHARLES LUCK STONE THICKNESS: 2\"/>
13	2	WATER FEATURE - TYPICAL OF 2 QUARRY: HALLOIST STYLED BY AQUADUX FOUNTAIN KIT
14	1	DOG WASTE BAGS STATION 30\"/>
15	1	TOTAL SCENIC COLOR: CREAM STYLE: PROCELEB SIZE: 10\"/>
16		OUTDOOR TELEVISION - PROVIDED BY OWNER

17

1

NOTE: 1. GAS CONTROL BOX
MOUNT BOX TO 12\"/>

DESIGN COLLECTIVE

ARCHITECTURE, PLANNING, INTERIORS
WWW.DESIGNCOLLECTIVE.COM


601 EAST PRATT STREET, SUITE 300
BALTIMORE, MARYLAND 21202
T: 410.685.6655 F: 410.539.6242

312 BLACKWELL STREET, SUITE 100
DURHAM, NORTH CAROLINA 27701
T: 919.381.9322 F: 919.381.9323

DESIGN COLLECTIVE, LLC. ALL RIGHTS RESERVED.	
ISSUED FOR PERMIT	2012.04.13
LANDSCAPE REVISIONS	2012.09.10
DATE	
CONSULTANT	

OWNER / DEVELOPER
METRA TRIANGLE FC,
LLC.
8900 KESTONE CROSSING
SUITE 200
INDIANAPOLIS, INDIANA 46240
PROJECT NAME
9750 ON THE PARK

PROJECT ADDRESS
DOWNTOWN ORLAND PARK,
ILLINOIS
PROJECT MANAGEMENT
DCI Project No. 678-11
Owner Project No. ---
Drawn by AG Checked by BR
SCALE

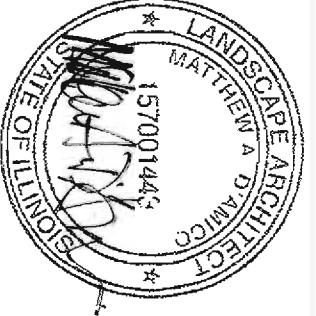

SHEET TITLE
GARDEN COURTYARD
MATERIALS PLAN

SCALE
1/8" = 1'-0"

SHEET NUMBER

L201

BOARD APPROVED


Case No: 2011 - 0482

Date: 11/19/2012

W/Conditions: COURTYARD ACCESS

W/Out Conditions:

VILLAGE OF ORLAND PARK

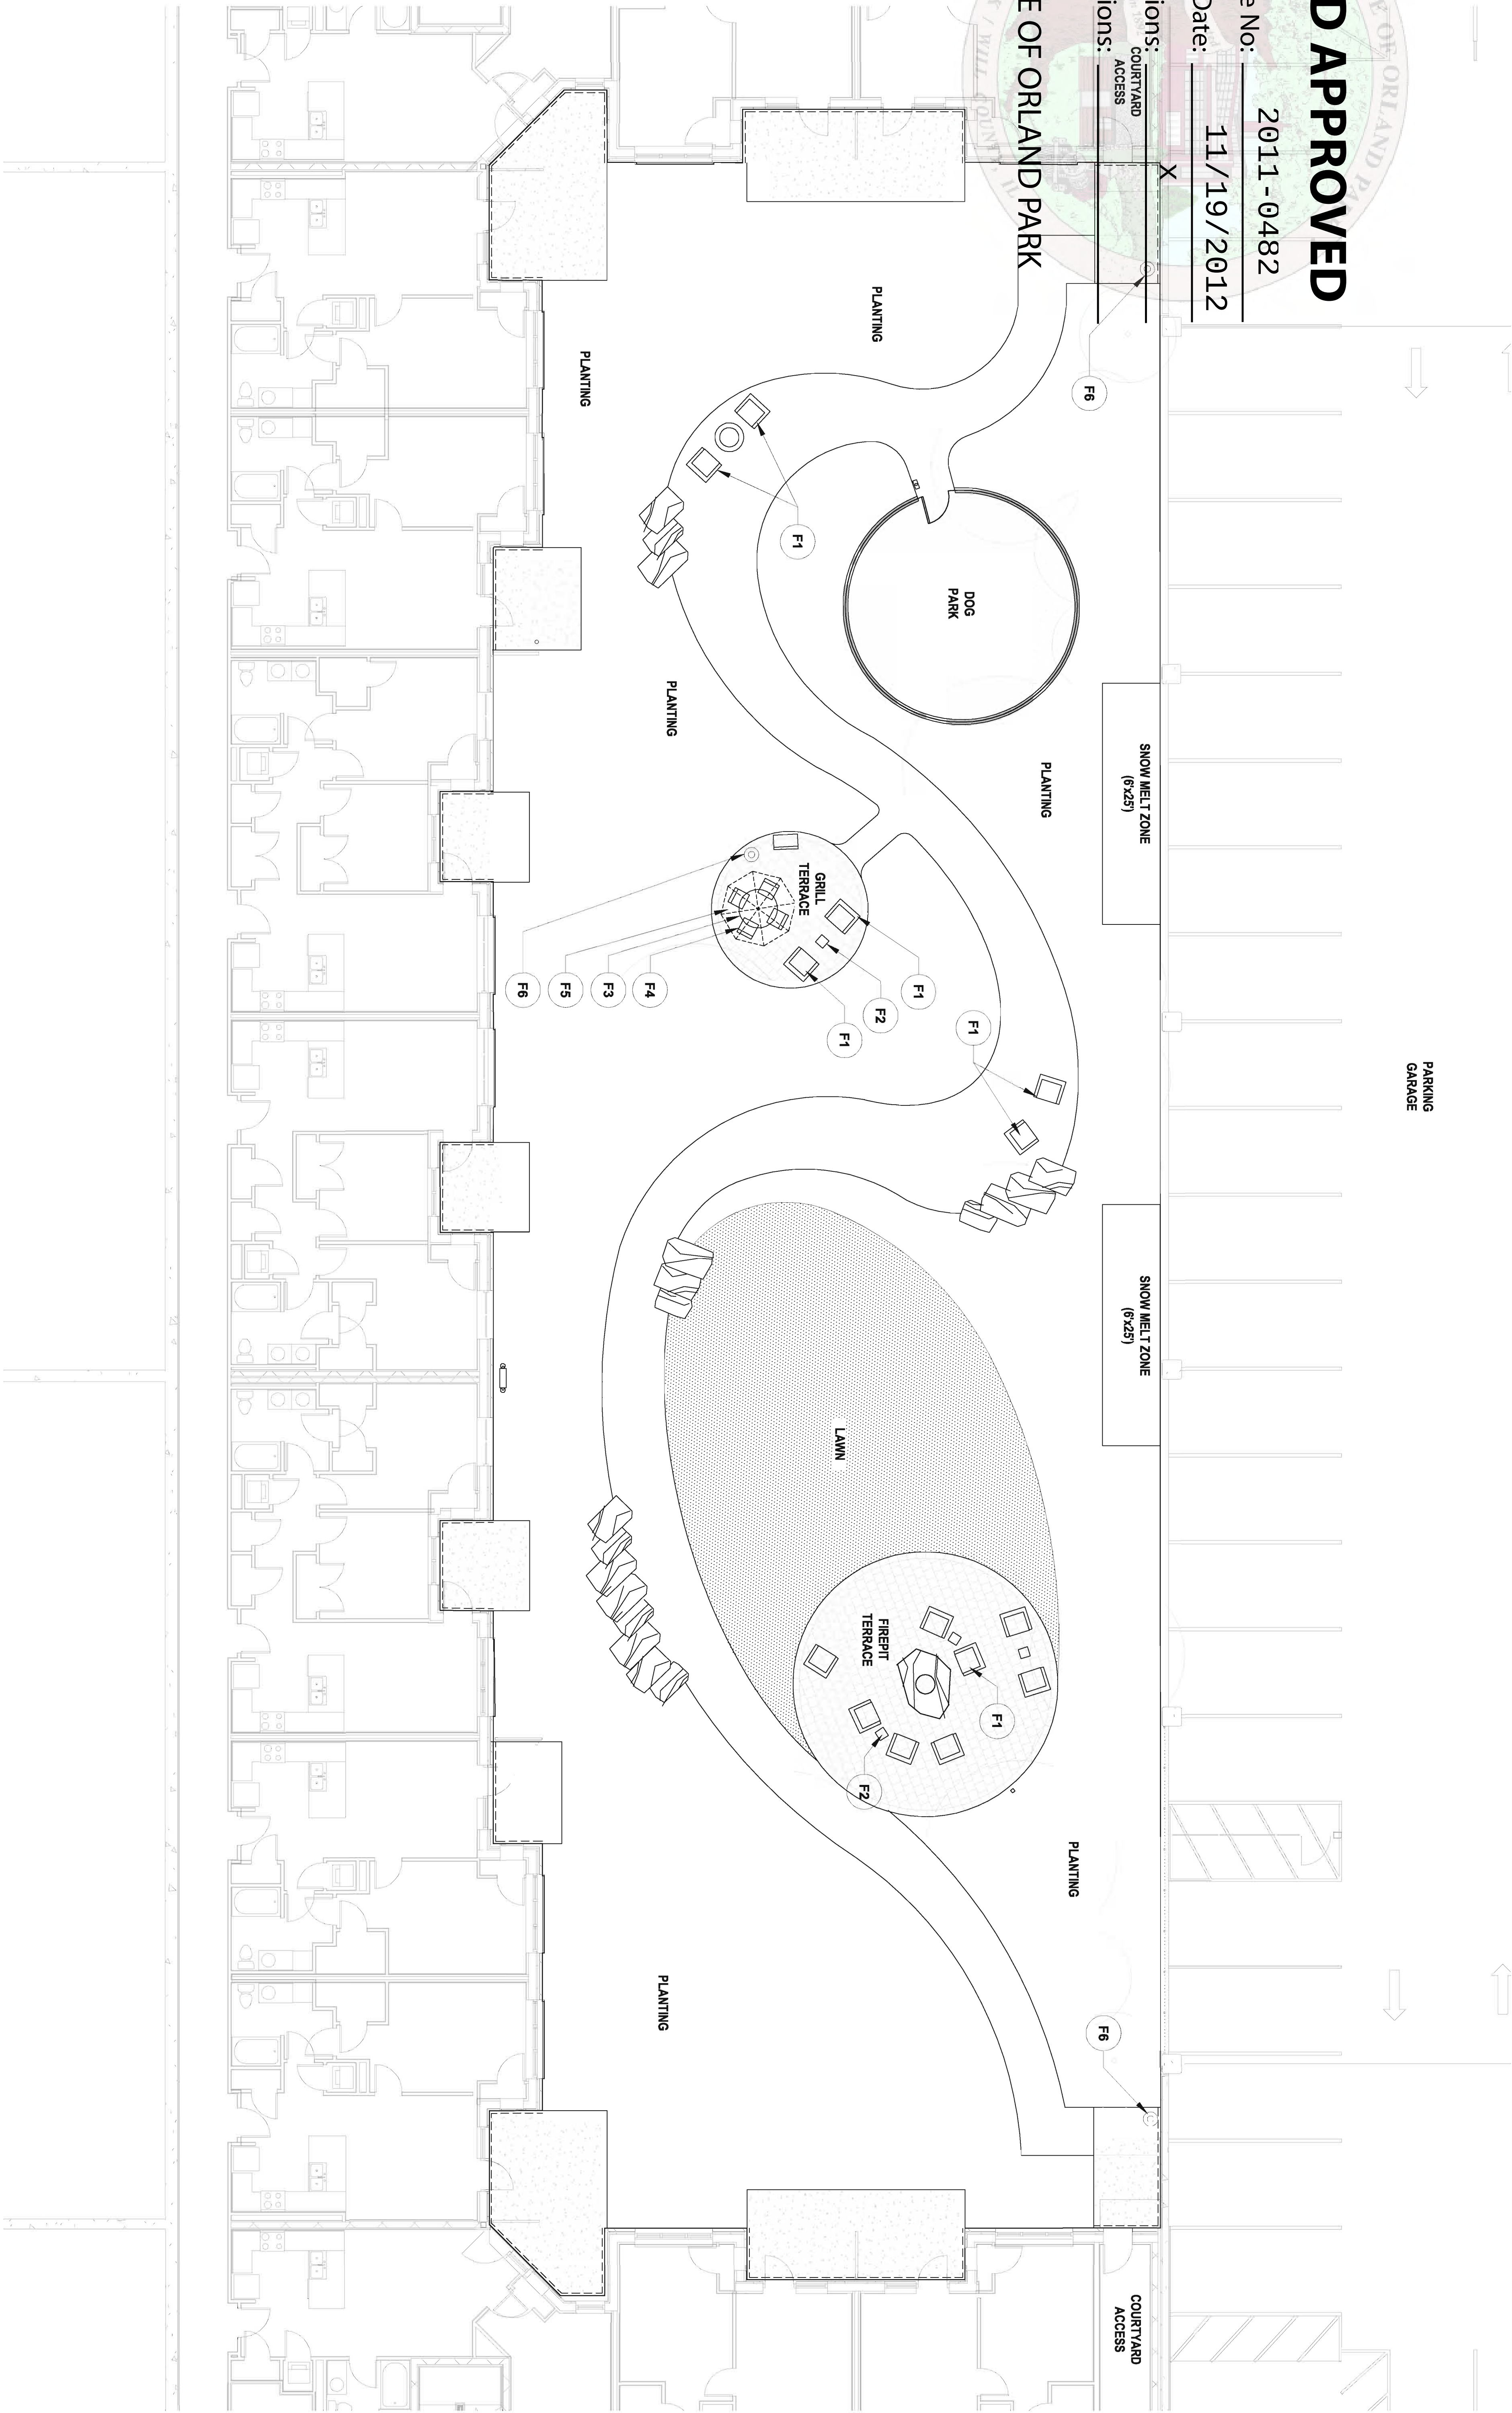

SITE FURNITURE LEGEND - GARDEN COURTYARD

- F1 LOUNGE CHAIR WITH CUSHION - QTY: 16
MANUFACTURER: RESTORATION HARDWARE
STYLE: BELLEVUE LOUNGE CHAIR
CUSHION: SUNBELLA FABRIC
CUSHION COLOR: MOCHA
- F2 SIDE TABLE - QTY: 5
MANUFACTURER: RESTORATION HARDWARE
STYLE: CATEY ALUMINUM DINING CHAIR
COLOR: NATURAL
- F3 DINING TABLE - QTY: 3
MANUFACTURER: LANDSCAPE FORMS
STYLE: EQUINOX UMBRELLA - 8' OCTAGON WITH PLAIN EDGE
COLOR: STONE/CLOUD
- F4 DINING CHAIR - QTY: 12
MANUFACTURER: LANDSCAPE FORMS
STYLE: EQUINOX UMBRELLA - 8' OCTAGON WITH PLAIN EDGE
COLOR: GINKGO
- F5 TRASH CAN - QTY: 1
MANUFACTURER: THREE BUSINESS PRODUCTS
STYLE: CLASSIC STEEL DROP TOP 25L
RECEPTACLE: CHARCOAL - #RLWRSZCH
- F6

DESIGN COLLECTIVE

ARCHITECTURE, PLANNING, INTERIORS
WWW.DESIGNCOLLECTIVE.COM

601 EAST PRATT STREET, SUITE 300
BALTIMORE, MARYLAND 21202
T: 410.685.6655 F: 410.539.6242

312 BLACKWELL STREET, SUITE 100
DURHAM, NORTH CAROLINA 27701
T: 919.381.9322 F: 919.381.9323

DESIGN COLLECTIVE, INC. ALL RIGHTS RESERVED	DATE
ISSUED FOR PERMIT	2012.09.10
1. LANDSCAPE REVISIONS	2012.04.13
2. ISSUED FOR PERMIT	2012.04.13
3. ISSUED FOR PERMIT	2012.04.13
4. ISSUED FOR PERMIT	2012.04.13
100. ISSUED FOR PERMIT	2012.04.13

OWNER / DEVELOPER
METRA TRIANGLE FC,
LLC.

8900 KEystone CROSSING
SUITE 200
INDIANAPOLIS, INDIANA 46240
PROJECT NAME
9750 ON THE PARK

PROJECT ADDRESS
DOWNTOWN ORLAND PARK,
ILLINOIS

PROJECT MANAGEMENT
DCI Project No. 678-11
Owner Project No. ---
Drawn by AG Checked by BR
SCALE



SHEET TITLE
GARDEN COURTYARD
FURNITURE PLAN

SCALE
1/8" = 1'-0"

SHEET NUMBER

L202

BOARD APPROVED

Case No: 2011-0482

Date: 11/19/2012

W/Conditions: COURTYARD ACCESS

W/Out Conditions: ACCESS

VILLAGE OF ORLAND PARK

PARKING GARAGE

NOTE A: DRAINAGE DEPRESSION AT CURB, TOP OF 6. SET CURB FLUSH TOP. COORDINATE LOCATIONS TO AVOID CONFLICT WITH FENCE POSTS. SPACE DEPRESSIONS EQUALLY.

PLANTING SPACE
DEPRESSION
SEE NOTE A

SNOW MELT ZONE
DRAIN
6.699.5

PLANTING

SNOW MELT ZONE
DRAIN
6.699.5

PLANTING


COURTYARD ACCESS

6.699.8
6.699.5
6.699.3
6.699.0
6.698.7
6.698.4
6.698.1
6.697.8
6.697.5
6.697.2
6.696.9
6.696.6
6.696.3
6.696.0
6.695.7
6.695.4
6.695.1
6.694.8
6.694.5
6.694.2
6.693.9
6.693.6
6.693.3
6.693.0
6.692.7
6.692.4
6.692.1
6.691.8
6.691.5
6.691.2
6.690.9
6.690.6
6.690.3
6.689.9
6.689.6
6.689.3
6.689.0
6.688.7
6.688.4
6.688.1
6.687.8
6.687.5
6.687.2
6.686.9
6.686.6
6.686.3
6.686.0
6.685.7
6.685.4
6.685.1
6.684.8
6.684.5
6.684.2
6.683.9
6.683.6
6.683.3
6.683.0
6.682.7
6.682.4
6.682.1
6.681.8
6.681.5
6.681.2
6.680.9
6.680.6
6.680.3
6.679.9
6.679.6
6.679.3
6.679.0
6.678.7
6.678.4
6.678.1
6.677.8
6.677.5
6.677.2
6.676.9
6.676.6
6.676.3
6.676.0
6.675.7
6.675.4
6.675.1
6.674.8
6.674.5
6.674.2
6.673.9
6.673.6
6.673.3
6.673.0
6.672.7
6.672.4
6.672.1
6.671.8
6.671.5
6.671.2
6.670.9
6.670.6
6.670.3
6.669.9
6.669.6
6.669.3
6.669.0
6.668.7
6.668.4
6.668.1
6.667.8
6.667.5
6.667.2
6.666.9
6.666.6
6.666.3
6.666.0
6.665.7
6.665.4
6.665.1
6.664.8
6.664.5
6.664.2
6.663.9
6.663.6
6.663.3
6.663.0
6.662.7
6.662.4
6.662.1
6.661.8
6.661.5
6.661.2
6.660.9
6.660.6
6.660.3
6.659.9
6.659.6
6.659.3
6.659.0
6.658.7
6.658.4
6.658.1
6.657.8
6.657.5
6.657.2
6.656.9
6.656.6
6.656.3
6.656.0
6.655.7
6.655.4
6.655.1
6.654.8
6.654.5
6.654.2
6.653.9
6.653.6
6.653.3
6.653.0
6.652.7
6.652.4
6.652.1
6.651.8
6.651.5
6.651.2
6.650.9
6.650.6
6.650.3
6.649.9
6.649.6
6.649.3
6.649.0
6.648.7
6.648.4
6.648.1
6.647.8
6.647.5
6.647.2
6.646.9
6.646.6
6.646.3
6.646.0
6.645.7
6.645.4
6.645.1
6.644.8
6.644.5
6.644.2
6.643.9
6.643.6
6.643.3
6.643.0
6.642.7
6.642.4
6.642.1
6.641.8
6.641.5
6.641.2
6.640.9
6.640.6
6.640.3
6.639.9
6.639.6
6.639.3
6.639.0
6.638.7
6.638.4
6.638.1
6.637.8
6.637.5
6.637.2
6.636.9
6.636.6
6.636.3
6.636.0
6.635.7
6.635.4
6.635.1
6.634.8
6.634.5
6.634.2
6.633.9
6.633.6
6.633.3
6.633.0
6.632.7
6.632.4
6.632.1
6.631.8
6.631.5
6.631.2
6.630.9
6.630.6
6.630.3
6.629.9
6.629.6
6.629.3
6.629.0
6.628.7
6.628.4
6.628.1
6.627.8
6.627.5
6.627.2
6.626.9
6.626.6
6.626.3
6.626.0
6.625.7
6.625.4
6.625.1
6.624.8
6.624.5
6.624.2
6.623.9
6.623.6
6.623.3
6.623.0
6.622.7
6.622.4
6.622.1
6.621.8
6.621.5
6.621.2
6.620.9
6.620.6
6.620.3
6.619.9
6.619.6
6.619.3
6.619.0
6.618.7
6.618.4
6.618.1
6.617.8
6.617.5
6.617.2
6.616.9
6.616.6
6.616.3
6.616.0
6.615.7
6.615.4
6.615.1
6.614.8
6.614.5
6.614.2
6.613.9
6.613.6
6.613.3
6.613.0
6.612.7
6.612.4
6.612.1
6.611.8
6.611.5
6.611.2
6.610.9
6.610.6
6.610.3
6.609.9
6.609.6
6.609.3
6.609.0
6.608.7
6.608.4
6.608.1
6.607.8
6.607.5
6.607.2
6.606.9
6.606.6
6.606.3
6.606.0
6.605.7
6.605.4
6.605.1
6.604.8
6.604.5
6.604.2
6.603.9
6.603.6
6.603.3
6.603.0
6.602.7
6.602.4
6.602.1
6.601.8
6.601.5
6.601.2
6.600.9
6.600.6
6.600.3
6.599.9
6.599.6
6.599.3
6.599.0
6.598.7
6.598.4
6.598.1
6.597.8
6.597.5
6.597.2
6.596.9
6.596.6
6.596.3
6.596.0
6.595.7
6.595.4
6.595.1
6.594.8
6.594.5
6.594.2
6.593.9
6.593.6
6.593.3
6.593.0
6.592.7
6.592.4
6.592.1
6.591.8
6.591.5
6.591.2
6.590.9
6.590.6
6.590.3
6.589.9
6.589.6
6.589.3
6.589.0
6.588.7
6.588.4
6.588.1
6.587.8
6.587.5
6.587.2
6.586.9
6.586.6
6.586.3
6.586.0
6.585.7
6.585.4
6.585.1
6.584.8
6.584.5
6.584.2
6.583.9
6.583.6
6.583.3
6.583.0
6.582.7
6.582.4
6.582.1
6.581.8
6.581.5
6.581.2
6.580.9
6.580.6
6.580.3
6.579.9
6.579.6
6.579.3
6.579.0
6.578.7
6.578.4
6.578.1
6.577.8
6.577.5
6.577.2
6.576.9
6.576.6
6.576.3
6.576.0
6.575.7
6.575.4
6.575.1
6.574.8
6.574.5
6.574.2
6.573.9
6.573.6
6.573.3
6.573.0
6.572.7

Date: 11/19/2012


W/Out Conditions:

NOTE A: DRAINAGE DEPRESSION AT CURB, TYP. OF 6. SET CURB FLUSH TYP. COORDINATE LOCATIONS TO AVOID CONFLICT WITH FENCE POSTS. SPACE DEPRESSIONS EQUALLY.

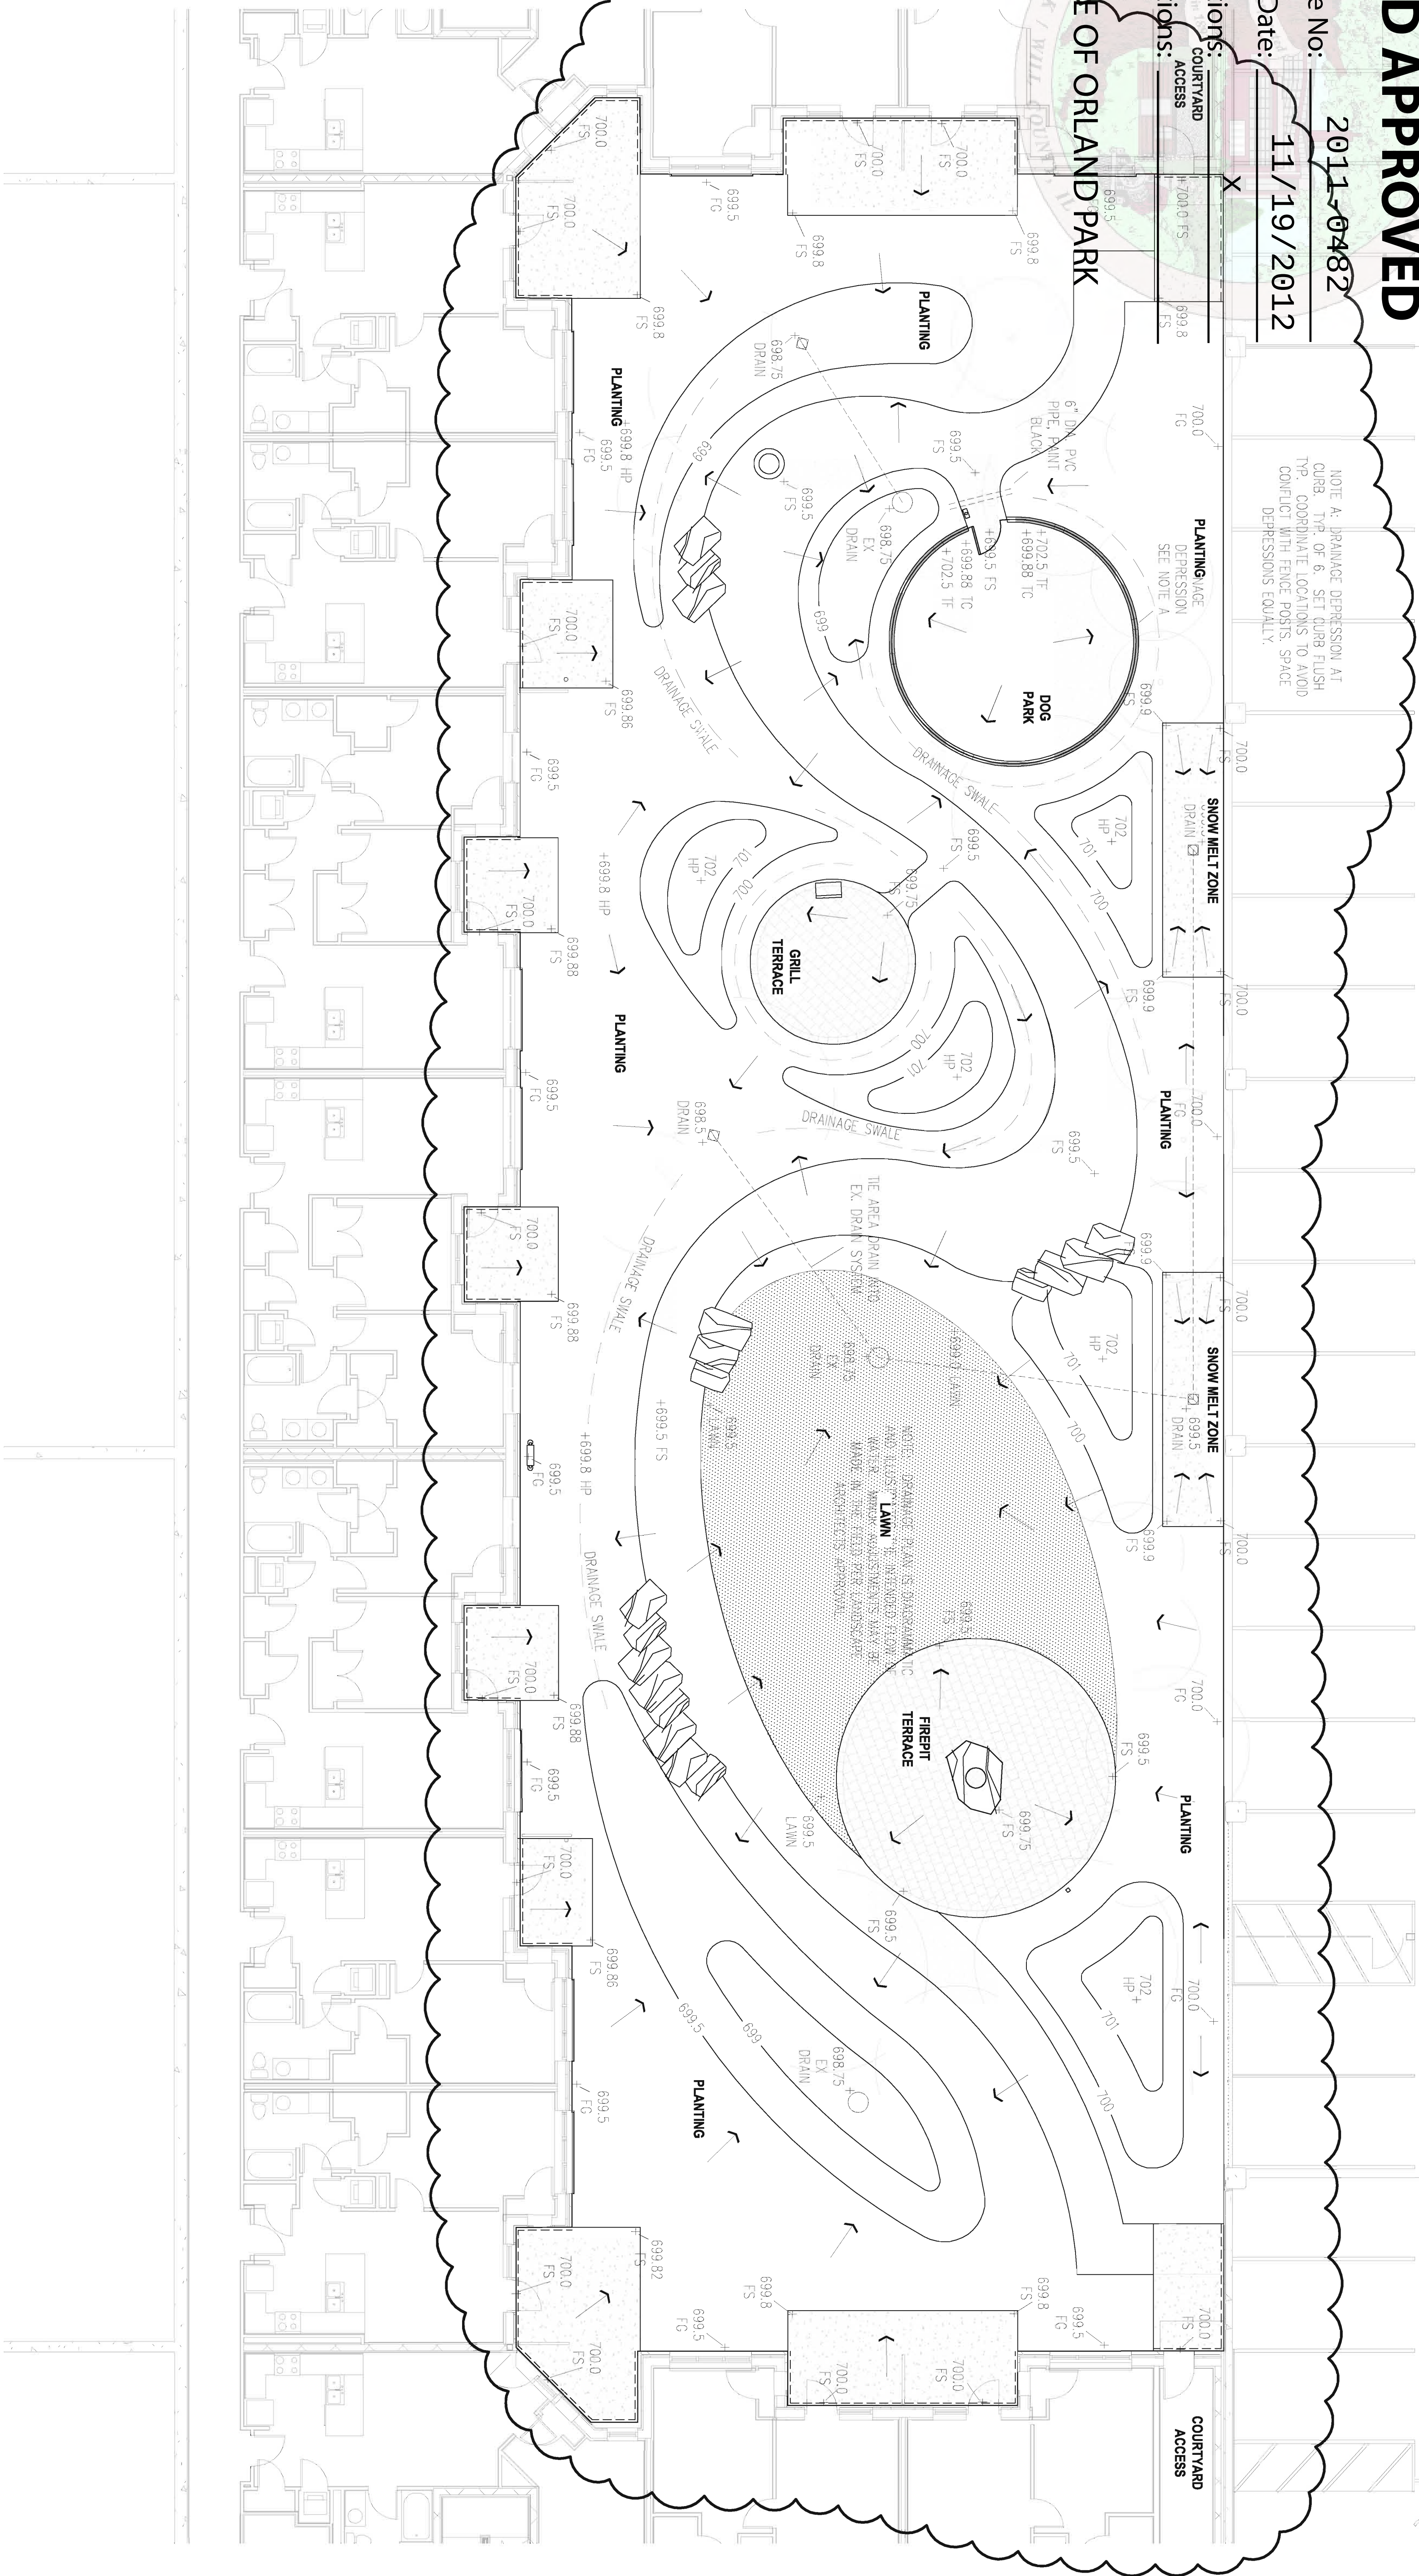

LEGEND - ABBREVIATIONS

TC	TOP OF CURB
TF	TOP OF FENCE
FS	FINISH SURFACE
FG	FINISH GRADE
LP	LOW POINT (DRAIN)

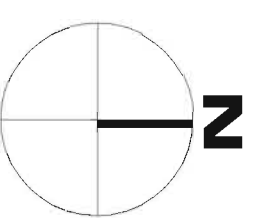

ARCHITECTURE, PLANNING, INTERIORS
WWW.DESIGNCOLLECTIVE.COM

312 BLACKWELL STREET, SUITE 100
DURHAM, NORTH CAROLINA 27701
T: 919.381.9322 F: 919.381.9323

[illegible]

OWNER / DEVELOPER
**METRA TRIANGLE FC,
LLC.**

**8900 KEYSTONE CROSSING
SUITE 200
INDIANAPOLIS, INDIANA 46240
PROJECT NAME
9750 ON THE PARK**

PROJECT ADDRESS
DOWNTOWN ORLAND PARK,
ILLINOIS

PROJECT MANAGEMENT
DCI Project No. 678-11
Owner Project No. ----
Drawn by AG Checked by BR
SEAL



SHEET TITLE
GARDEN COURTYARD
GRADING PLAN

SCALE
1/8" = 1'-0"

SHEET NUMBER

L203

BOARD APPROVED

Case No.: 2011-0482

COURTYARD ACCESS

Date: 11/19/2012



W/Conditions: X

W/Out Conditions:


VILLAGE OF ORLAND PARK

W/Conditions: _____

VILLAGE OF ORLAND PARK

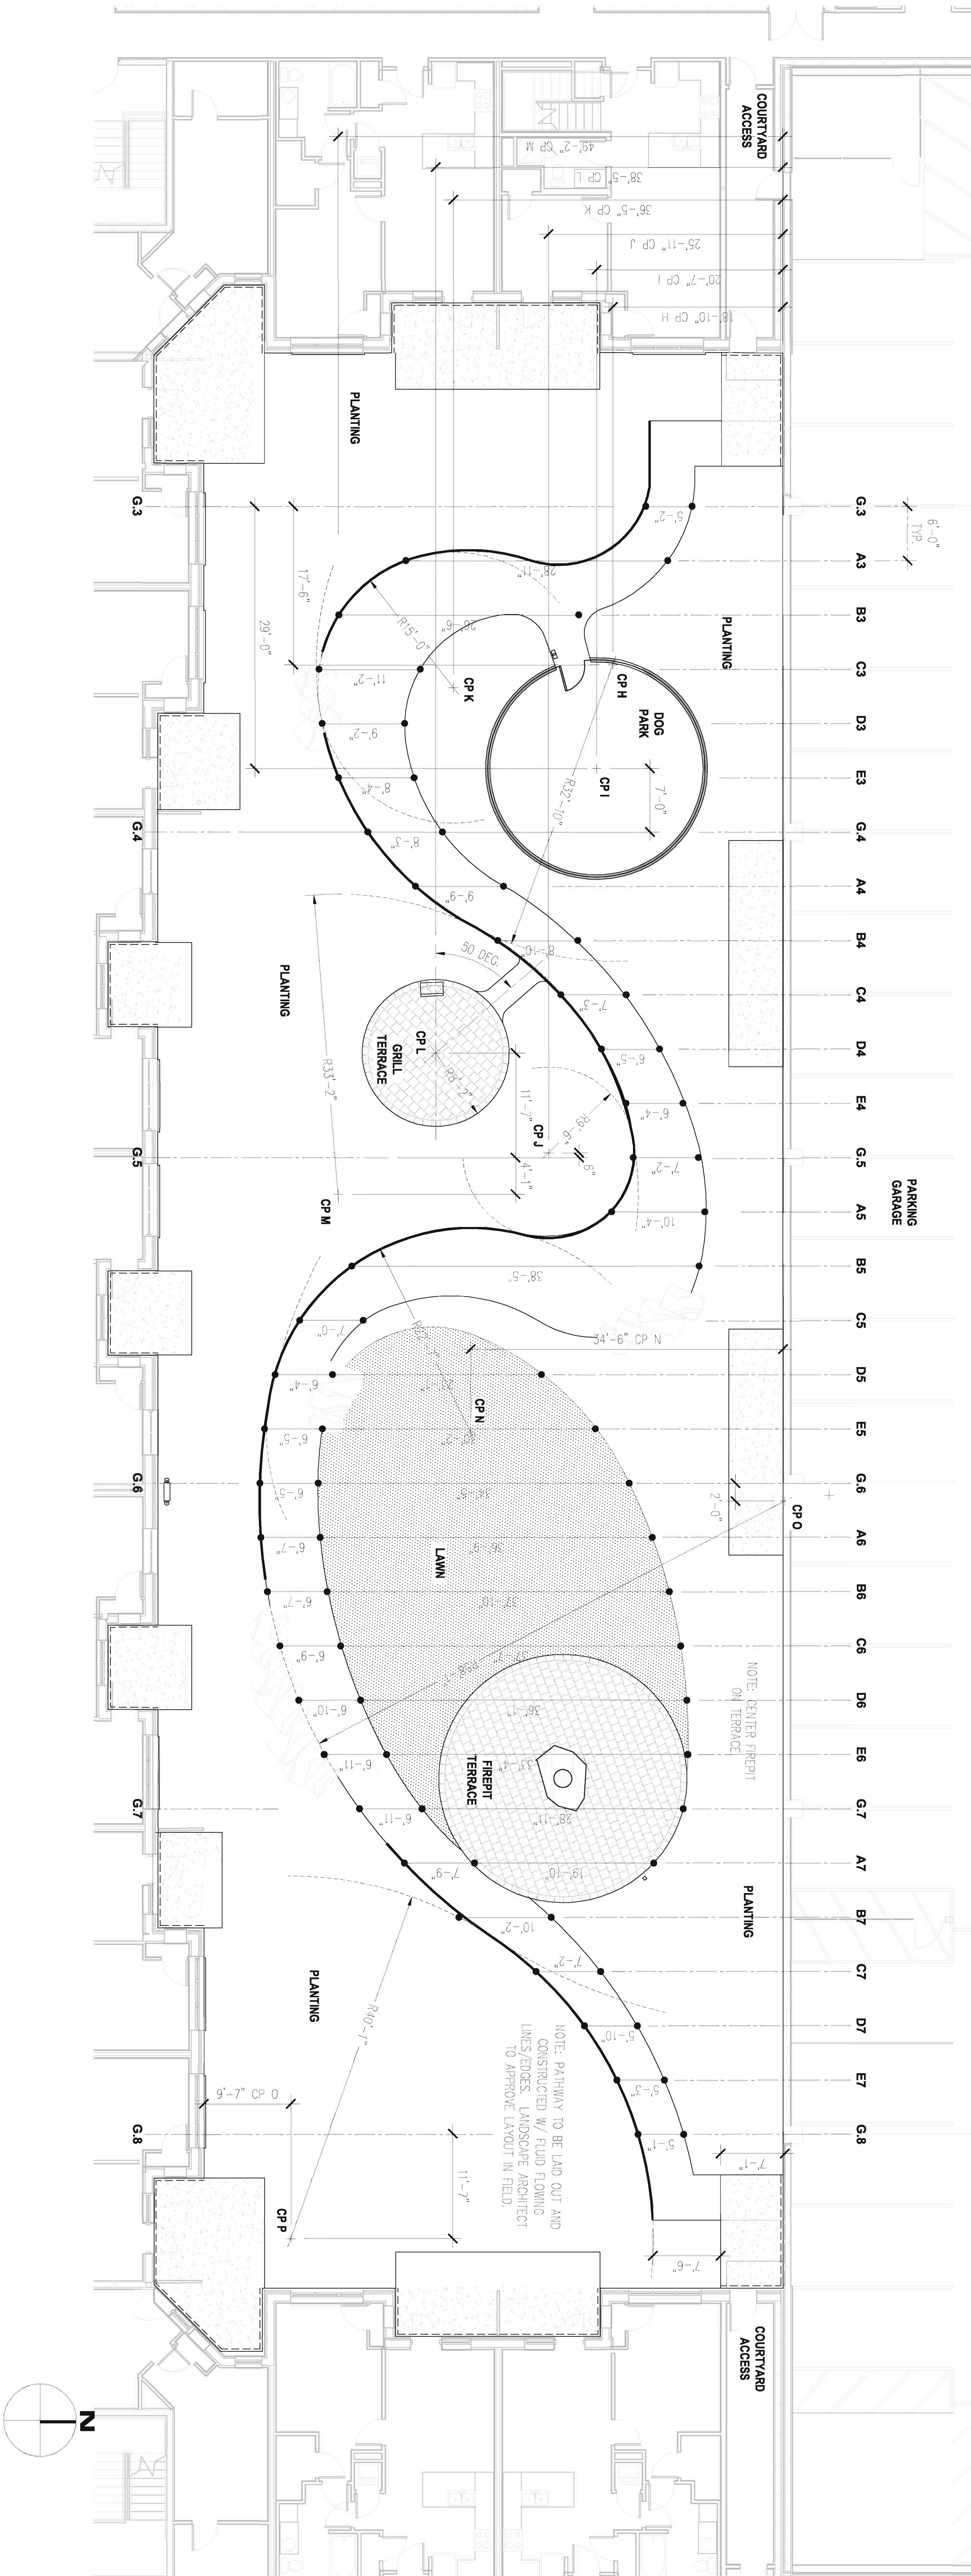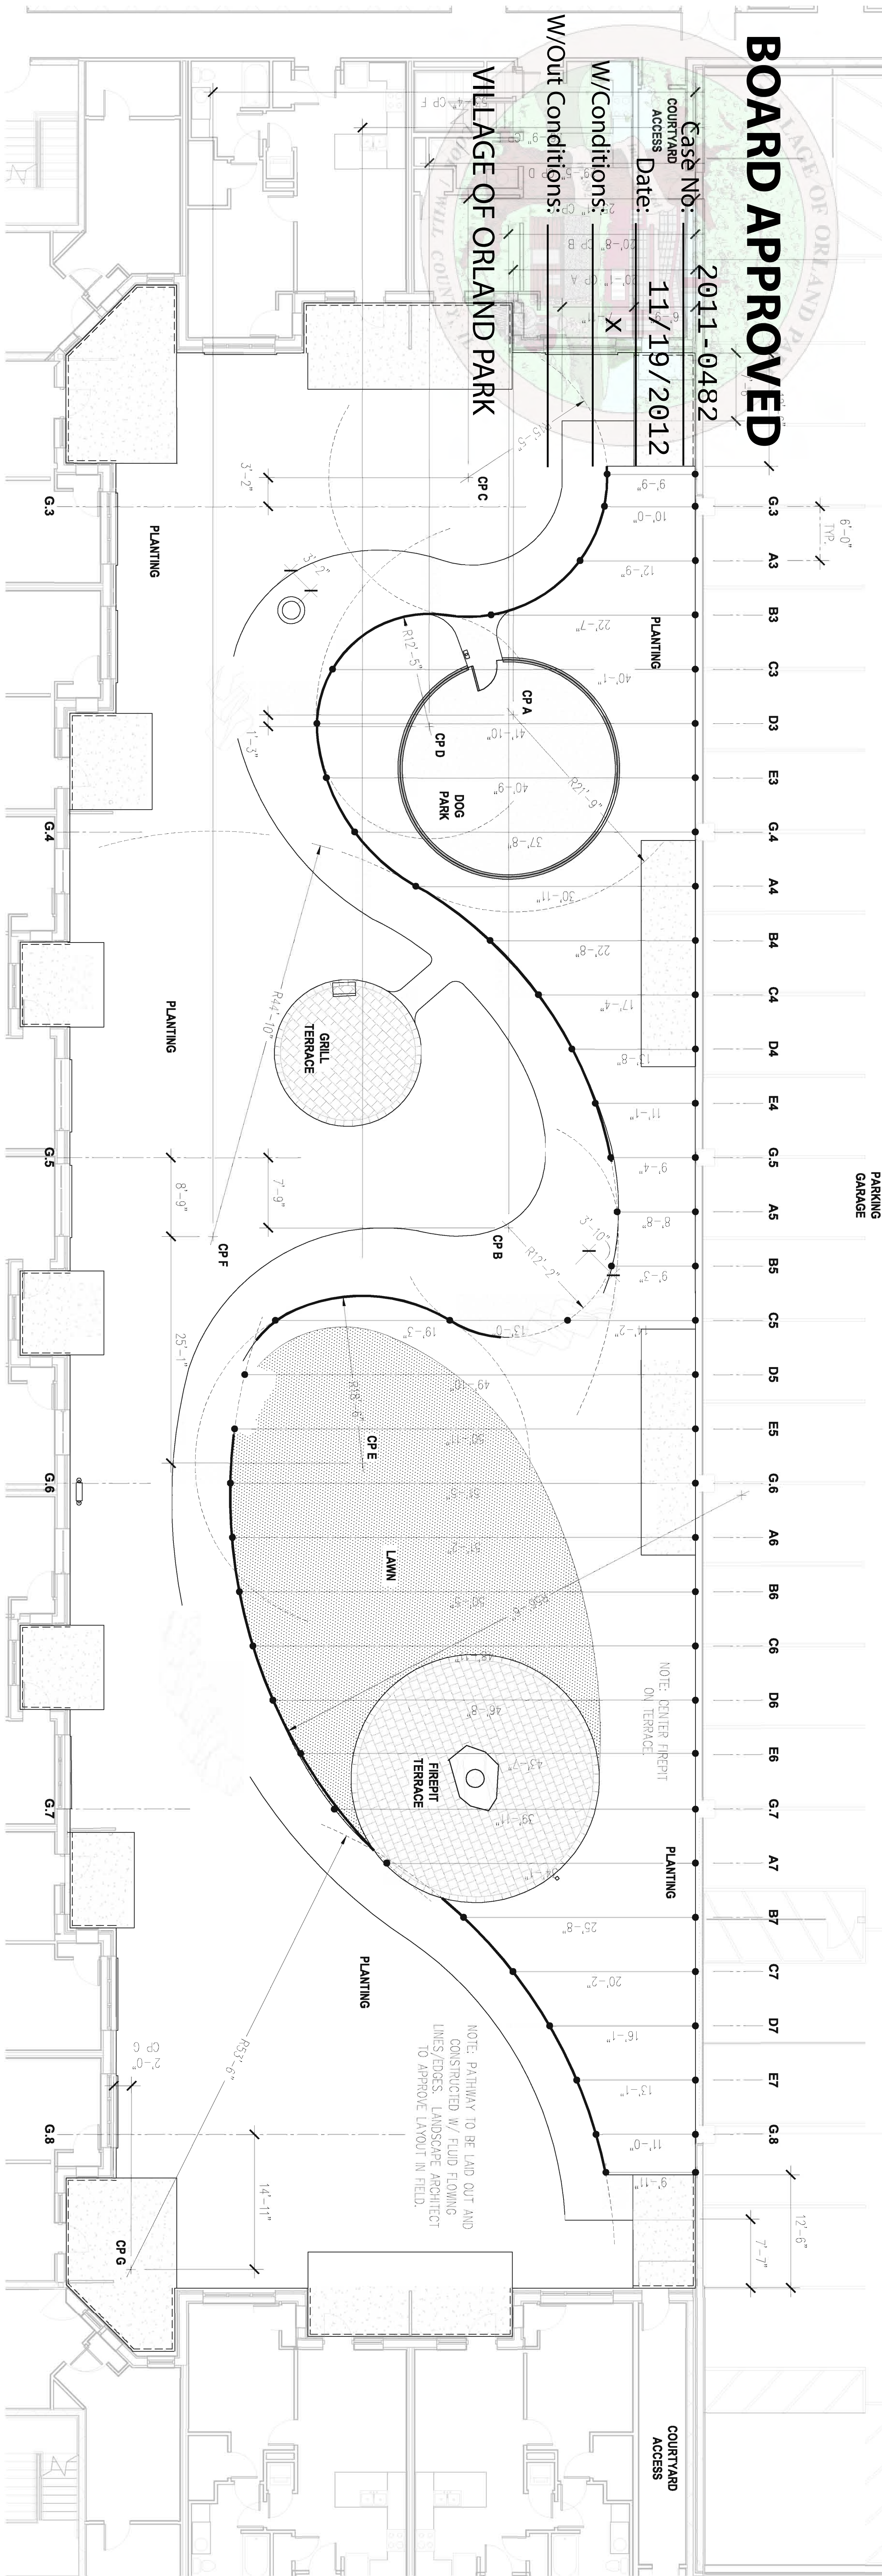

The diagram is a detailed site plan for the Village of Orland Park. It features a large building with a central entrance and two side wings. To the left of the building is a parking lot with several spaces, and to the right is a larger parking area with more spaces. The plan includes various landscaping elements such as trees, shrubs, and a central green area. A road or driveway runs along the bottom of the site. The plan is labeled with 'VILLAGE OF ORLAND PARK' at the top and 'PARKING GARAGE' at the bottom. A scale bar is located in the upper right corner, and a north arrow is in the lower right corner. The plan also includes a legend for 'PLANTING' and 'COURTYARD ACCESS'.

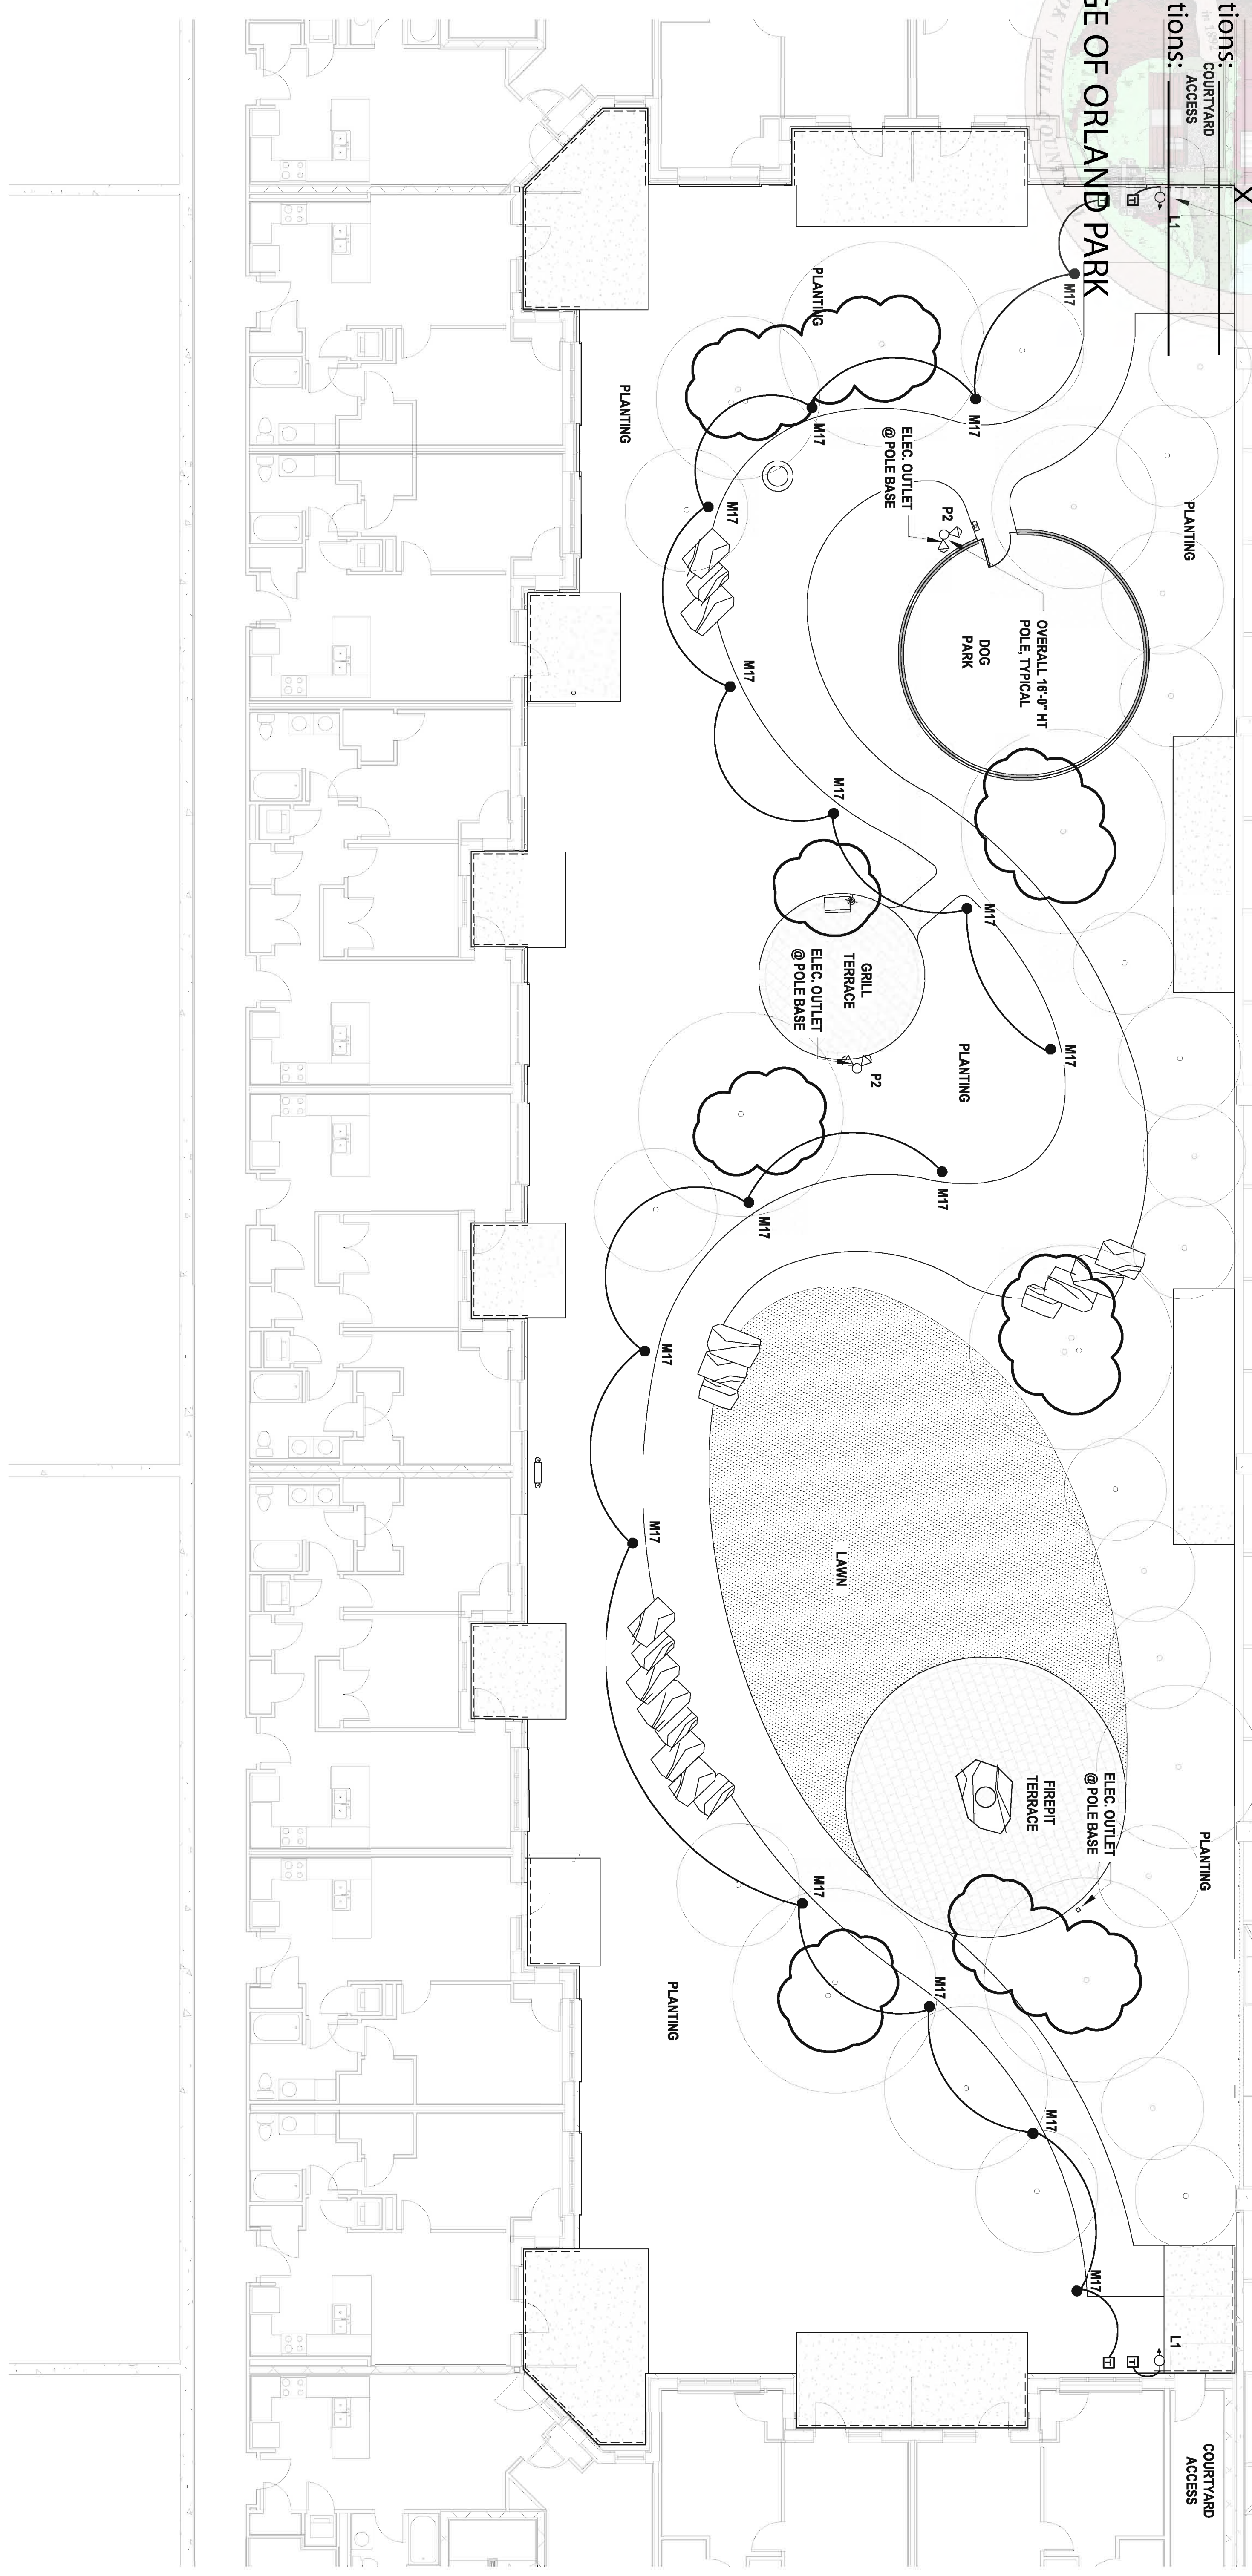

Qty	Key	Feature
P2		BATTERIE LIGHT BO-08 SERIES FOODS INDUSTRIES
L1		SU-AE-D-APR6 WALL MOUNT FOODS INDUSTRIES
L3		R10-D2 SERIES DIRECTIONAL LIGHTS FOODS INDUSTRIES
W17		AL-08-SM SERIES AREA LIGHT FOODS INDUSTRIES
W19		R10-D2 SERIES DIRECTIONAL LIGHTS FOODS INDUSTRIES
P2		(2) AOPS SERIES LUMPS PER ROUND NON-PAVEMENT STEEL POLE B-K-1 LIGHTING AND ASP
5		DIRECT BURNAL TRANSFORMER DBA SERIES FOODS INDUSTRIES

BOARD APPROVED


Case No: 2011 -0482

Date: 11/19/2012

W/Conditions: X

W/Out Conditions:

VILLAGE OF ORLAND PARK

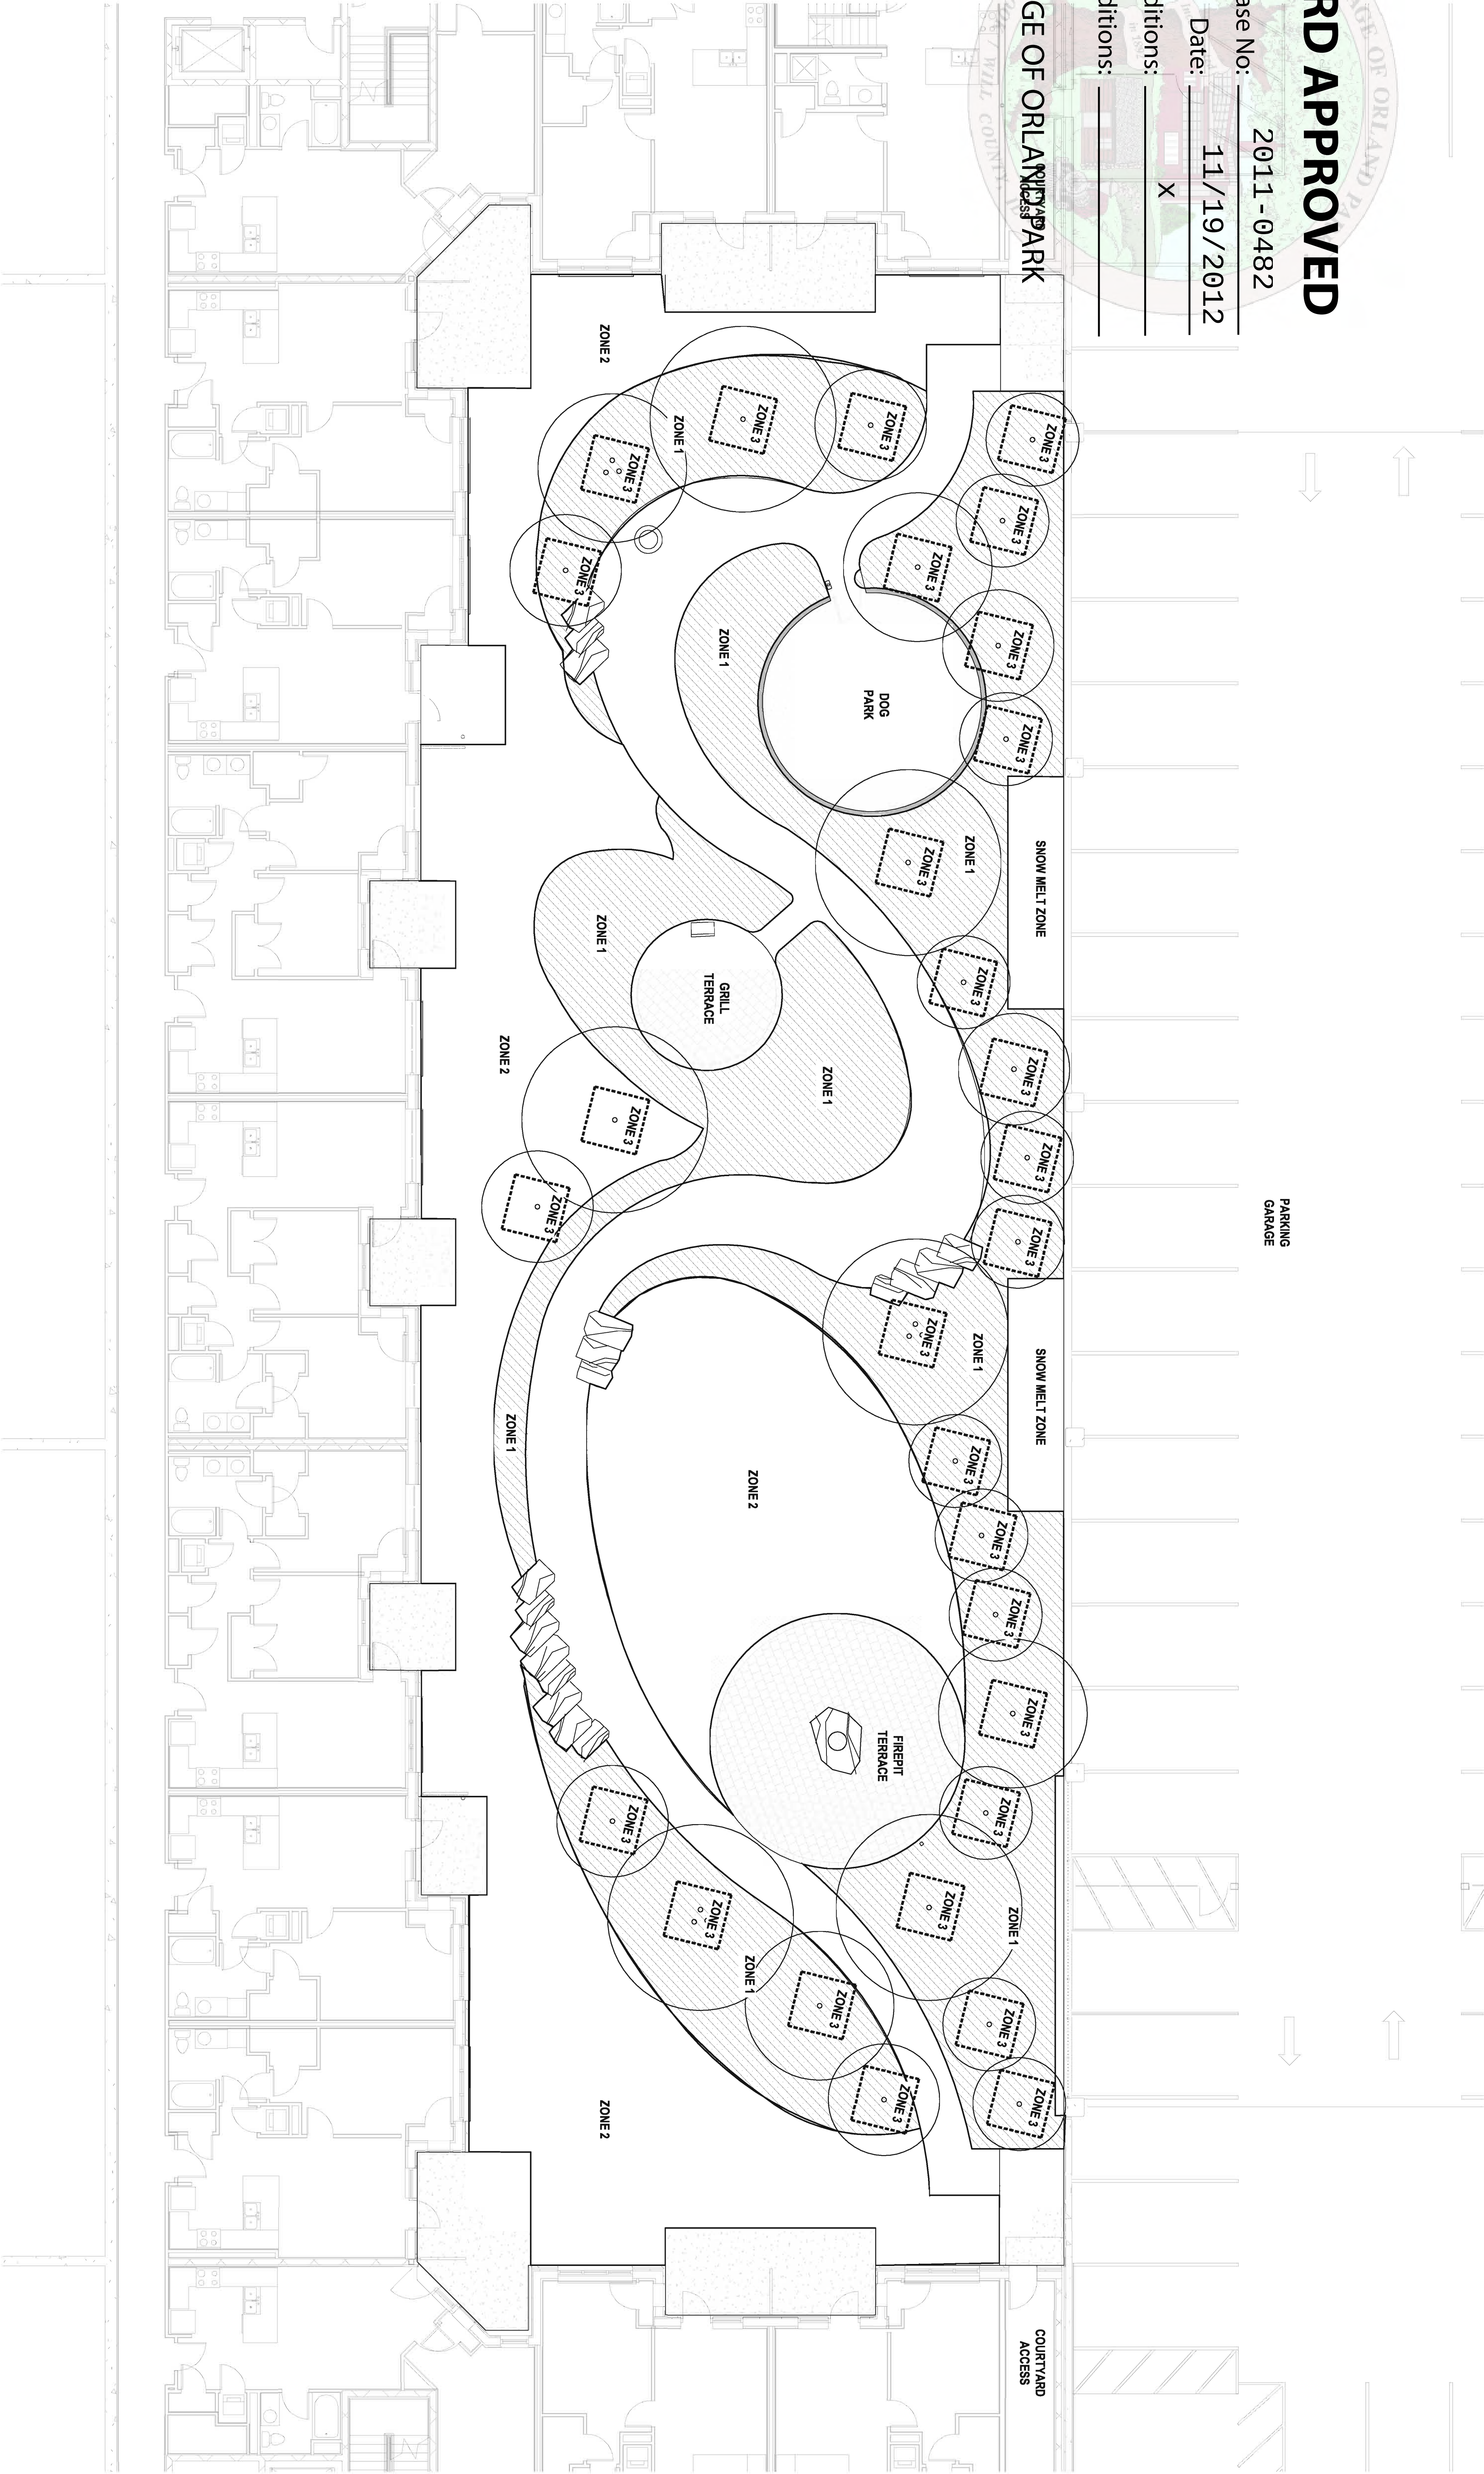

LANDSCAPE IRRIGATION GUIDELINES

- ZONE 1 - DRIP IRRIGATION ON SEPARATE VALVES
- ZONE 2 - POP UP SPRAY IRRIGATION ON SEPARATE VALVES
- ZONE 3 - POP UP FLOOD BUBBLERS - FOR TREES - ON SEPARATE VALVES

NOTES:

- THE EXTENT OF THE LANDSCAPE WILL BE WATERED USING A HIGH-EFFICIENCY AUTOMATC IRRIGATION SYSTEM OPERATED BY CONTROLLER(S). LOCATION TO BE APPROVED BY LANDSCAPE ARCHITECT.
- FLOW CONTROL WILL BE ADDRESSED BY THE USE OF A FLOW SENSOR AND MASTER VALVE. WATER USAGE WILL BE MANAGED THROUGH THE CORRECT VALVING OF ZONES 1-3 AND PROPER USE OF IRRIGATION DRIP LINES AND BUBBLERS.
- FINAL IRRIGATION DESIGN AND EQUIPMENT LOCATION TO BE APPROVED BY LANDSCAPE ARCHITECT. INCLUDING: BACKFLOW PREVENTION, IRRIGATION CONTROLLER, VALVE BOXES, RAIN SENSOR, HOSE BIBS, ETC.
- IRRIGATION CONTROLLER TO BE LOCATED IN POOL EQUIPMENT ROOM OR MECHANICAL ROOM AS APPROVED BY LANDSCAPE ARCHITECT.
- ALL VALVE BOXES TO BE LOCATED IN PLANTING AREAS AS APPROVED BY LANDSCAPE ARCHITECT.
- CONTRACTOR TO ACCOMODATE IRRIGATION LATERALS AND CONDUIT THROUGH HARDSCAPE

DESIGN COLLECTIVE

ARCHITECTURE, PLANNING, INTERIORS
WWW.DESIGNCOLLECTIVE.COM

601 EAST PRATT STREET, SUITE 300
BALTIMORE, MARYLAND 21202
T: 410.685.6655 F: 410.539.6242

312 BLACKWELL STREET, SUITE 100
DURHAM, NORTH CAROLINA 27701
T: 919.381.9322 F: 919.381.9323

DESIGN COLLECTIVE, INC. ALL RIGHTS RESERVED	DATE
ISSUED FOR PERMIT	2012.09.10
1. LANDSCAPE REVISIONS	2012.04.13
2. ISSUED FOR PERMIT	2012.04.13
3. ISSUED FOR PERMIT	2012.04.13
4. ISSUED FOR PERMIT	2012.04.13
100. ISSUED FOR PERMIT	2012.04.13

OWNER / DEVELOPER
METRA TRIANGLE FC,
LLC.

8900 KEYSTONE CROSSING
SUITE 200
INDIANAPOLIS, INDIANA 46240
PROJECT NAME
9750 ON THE PARK

PROJECT ADDRESS
DOWNTOWN ORLAND PARK,
ILLINOIS

PROJECT MANAGEMENT
DCI Project No. 678-11
Owner Project No. 678-11
Drawn by AG Checked by BR
SEAL



SHEET TITLE
POOL COURTYARD
IRRIGATION PLAN

SCALE
1/8" = 1'-0"

SHEET NUMBER

L206

BOARD APPROVED

Sealing Pattern
S.E. 101/201 FOR FINISH

Case No: 2011-0482

Date: 11/19/2012

W/Conditions:

W/Out Conditions:

VILLAGE OF ORLAND PARK

EXPANSION JOINT, SEE DETAIL 3.1.301

4" CONCRETE, SEE 110/1201 FOR FINISH

1/2" WIDE CONTRACTION JOINT, SANDWICH 1/2" WIDE X 1/2" DEPTH OF CONCRETE

43 REBAR @ 18" OC, EACH WAY, STOP REBAR 3" FROM EDGE OF CONCRETE SECTION

4" GRADED AGGREGATE BASE (COMPACT TO 95%)

TOP OF COMPACTED SUBGRADE (COMPACT TO 95%)

1
CONCRETE
1" = 1'-0"

CONCRETE
1" = 1'-0"

CONCRETE
1" = 1'-0"

3'-6"

2'-6"

Case No: 2011 - 0482

Date: 11/19/2012

W/Conditions: X

W/Out Conditions:

TURNED DOWN REINFORCED CONCRETE SLAB, PER STRUCTURAL DRAWINGS

STAINLESS STEEL GAS GRILL WITH POST MODULE ORIENT AS SHOWN ON SHEET L101

SEAL OF THE VILLAGE OF ORLAND PARK

2011 - 0482

11/19/2012

X

W/Conditions: X

W/Out Conditions:

Case No: 2011 - 0482


Date: 11/19/2012

W/Conditions: X

W/Out Conditions:




TURNED DOWN REINFORCED CONCRETE SLAB, PER STRUCTURAL DRAWINGS

STAINLESS STEEL GAS GRILL WITH POST MODULE ORIENT AS SHOWN ON SHEET L101

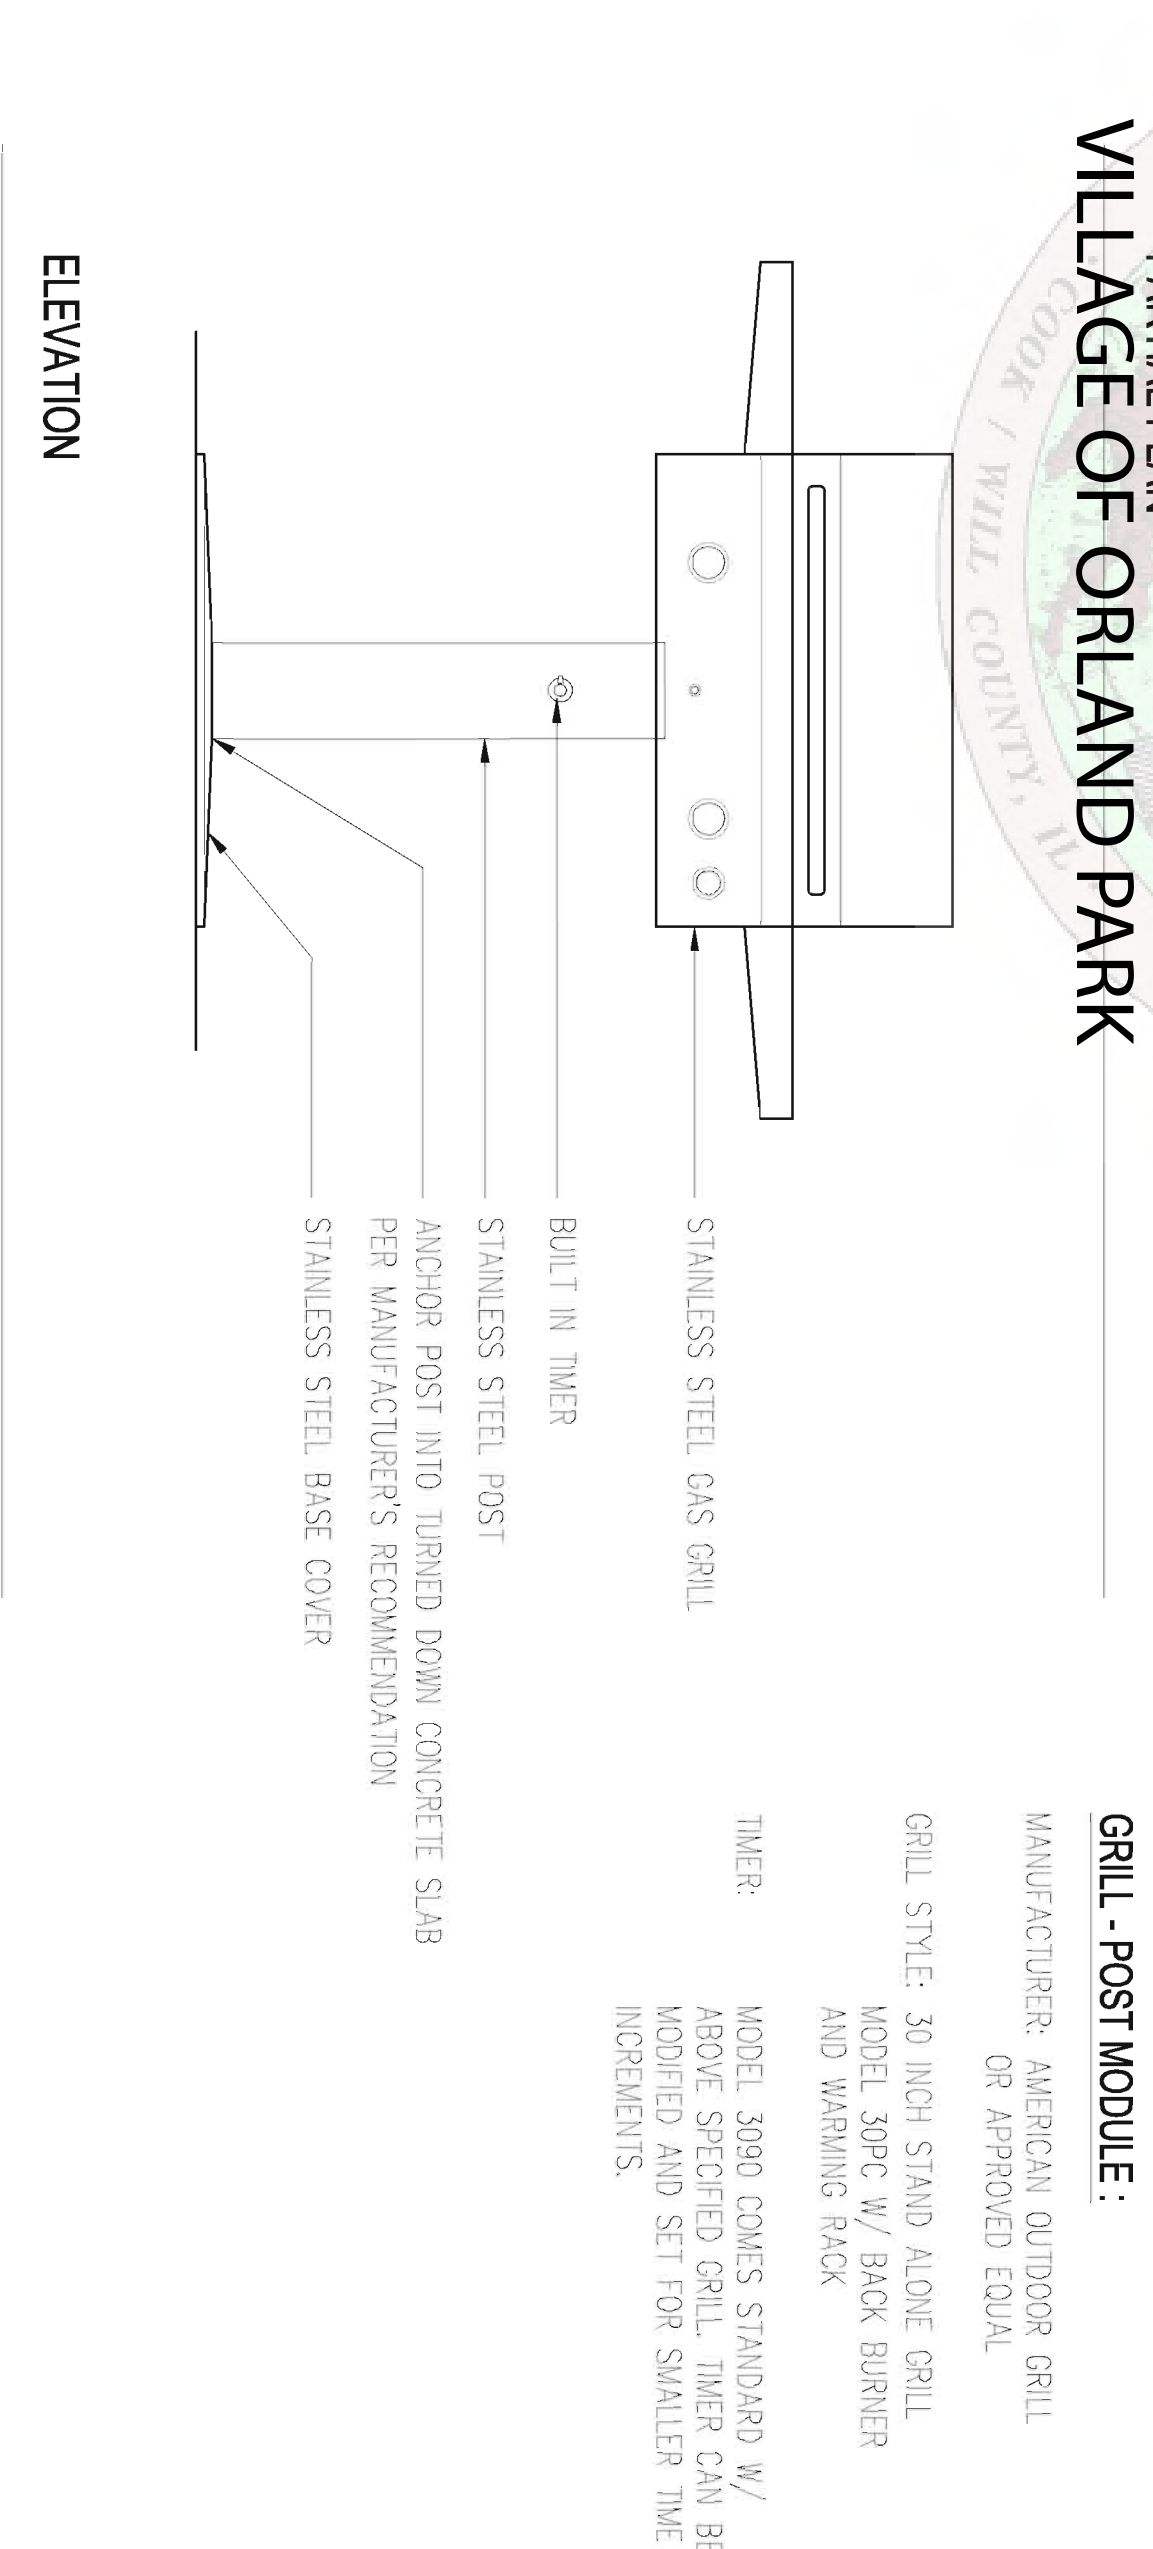

1 GRILL STATION – TYPE B
1" = 1'-0"


3 CLUBROOM TERRACE – PAVING ENLARGEMENT
1/2" = 1'-0"

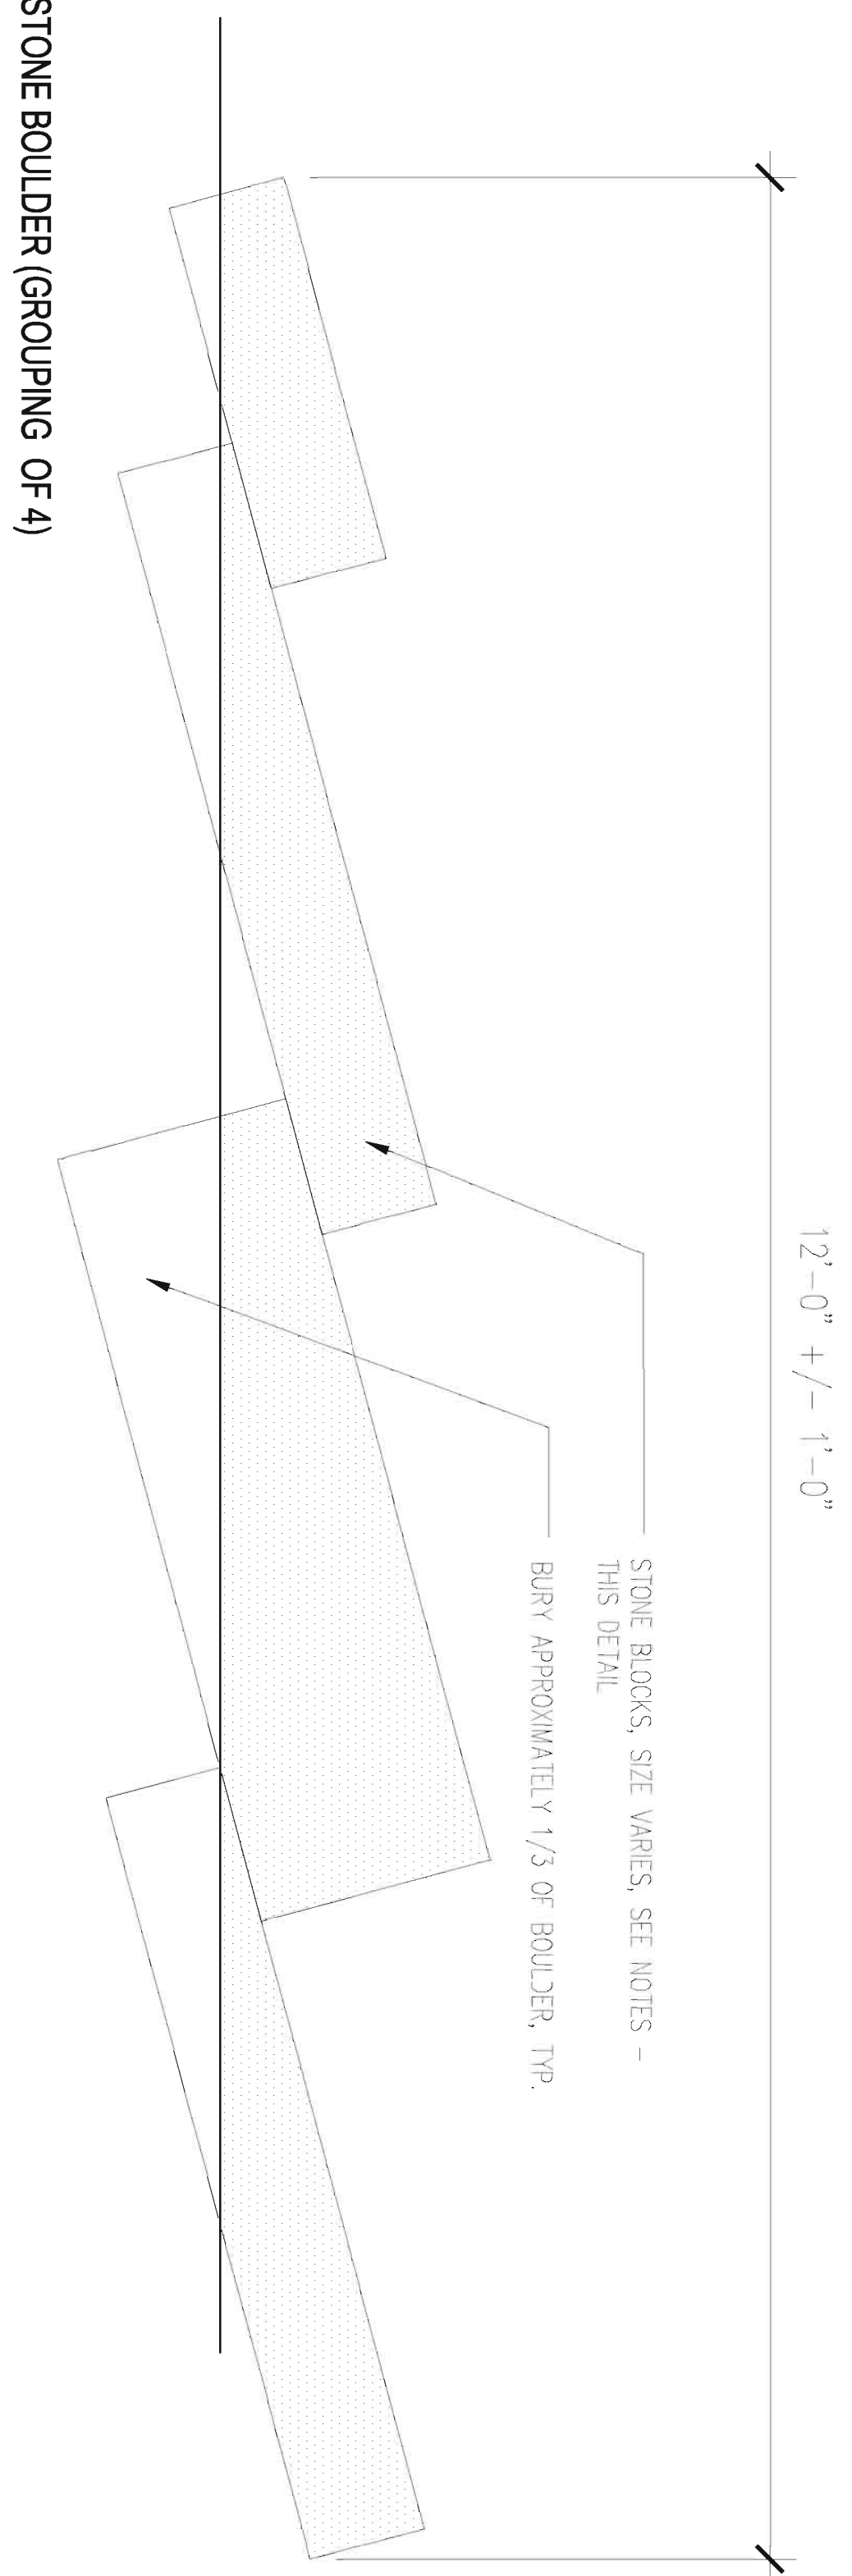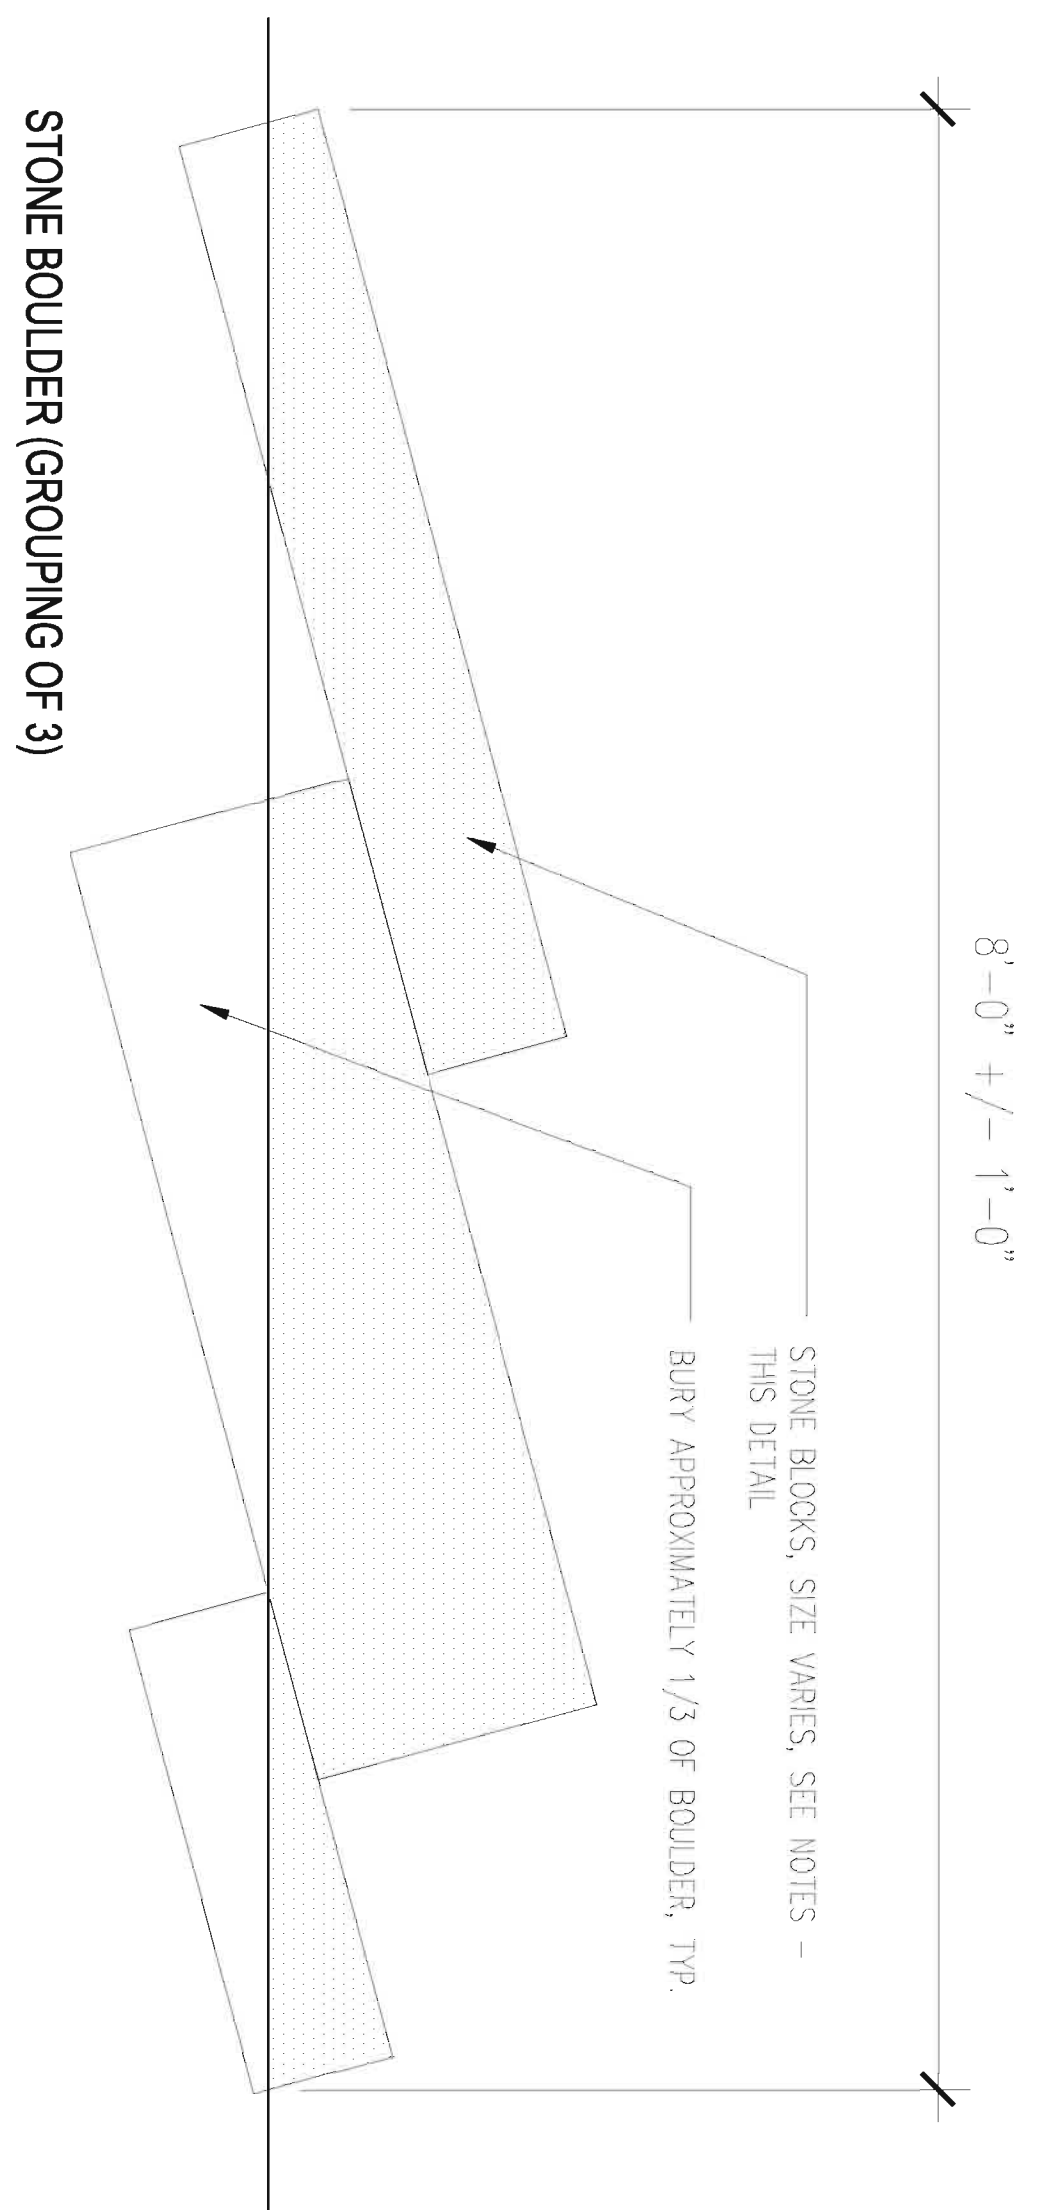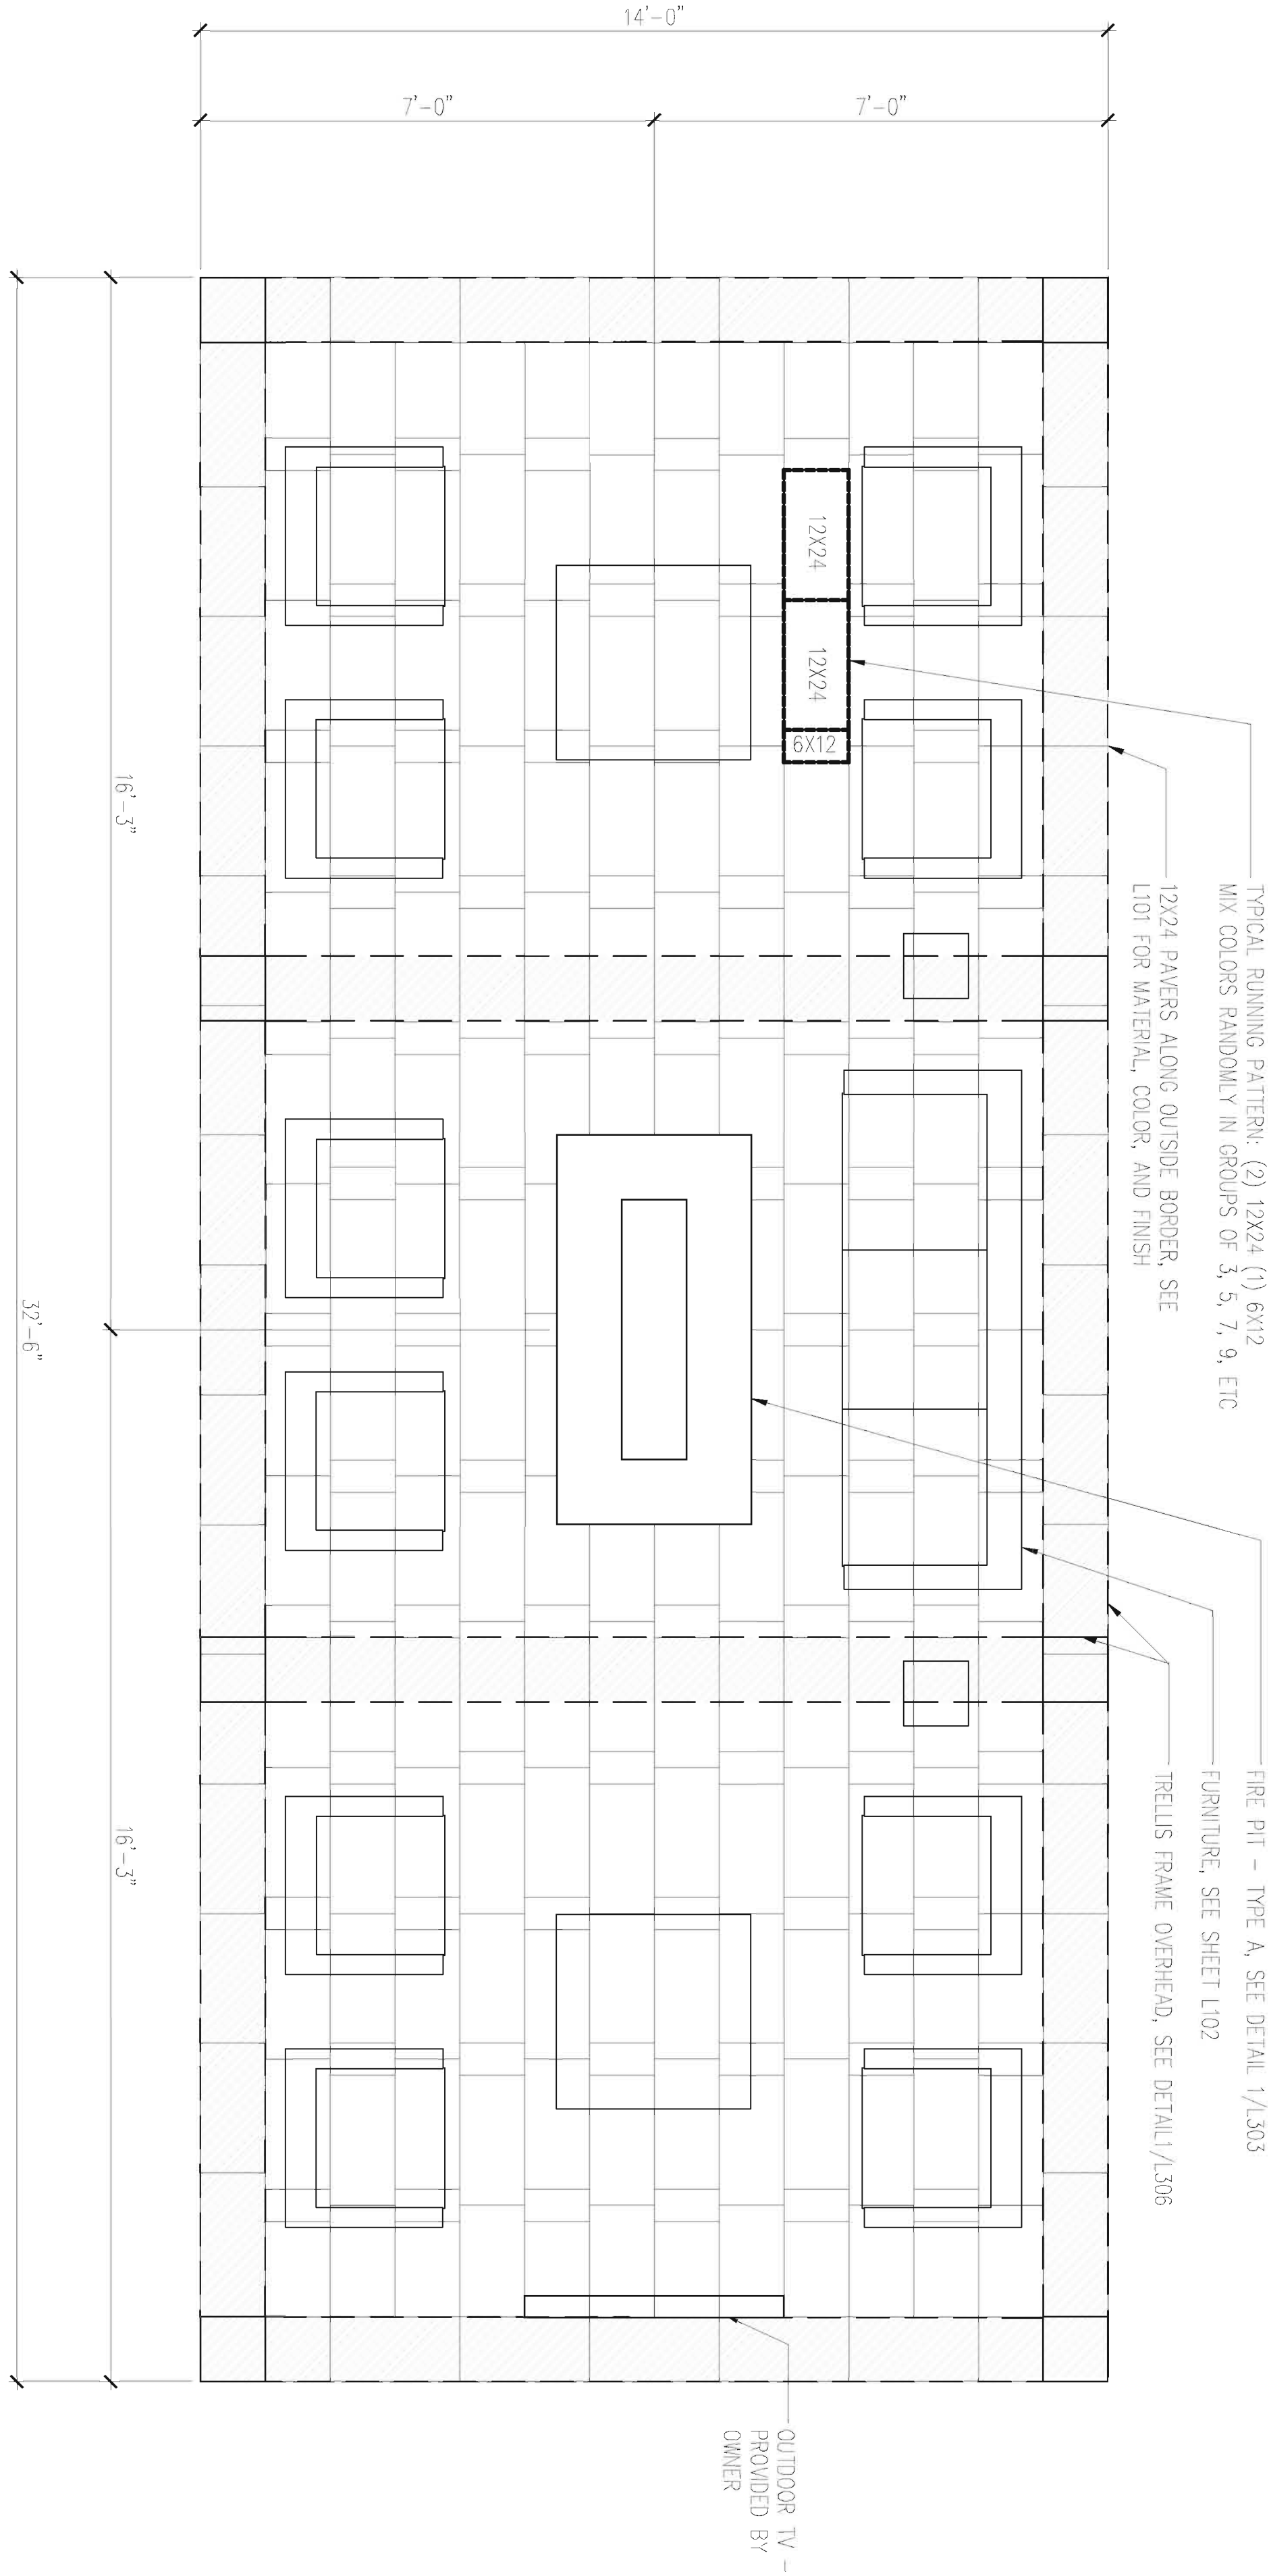


STONE BOULDER OUTCROPPING:

QUARRY: HAUOLIST
STONE TYPE: LANNON WEATHERED OUTCROPPING OR APPROVED EQUAL
SIZES: LATERAL DIMENSION – 3'-5" WITH 3" MAX FRONT TO BACK
THICKNESS – (80%) 4"-18" (20%) 12"-20"

NOTE:
– BOULDER TO BE PLACED BY STRIPS OR CABLES WITH CARPET TO PREVENT SCARRING. BOULDERS WITH EXCESSIVE SCARRING WILL BE REJECTED.
– LANDSCAPE ARCHITECT TO APPROVE FINAL STONE LAYOUT
– GROUPING ELEVATIONS FOR DIAGRAMMATIC PURPOSES ONLY

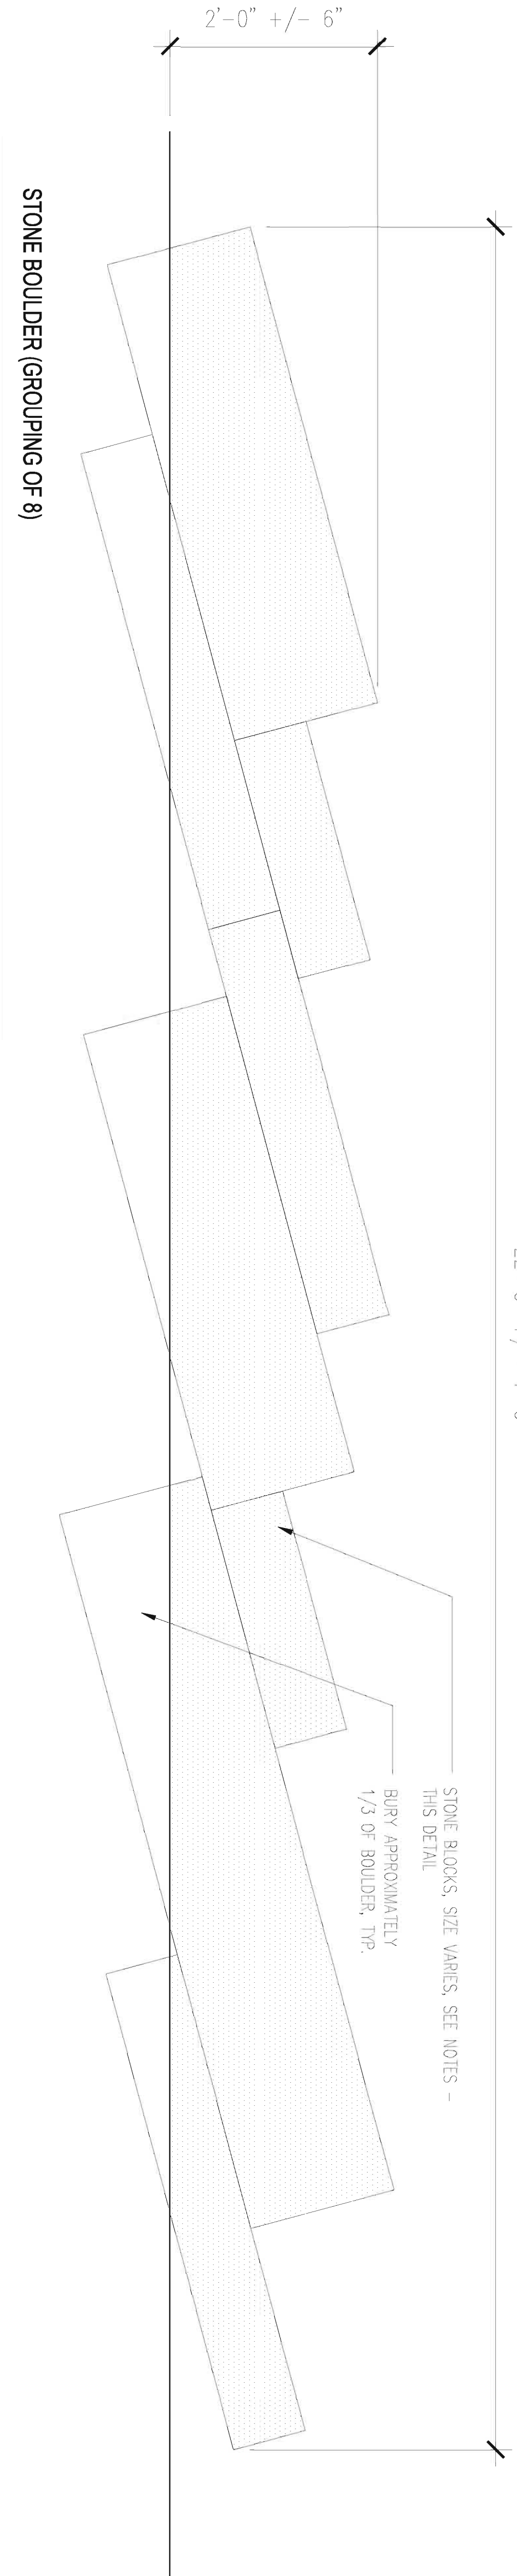

2 BOULDER OUTCROPPING
1" = 1'-0"

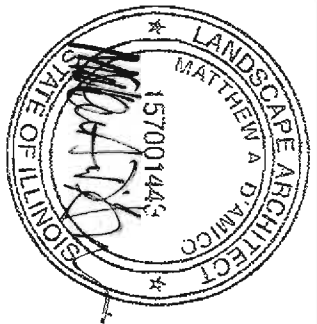

BOARD APPROVED

Case No: 2011 - 0482


Date: 11/19/2012

W/Conditions: X

W/Out Conditions:

VILLAGE OF ORLAND PARK

Seal of the Village of Orland Park, Illinois

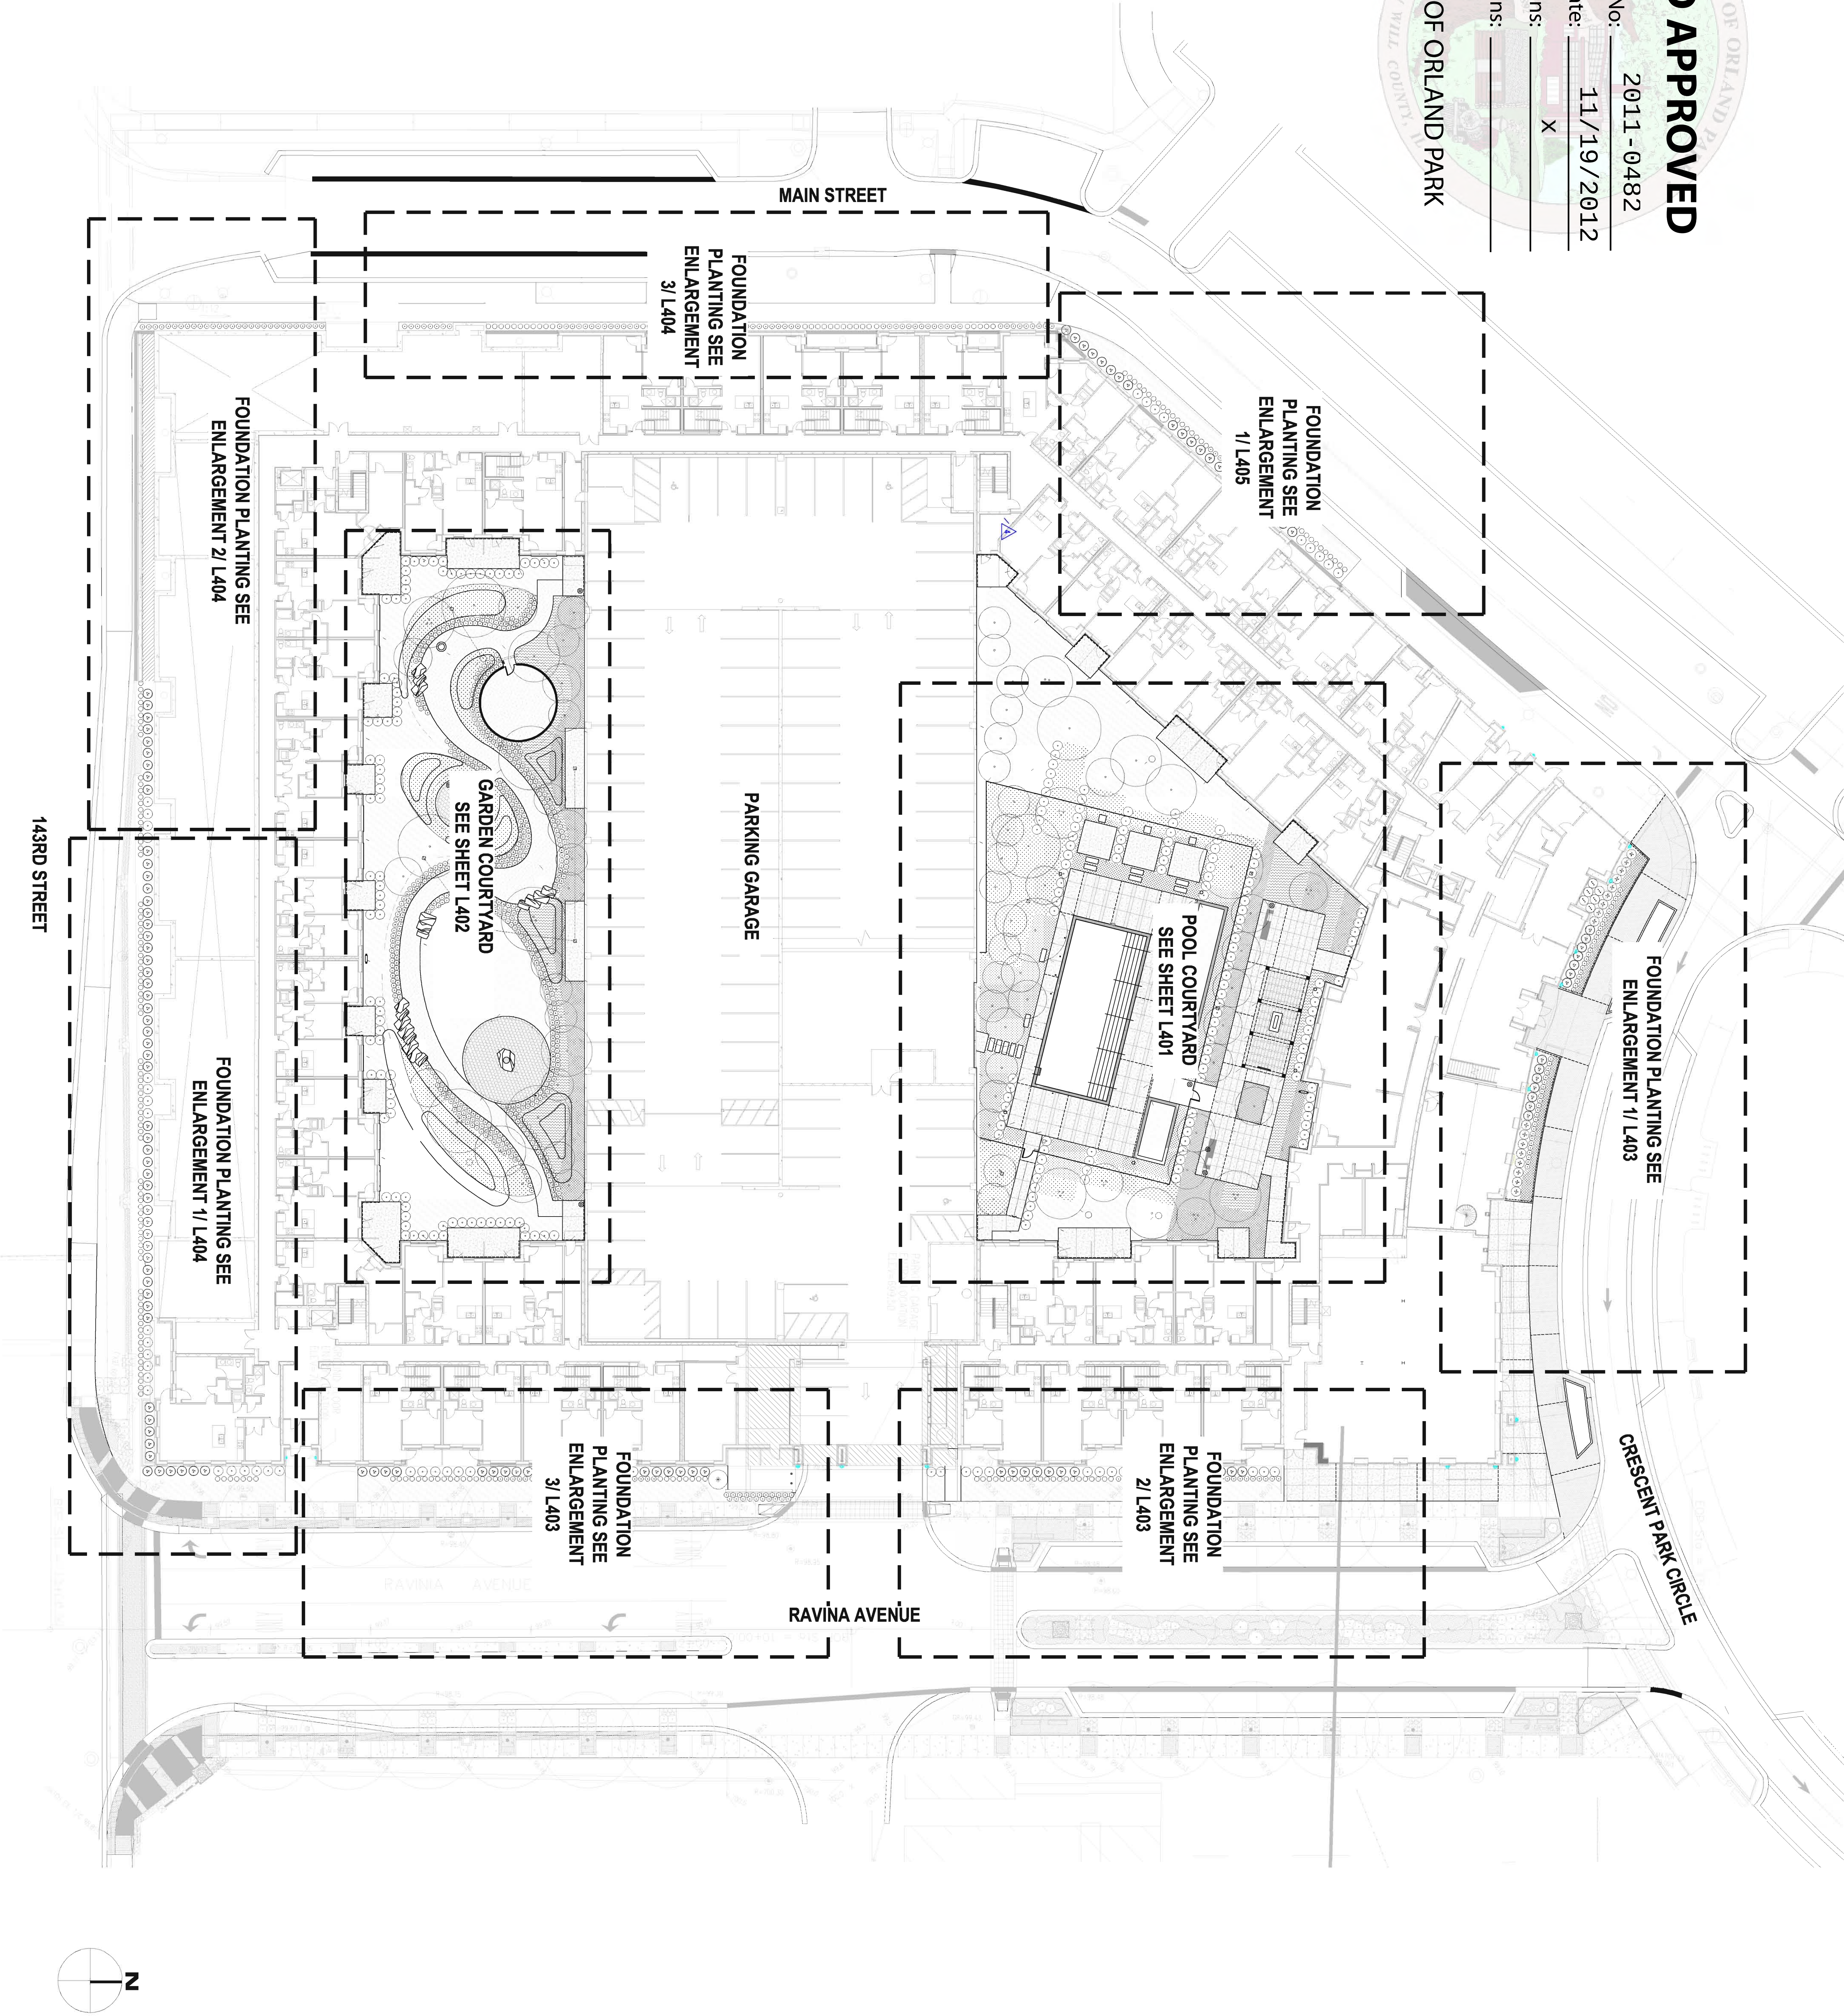

BOARD APPROVED


Case No. 2011 - 0482

Date: 11/19/2012

W/Conditions: X

W/Out Conditions:

VILLAGE OF ORLAND PARK

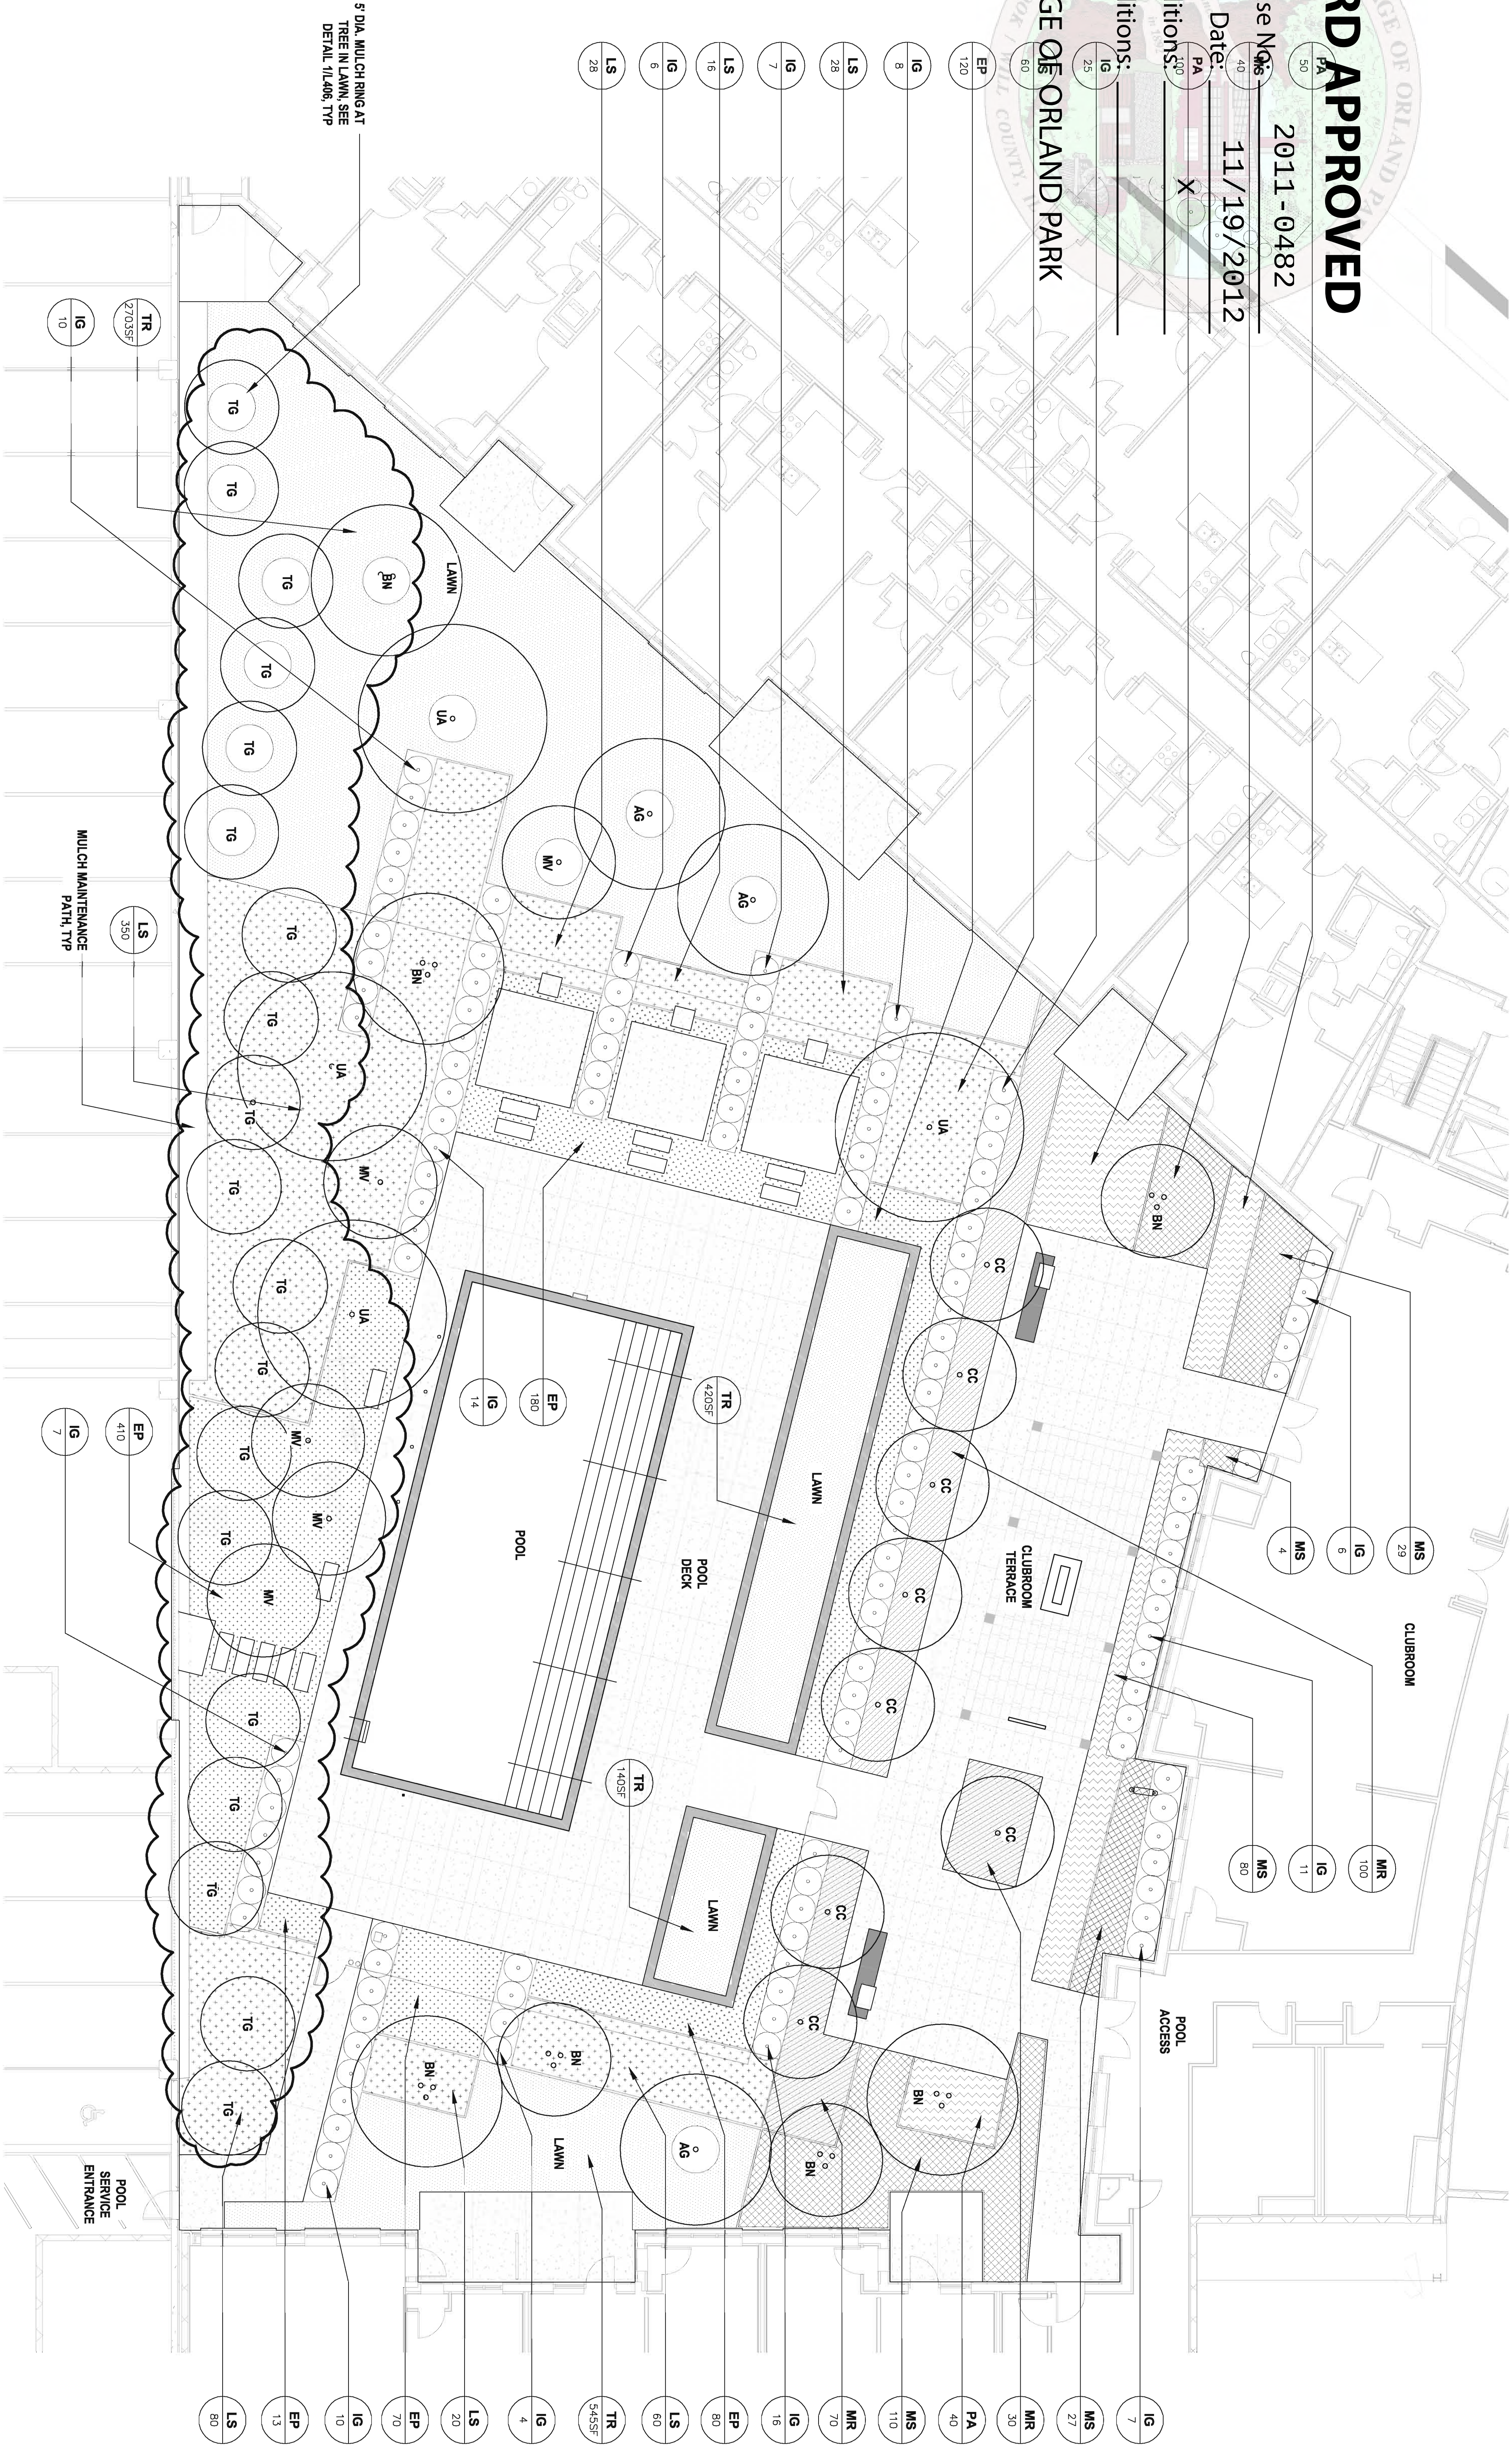

PLANT LIST - THIS SHEET

TREES

Qty.	Key	Botanical/Common Name	Size	Root	Comments
3	AG	Acer griseum	8' Ht.	B&B	
		Paperbark Maple			
5	BN	Betula nigra	8'-12' Ht.	B&B	(2) 8'Ht. (3) 12' Ht.
		Riverbirch			
9	CC	Cercis canadensis	12' Ht.	B&B	Standard
		Eastern Redbud			
5	WV	Magnolia virginiana	8' Ht.	B&B	
		Sweet Bay Magnolia			
19	TG	Thuja 'Green Giant'	6' Ht.		
		Arborvitae			
4	UA	Ulmus americana 'Princeton'	10' Ht.	B&B	
		Princeton Elm			

UNDERPLANTING

Qty.	Key	Botanical/Common Name	Size	Comments
1655 SF	EP	50% Echinacea purpurea	Quart @ 18" OC	Alternate every other species
		50% Miscanthus 'Little Kitten'		In planting bed - Qty:425 each
123	IG	Ilex glabra 'Chametz'	24" Ht.	
		Norfolk Island Holly		
2166 SF	LS	50% Liriodendron tulipifera	quart @ 24" OC	Alternate every other species
		50% Muhlenbergia rigens		In planting bed - Qty:315 each
200	MS	Miscanthus sinensis 'Purpureus'	Quart @ 24" OC	
		Purple Silver Grass		
180	MR	Muhlenbergia rigens	Quart @ 24" OC	
		Deer Grass		
270	PA	Pennisetum alopecuroides 'Hemmi'	Quart @ 12" OC	
		Dwarf Fountain Grass		
3807 SF	TR	Turf (Sod)	SOD	Hardy to Zone 5
		Low Growing Fescue		

DESIGN COLLECTIVE

ARCHITECTURE, PLANNING, INTERIORS
WWW.DESIGNCOLLECTIVE.COM

601 EAST PRATT STREET, SUITE 300
BALTIMORE, MARYLAND 21202
T: 410.685.6655 F: 410.539.6242

312 BLACKWELL STREET, SUITE 100
DURHAM, NORTH CAROLINA 27701
T: 919.381.9322 F: 919.381.9323

OWNER / DEVELOPER
METRA TRIANGLE FC, LLC.
8900 KEYSTONE CROSSING
SUITE 200
INDIANAPOLIS, INDIANA 46240
PROJECT NAME
9750 ON THE PARK

PROJECT ADDRESS
DOWNTOWN ORLAND PARK,
ILLINOIS

PROJECT MANAGEMENT
DCI Project No. 678-11
Owner Project No. ---
Drawn by AG Checked by BR
SCALE

PROJECT TITLE
POOL COURTYARD
PLANTING PLAN

157091445

157091445


SCALE
1/8" = 1'-0"

SHEET NUMBER
L401

Date: 11/19/2012

COURTYARD
ACCESS

VILLAGE OF ORLAND PARK

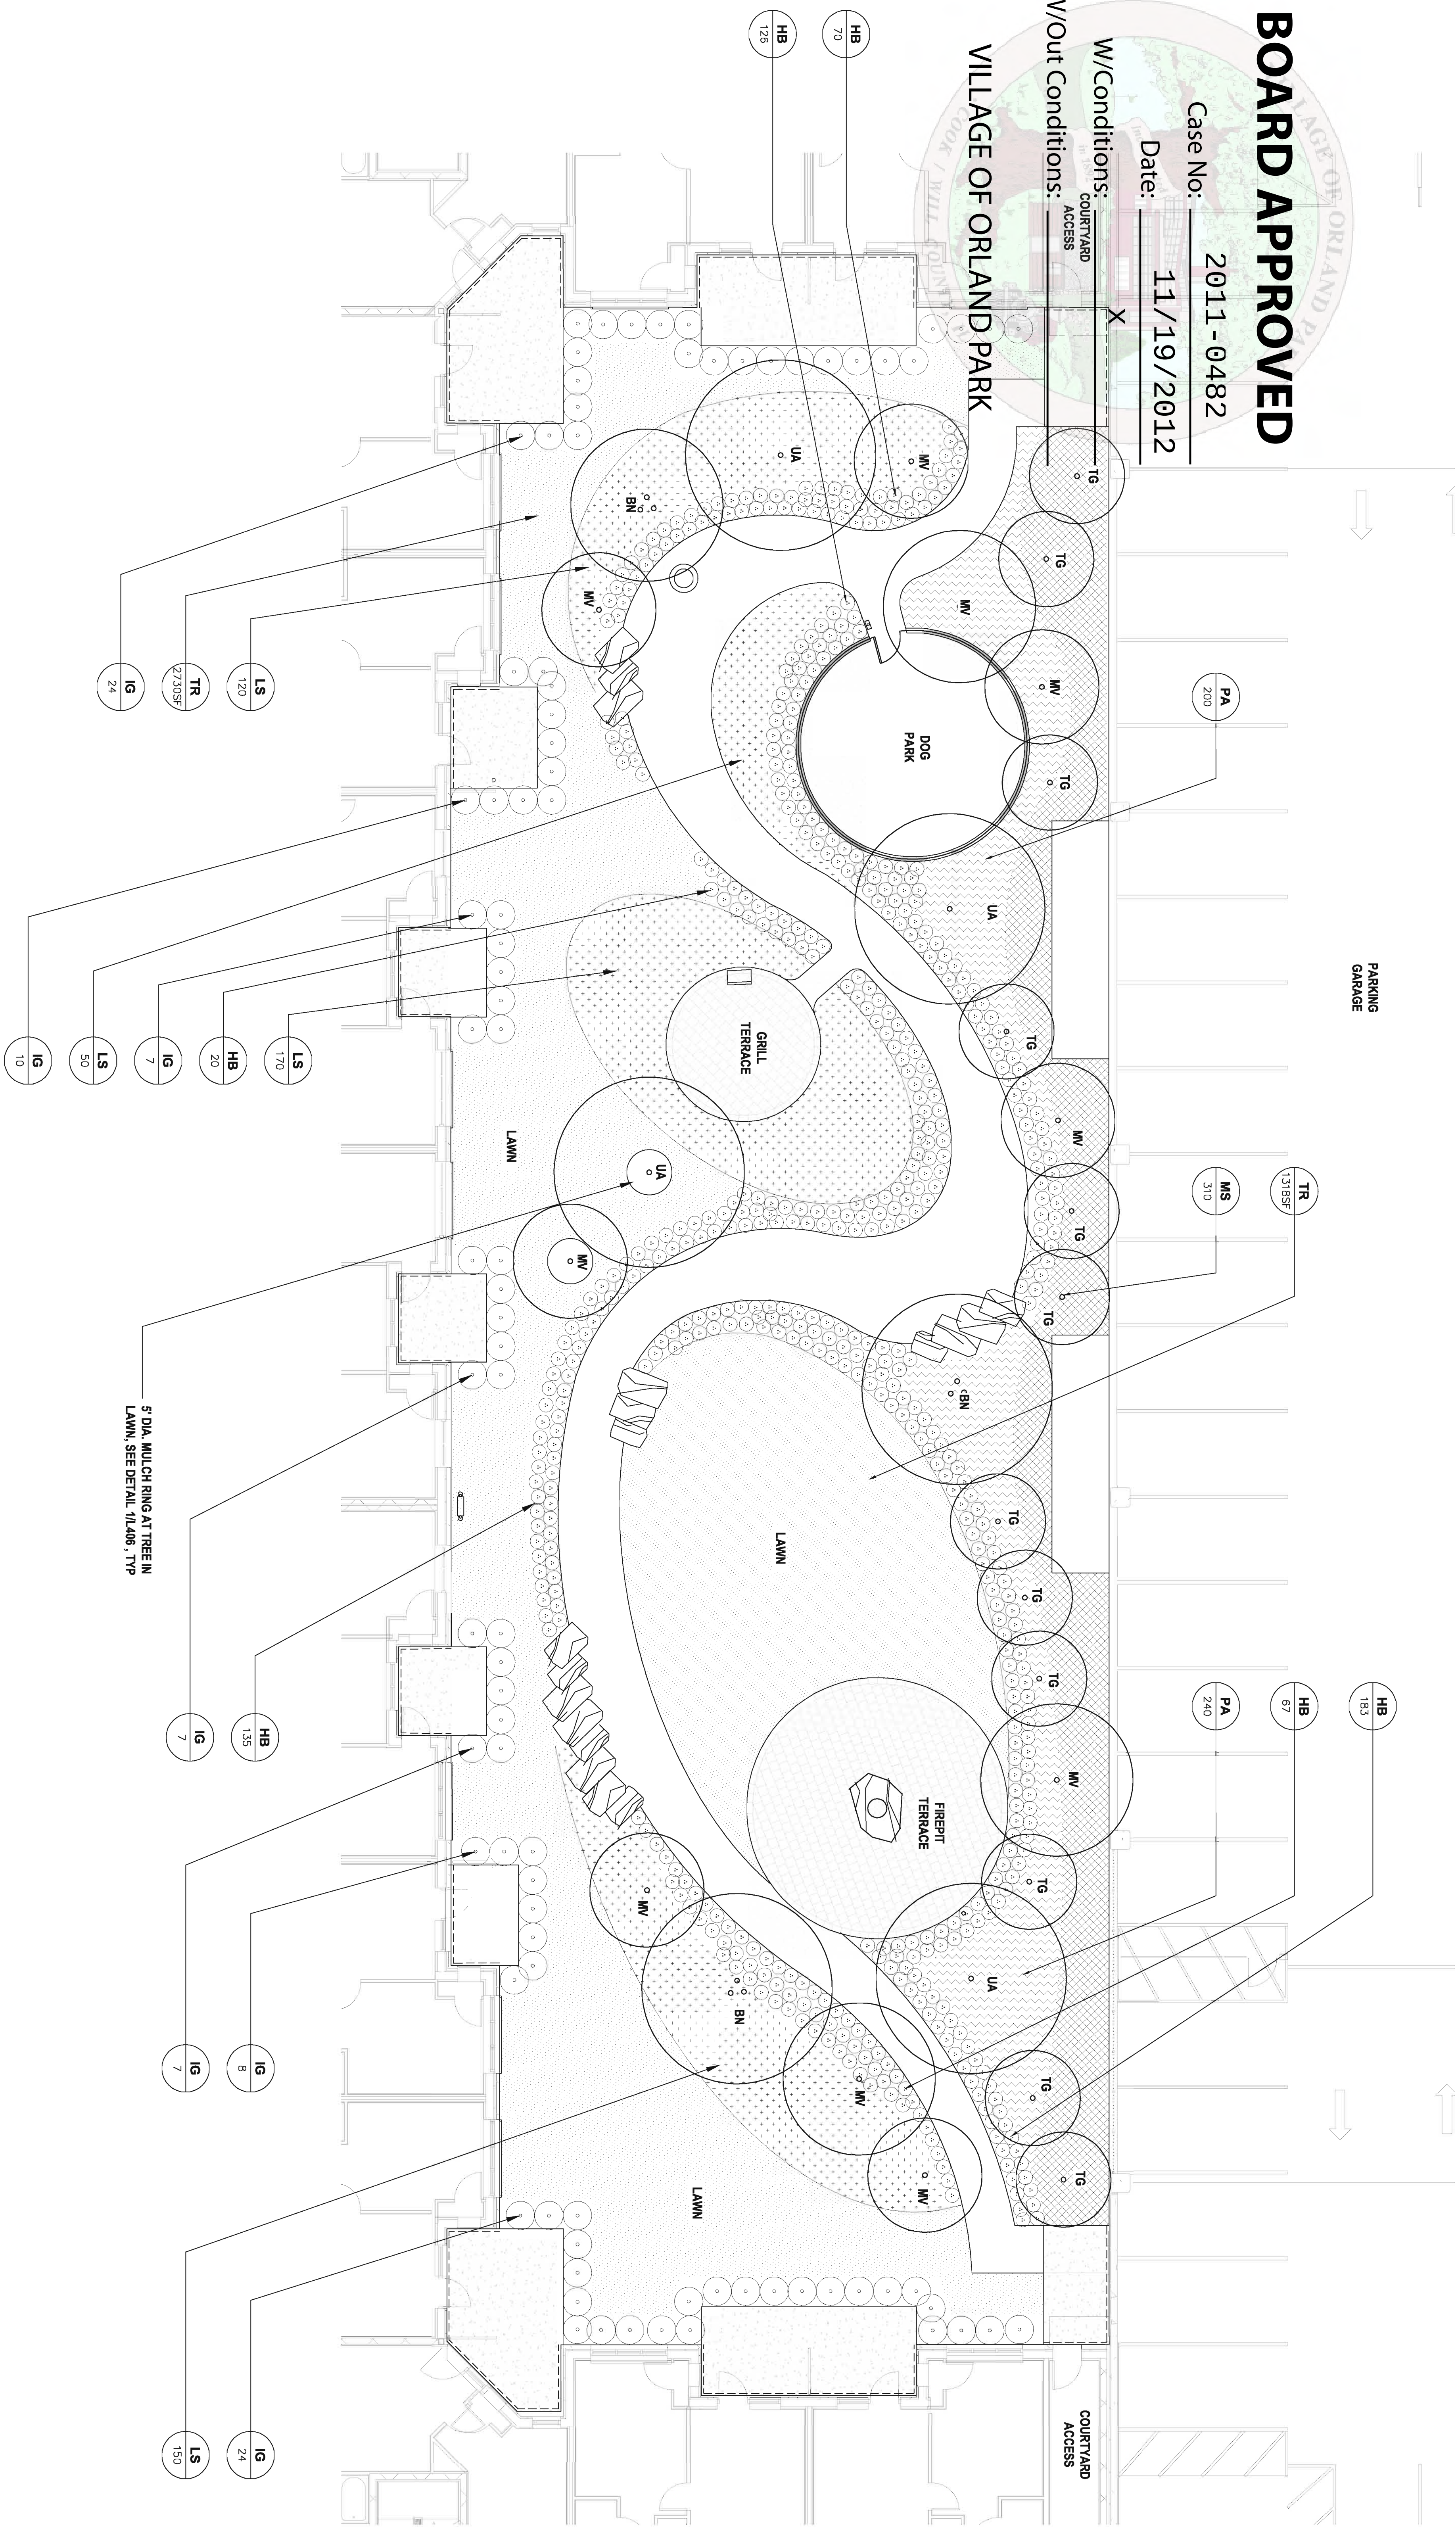


TREES

Qty.	Key	Botanical/Common Name	Size	Root	Comments
3	BN	<i>Betula nigra</i> Riverbirch	8'-12' Ht.	B&B	(1) 8' Ht. (2) 12' Ht.
10	MV	<i>Magnolia virginiana</i> Sweet Bay Magnolia	8'-10' Ht.	B&B	(5) 8' Ht. (4) 10' Ht.
12	TG	<i>Thuja Green Giant</i> [†] Abovitoe	6' Ht.		
4	UA	<i>Pinus americana</i> 'Princeton' Princeton Elm	12' Ht.	B&B	

Qty.	Key	Botanical/Common Name	Size	Comments
------	-----	-----------------------	------	----------

611	H8	<i>Heisterichia sempervirens</i>	Quart	
		Blue Oak Grass		
88	IG	<i>Ilex glabra</i> "Chenault"	24" Ht.	
		Norfolk Inkberry Holly		
1634 SF	LS	50% <i>Ilex</i> spicata	Quart @ 24" OC	
		50% Muhlenbergia rigens		
310	MS	<i>Miscanthus sinensis</i> "Purpureus"	Quart @ 24" OC	Attend to every other species in planting bed – Qty:240 each
		Purple Silver Grass		
540	PA	<i>Pennisetum alopecuroides</i> "Hameln"	Quart @ 18" OC	
		Dwarf Fountain Grass		
4048 SF	TR	Turf (Soil)	SOD	Hardy to Zone 5
		Low Growing Rescue		

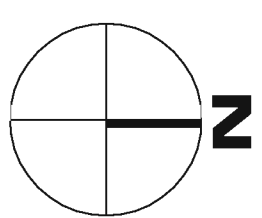

312 BLACKWELL STREET, SUITE 100
DURHAM, NORTH CAROLINA 27701
T: 919.381.9322 F: 919.381.9323

[illegible]

**8900 KEYSTONE CROSSING
SUITE 200
INDIANAPOLIS, INDIANA 46240
PROJECT NAME
9750 ON THE PARK**

PROJECT MANAGEMENT

DCI Project No. 678-11

Owner Project No. ----

Drawn by AG Checked by BR

SEAL



BOARD APPROVED

Case No: 2011 -0482


Date: 11/19/2012

W/Conditions: X


W/Out Conditions:

VILLAGE OF ORLAND PARK


1 FOUNDATION PLANTING ENLARGEMENT
1/8"=1'-0"

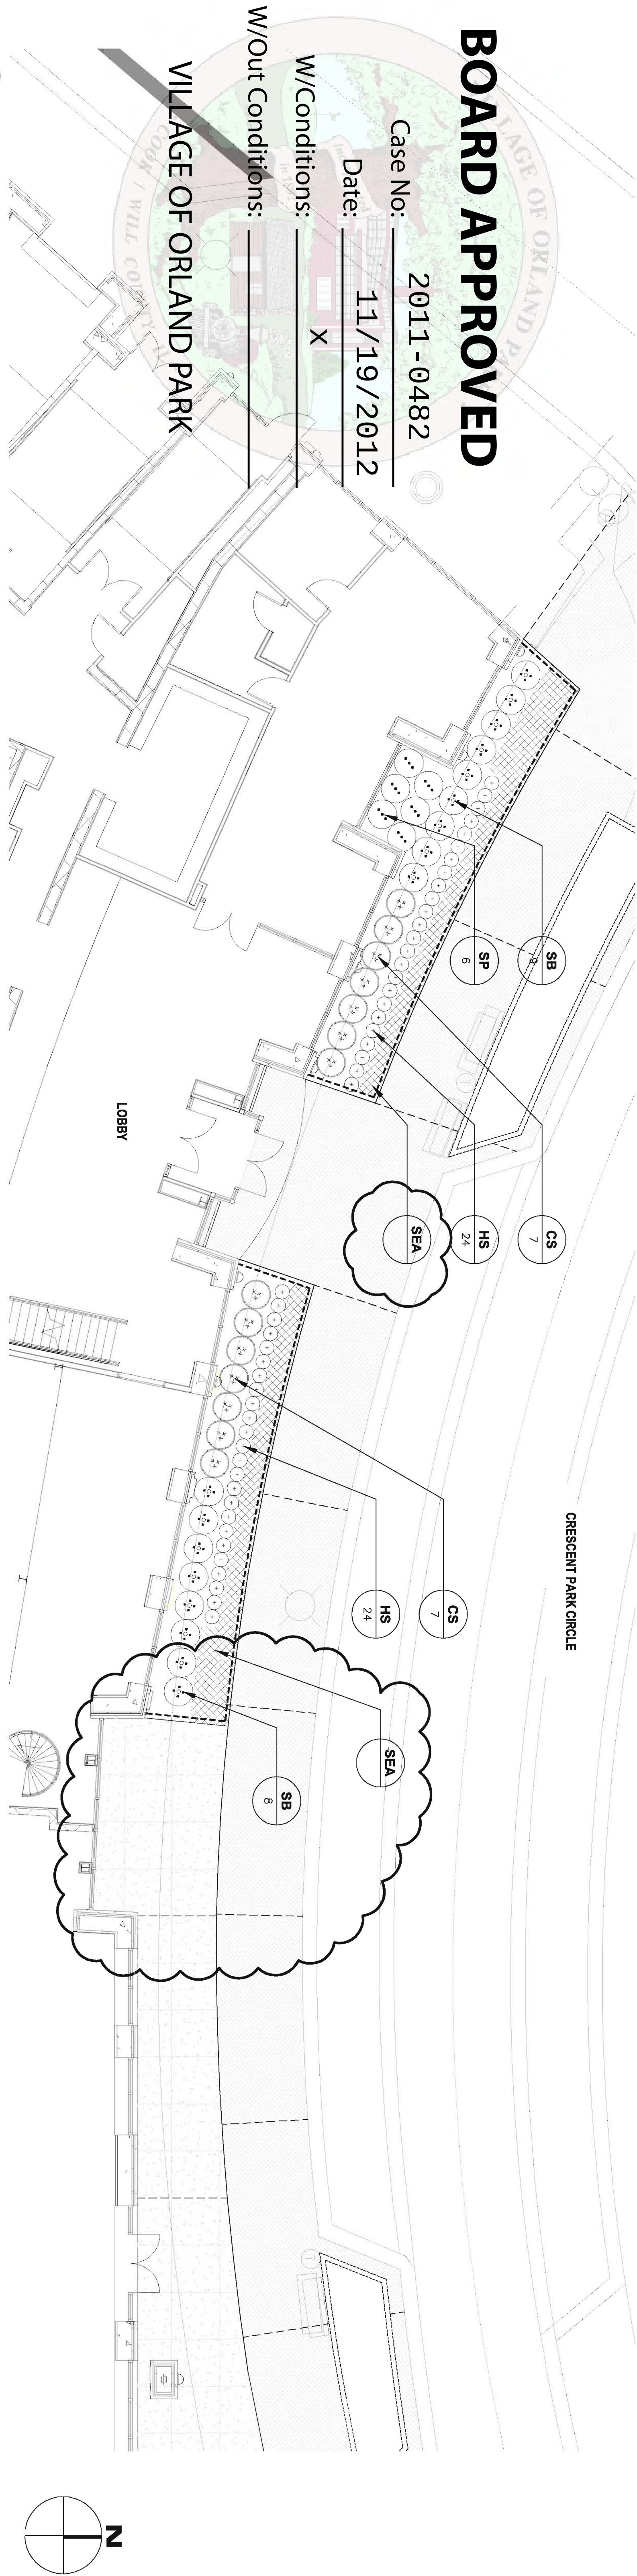

2 FOUNDATION PLANTING ENLARGEMENT
1/8"=1'-0"

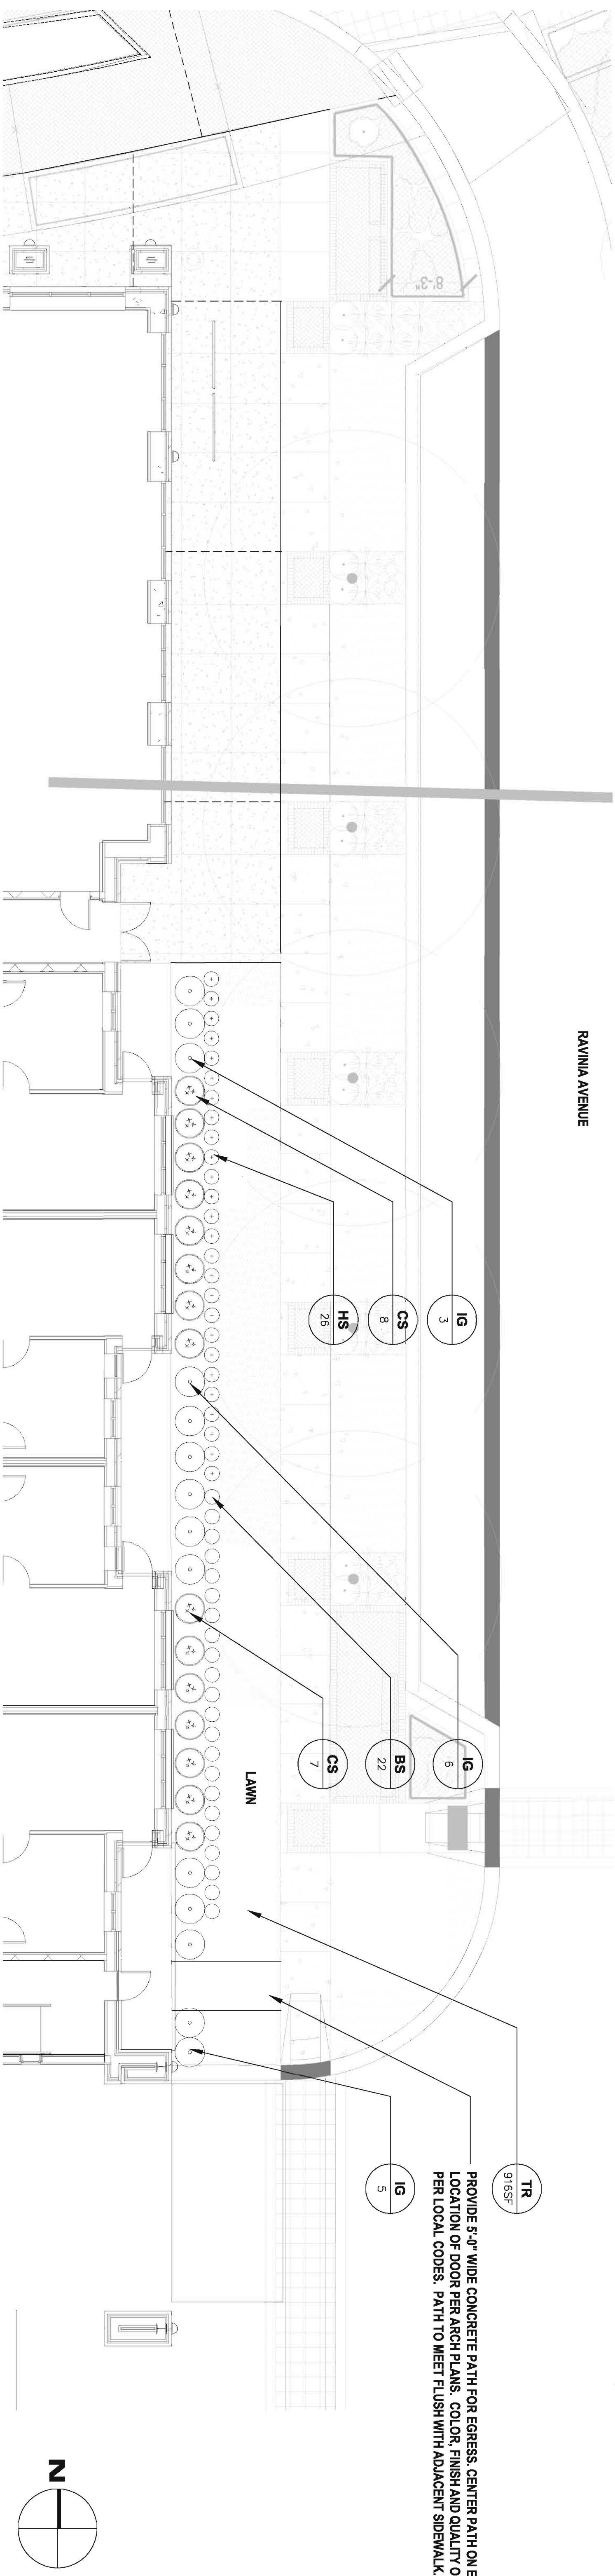

3 FOUNDATION PLANTING ENLARGEMENT
1/8"=1'-0"

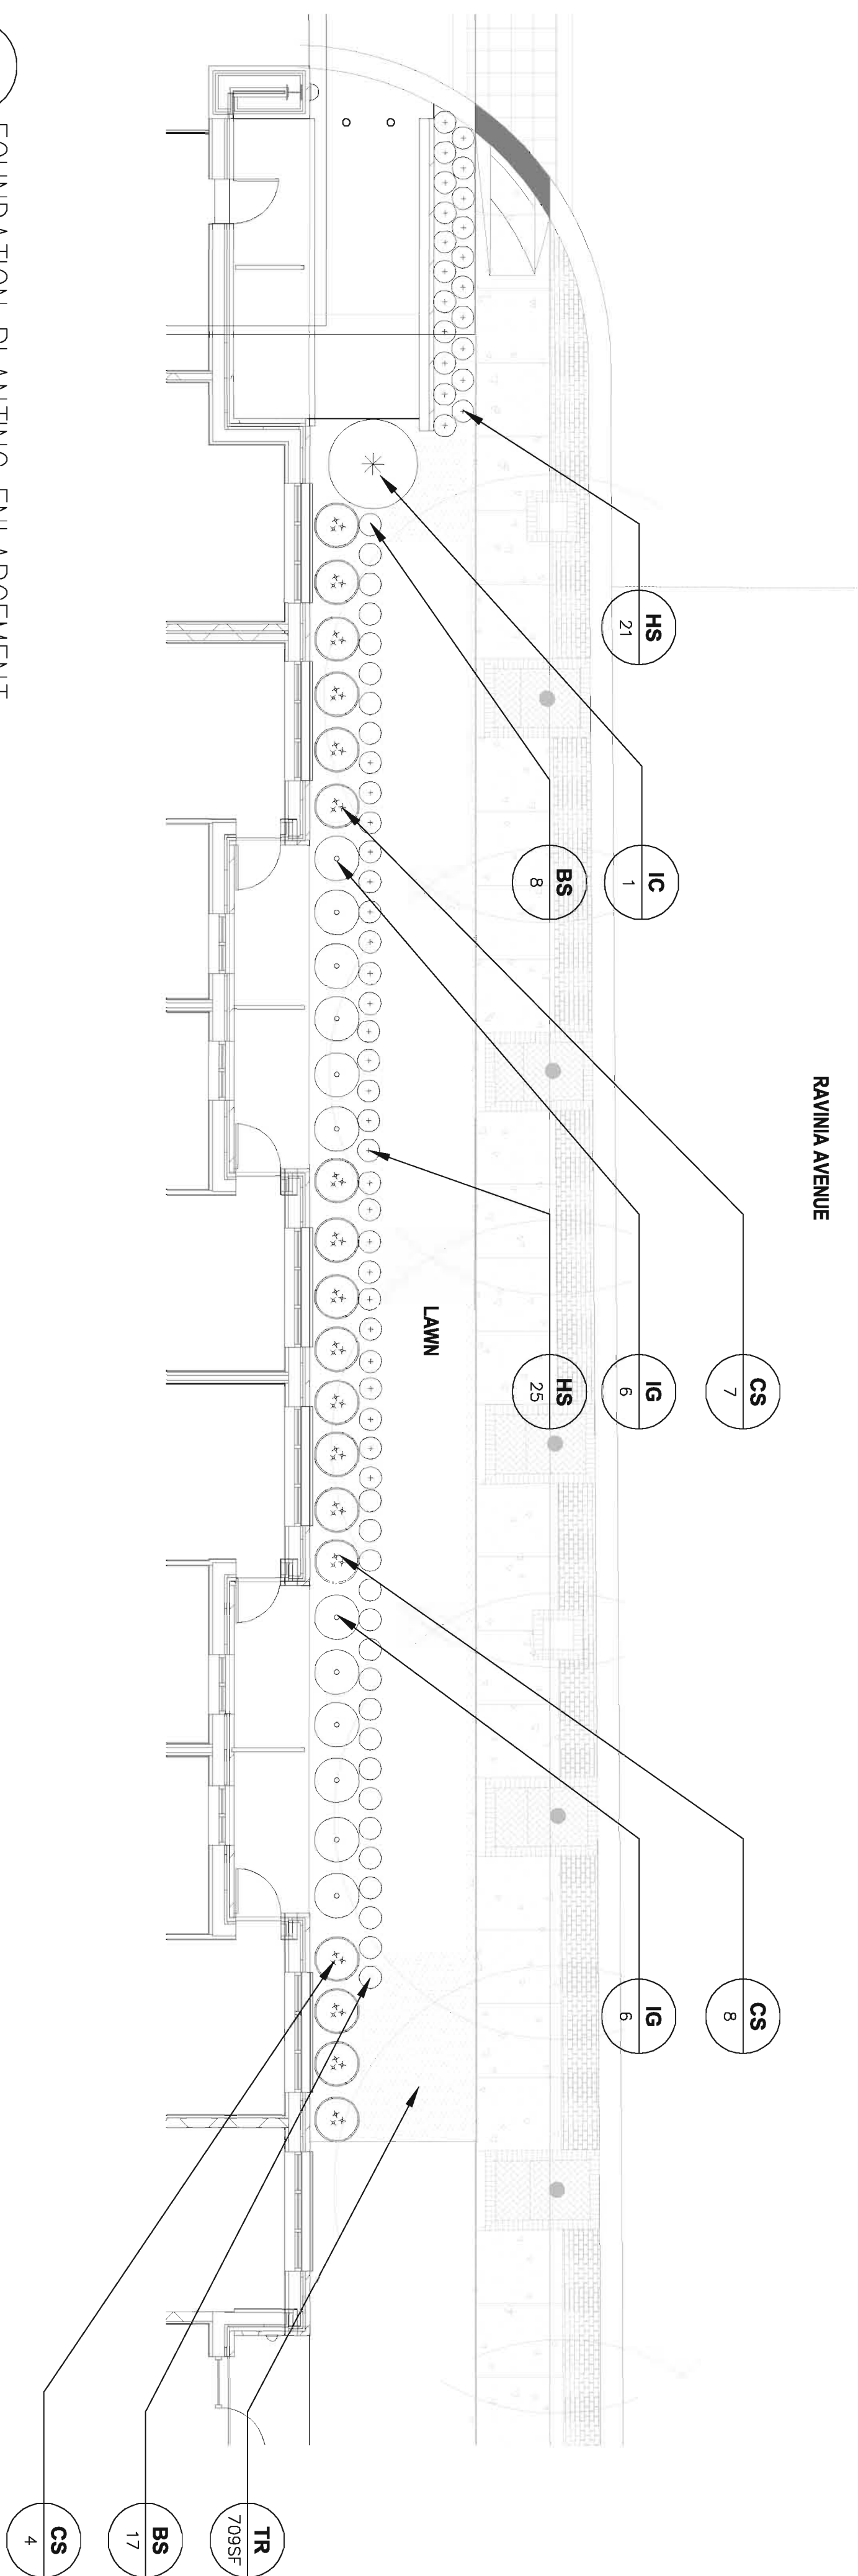

PLANT LIST - THIS SHEET

Qty.	Key	Botanical/Common Name	Size	Comments
47	BS	Buxus sempervirens 'suffruticosa'	1' gallon	
		Dwarf English Boxwood		
33	CS	Cornus stolonifera	18" Ht.	
		Red Osier Dogwood		
1	IC	Ilex crenata 'Steeds'	60" Ht.	
		Steeds Upright Holly		
26	IG	Ilex glabra 'Charmain'	24" Ht.	
		Nordic Inkberry Holly		
157 SF	NR	50% Nepeta racemosa 'Walkers Low'	1' gallon @ 18" OC.	Alternate every other species
22	HS	50% Liriope spicata	1' gallon @ 12" OC.	In planting bed - Qty: 90 each
		Hemerocallis 'Stella de Oro'		
		Doylly		
17	SB	Spiraea x bumalda	24" Ht.	
		Burnoid Spiraea		
6	SP	Syringa pubescens 'Miss Kim'	24" Ht.	
		Korean Lilac		
1663 SF	TR	Turf (Sod)	500	Hardy to Zone 5
		Low Growing Fescue		

DESIGN COLLECTIVE

ARCHITECTURE, PLANNING, INTERIORS
WWW.DESIGNCOLLECTIVE.COM

601 EAST PRATT STREET, SUITE 300
BALTIMORE, MARYLAND 21202
T: 410.685.6655 F: 410.539.6242

312 BLACKWELL STREET, SUITE 100
DURHAM, NORTH CAROLINA 27701
T: 919.381.9322 F: 919.381.9323

ISSUED FOR	DATE
1. LANDSCAPE REVISIONS	2012.09.10
2. STREETSCAPE/PLANTING REVISIONS	2012.08.17
3. ISSUED FOR PERMIT	2012.04.13
CONSULTANT	

OWNER / DEVELOPER
METRA TRIANGLE FC,
LLC.

8900 KESTONE CROSSING
SUITE 200
INDIANAPOLIS, INDIANA 46240
PROJECT NAME
9750 ON THE PARK

PROJECT ADDRESS
DOWNTOWN ORLAND PARK,
ILLINOIS

PROJECT MANAGEMENT
DCI Project No. 678-11
Owner Project No. ---
Drawn by AG Checked by BR
SCALE



SHEET TITLE
FOUNDATION PLANTING
PLAN

SHEET NUMBER
1/8" = 1'-0"
L403

BOARD APPROVED

Case No: 2011 - 0482

Date: 11/19/2012

W/Conditions: X

W/Out Conditions:

VILLAGE OF ORLAND PARK



PLANT LIST - THIS SHEET

Qty.	Key	Botanical/Common Name	Size	Root	Comments
35	BS	Buxus sempervirens 'suffruticosa'	1 gallon		
22	CS	Cornus stolonifera	18" Ht.		
12	HS	Hemerocallis 'Stello de Oro'	1 gallon @ 12" OC		
9	IG	Ilex glabra 'Chamzai'	24" Ht.		
560 SF	TR	Turf (Sod)	SOD		Hardy to Zone 5

DESIGN COLLECTIVE

ARCHITECTURE, PLANNING, INTERIORS
WWW.DESIGNCOLLECTIVE.COM

601 EAST PRATT STREET, SUITE 300
BALTIMORE, MARYLAND 21202
T: 410.685.6655 F: 410.539.6242

312 BLACKWELL STREET, SUITE 100
DURHAM, NORTH CAROLINA 27701
T: 919.381.9322 F: 919.381.9323

ISSUED FOR PERMIT	2012.04.13
DATE	2012.09.10
ISSUED FOR PERMIT	2012.04.13
DATE	2012.09.10
ISSUED FOR PERMIT	2012.04.13
DATE	2012.09.10
ISSUED FOR PERMIT	2012.04.13
DATE	2012.09.10
ISSUED FOR PERMIT	2012.04.13
DATE	2012.09.10
ISSUED FOR PERMIT	2012.04.13
DATE	2012.09.10

OWNER / DEVELOPER
METRA TRIANGLE FC,
LLC.
8900 KEystone CROSSING
SUITE 200
INDIANAPOLIS, INDIANA 46240
PROJECT NAME
9750 ON THE PARK

PROJECT ADDRESS
DOWNTOWN ORLAND PARK,
ILLINOIS

PROJECT MANAGEMENT
DCI Project No. 678-11
Owner Project No. 678-11
Drawn by AG Checked by BR
SEAL

SEAL
VILLAGE OF ORLAND PARK
15701445
11/19/2012

FOUNDATION PLANTING
PLAN

2011-0482


Case No.: _____

Date: 11/19/2012 SECURE ABOVE LOWEST STOUT
BRANCH OF TREE, MIN OF 1/3 OF TREE HEIGHT


W/Conditions: _____ BUILDINGS, EXPOSED STAKES TO FIRM BEARING, TYP.

W/Out Conditions: 0" ✓ CUT & REMOVE BURLAP FROM TOP 1/3 OF ROOT B


VILLAGE OF ORLAND PARK

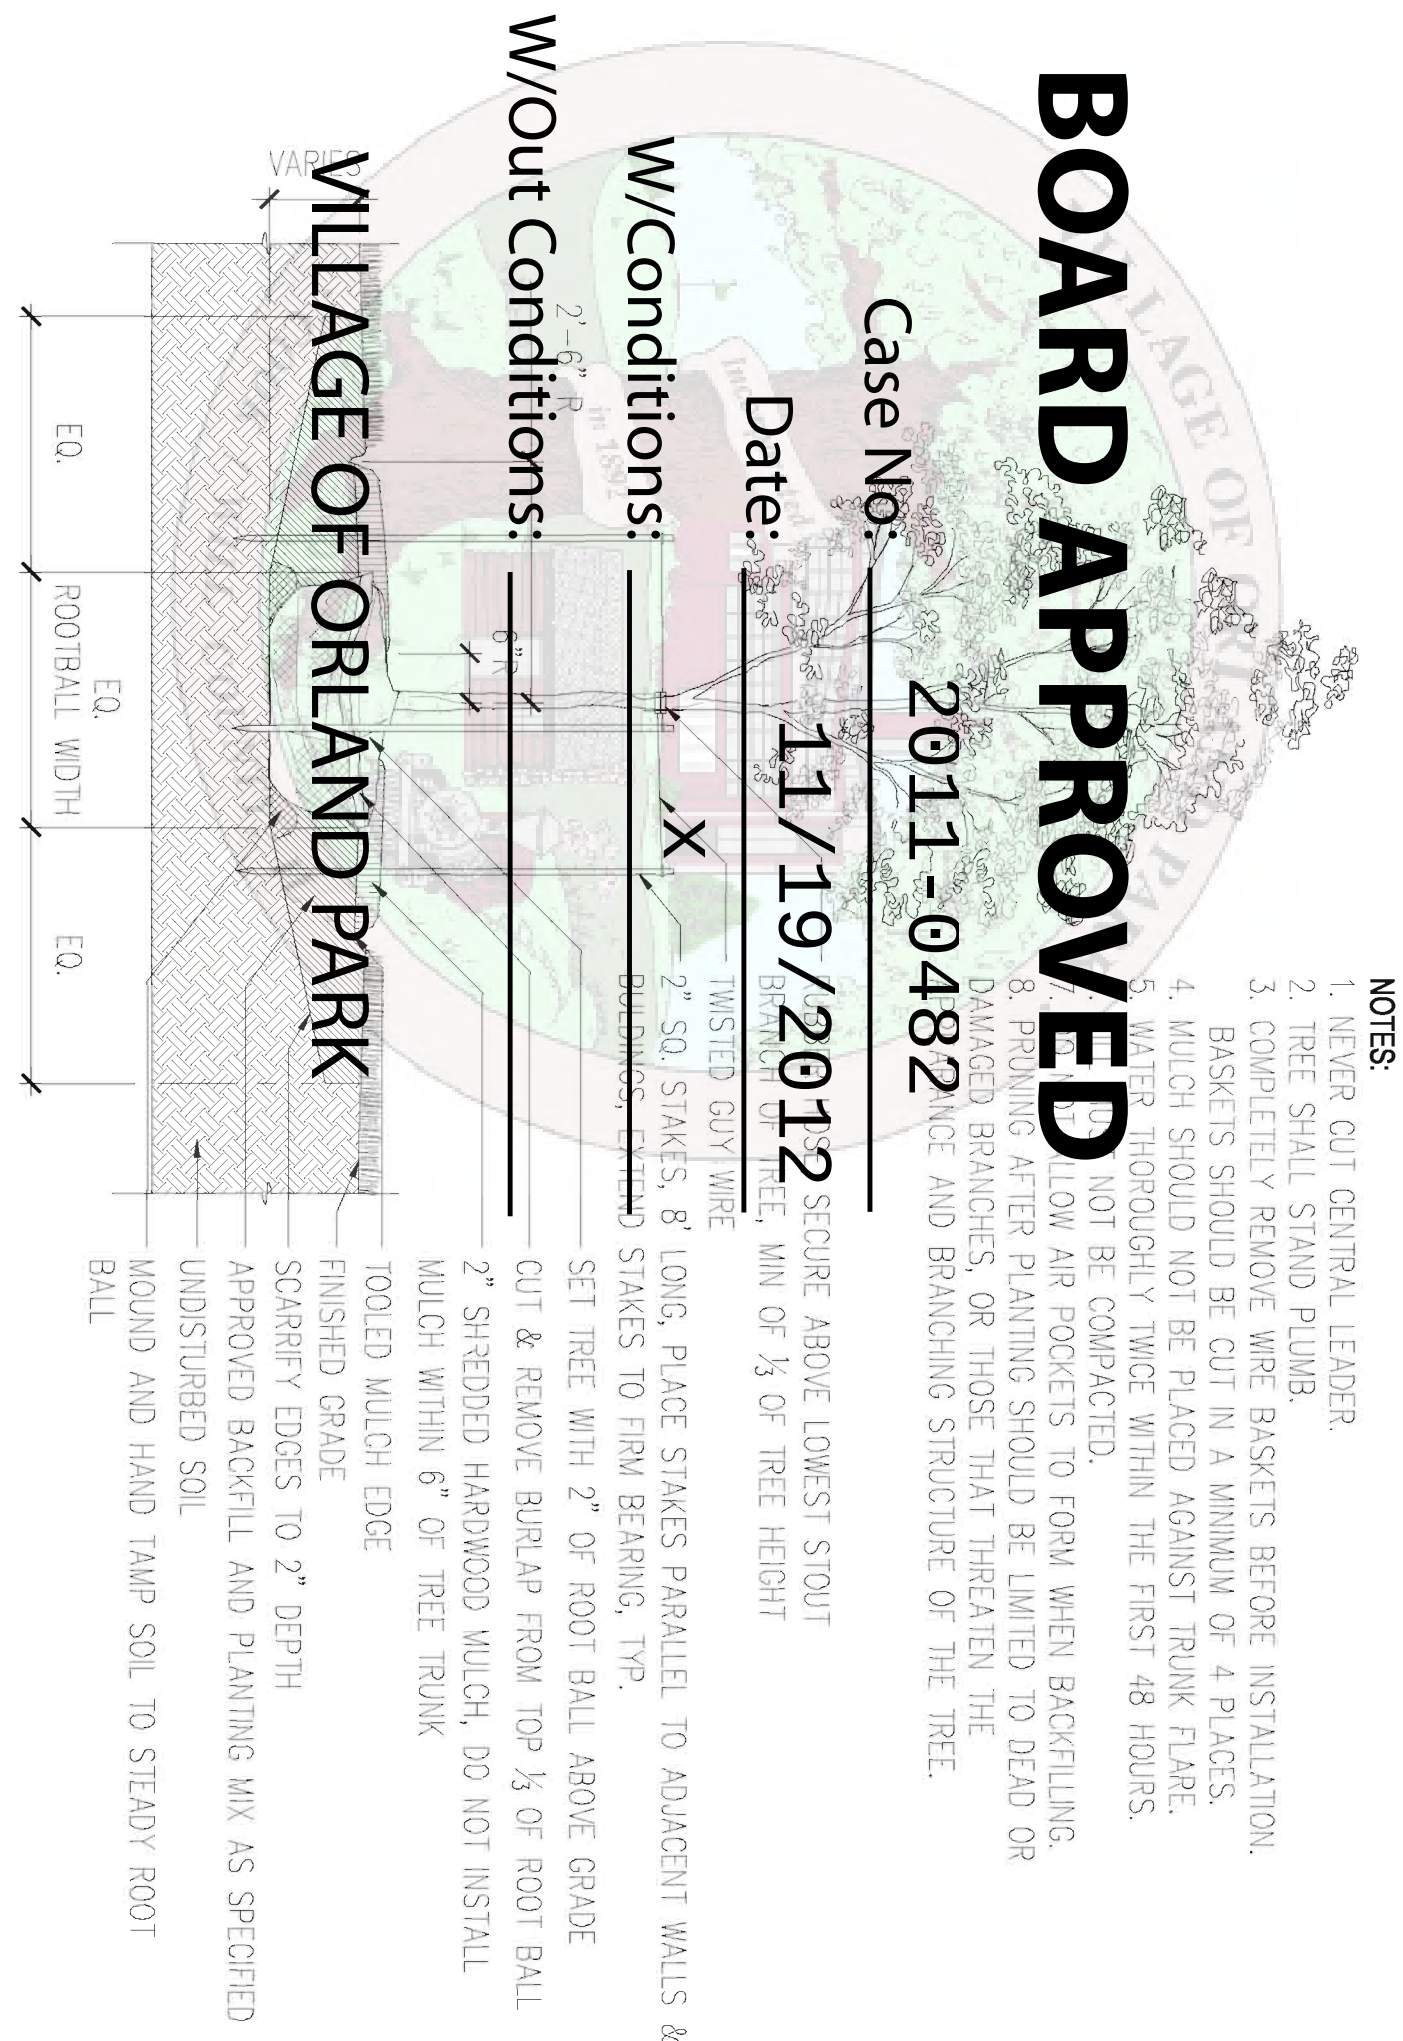

TREE PLANTING – STAKED
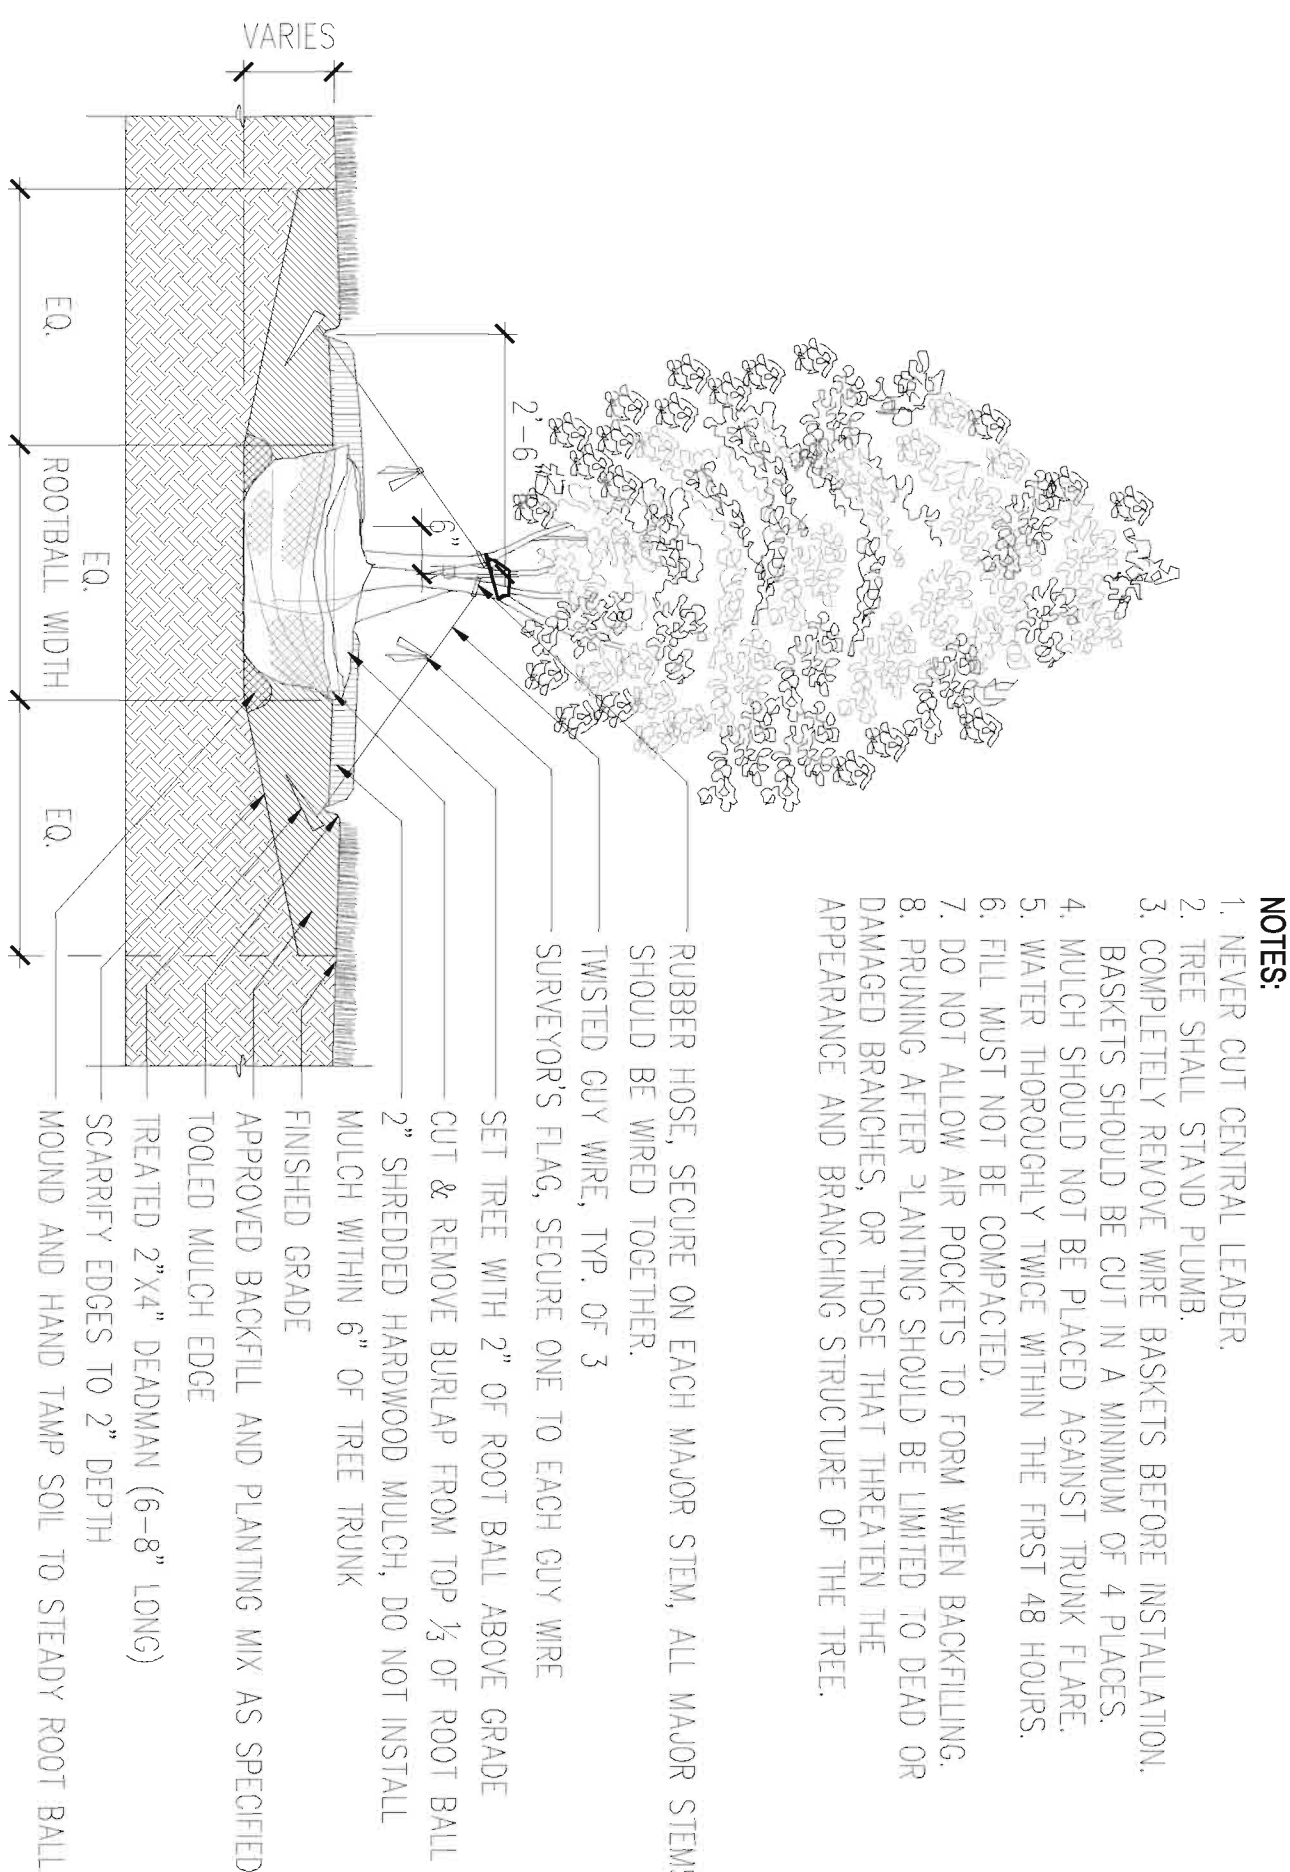
$$1/2'' = 1'-0''$$


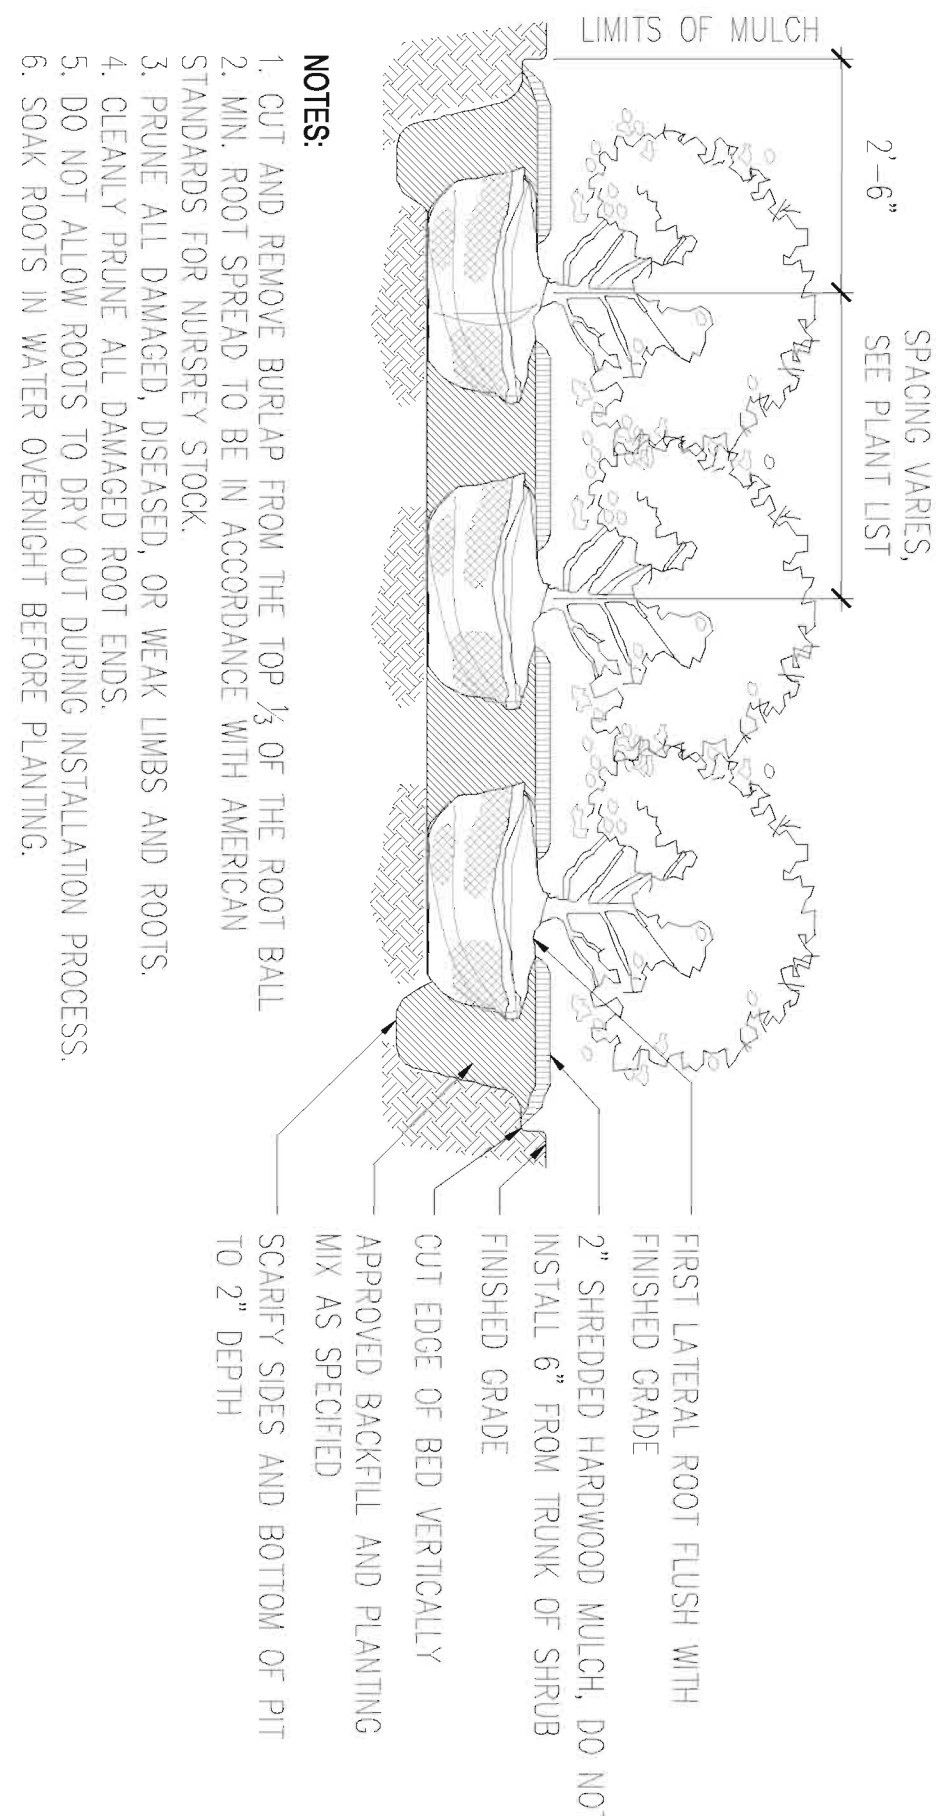
MULTI-STEM TREE - STAKED
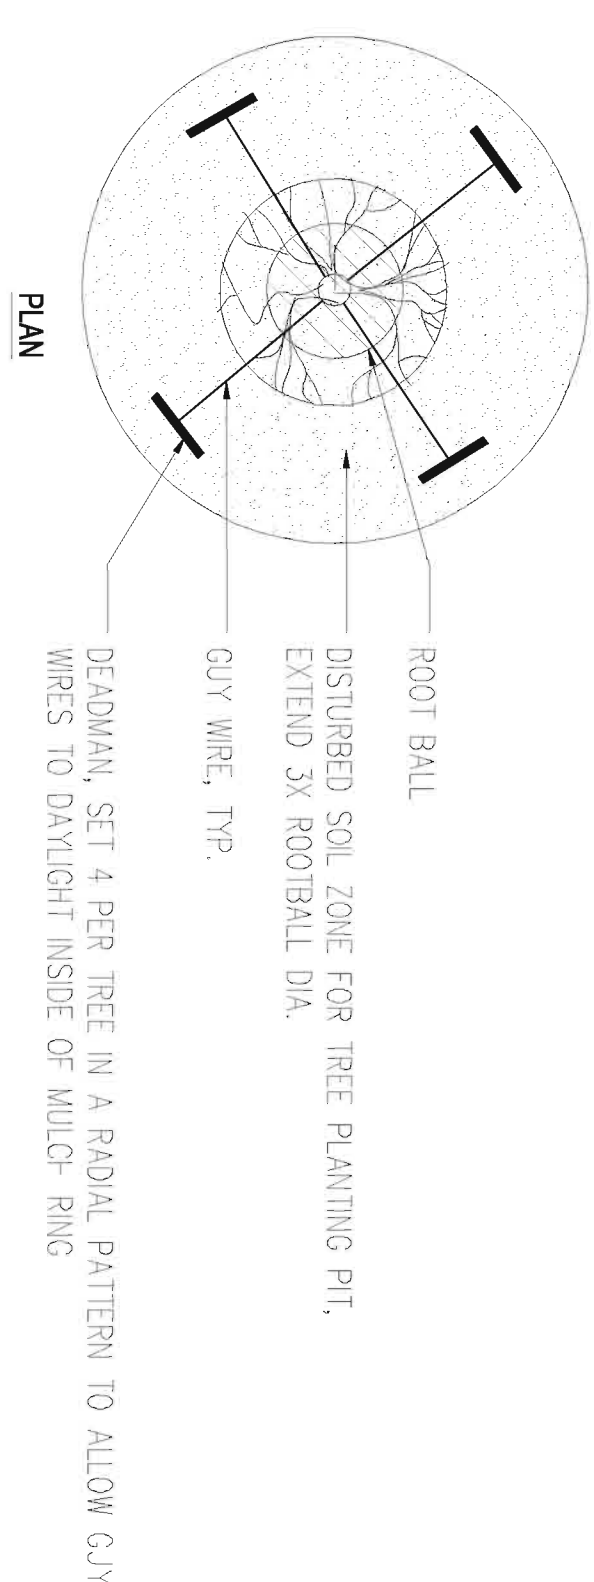
$$\frac{1/2''}{1'-0} = 1'-0$$


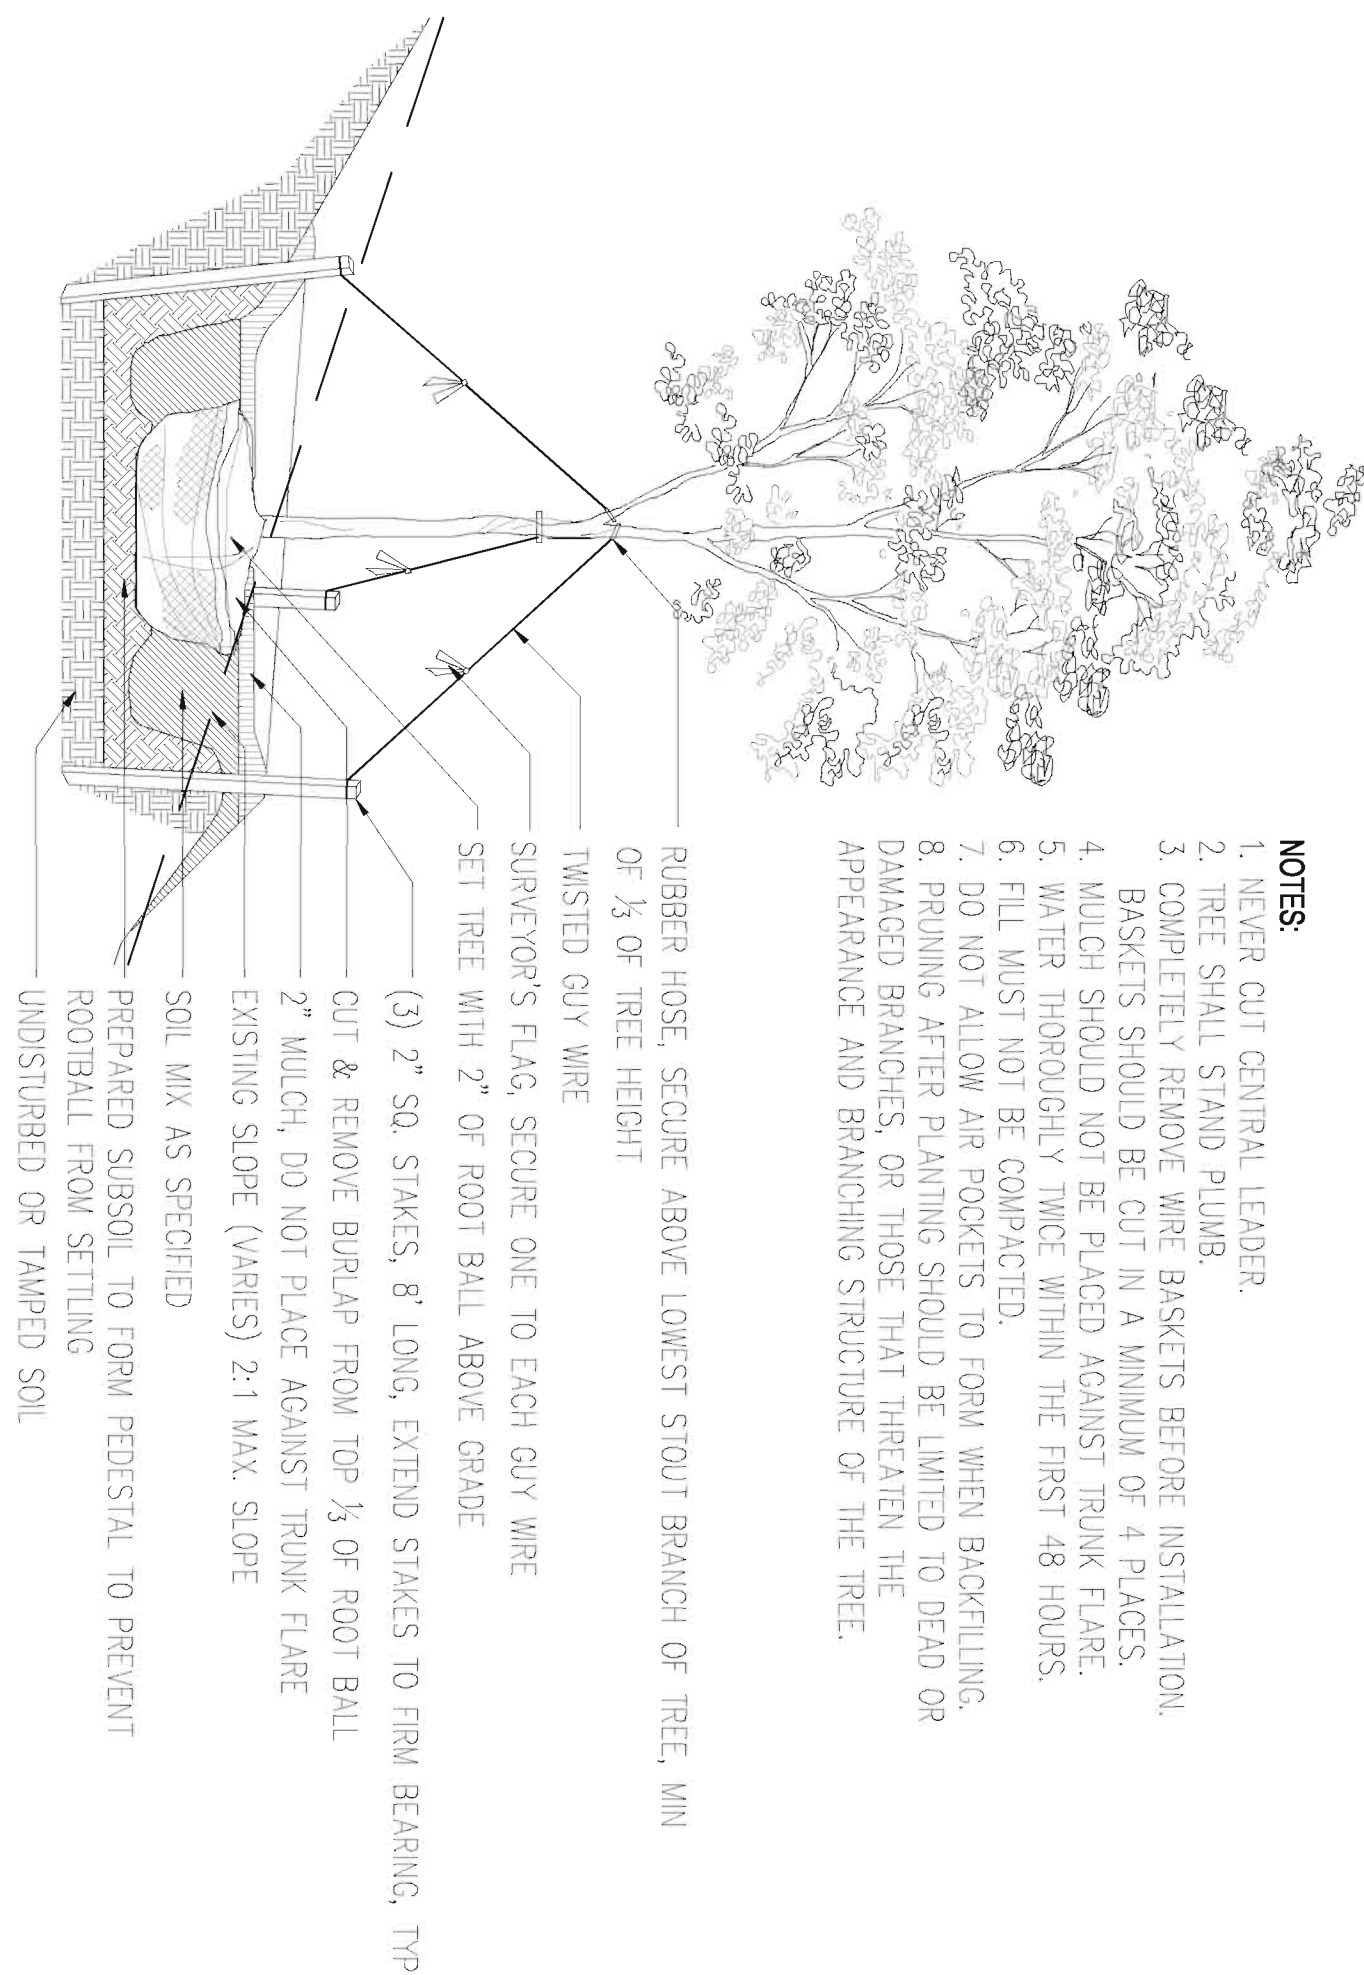
TREE STAKING - PLAN

$$3 \overline{) 1/2} = 1'-0"$$


SHRUB PLANTING

$$\frac{1/2''}{4} = 1'-0''$$


5 TREE PLANTING - SLOPED

$$\frac{1/2''}{5} = 1'-0''$$


PLANT SPACING
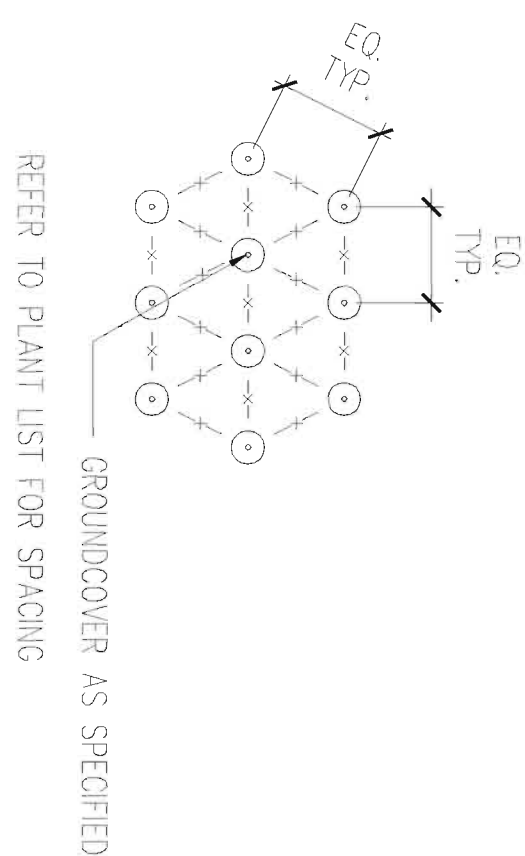
$$b) \quad \frac{1/2''}{1' - 0'}$$


MASTER PLANT LIST

TREES

Dy.	Key	Botanical/Common Name	Size	Root	Comments
3	AG	Acer gresum Paperbark Maple	8' Ht.	B&B	
8	BU	Bauhinia nigra Riverbirtin	8'-12' Ht.	B&B	(?) 8'Ht. (5) 12' Ht.
9	CC	Cercis canadensis Eastern Redbud	12' Ht.	B&B	Standard
15	MV	Magnolia virginiana Sweet Bay Magnolia	8' Ht.	B&B	
31	TG	Thuja 'Green Giant' Arborvitae	6' Ht.		
8	UA	Ulmus americana 'Princeton' Princeton Elm	10' Ht.	B&B	

UNDERPLANTING

Qty.	Key	Botanical/Common Name	Size	Comments
215	BS	Buxus sempervirens 'suffruticosa'	1 gallon	
125	JS	Dwarf English Boxwood		
		Cornus stolonifera	18" Ht.	
		Red Oster Dog-wood		
		50% Echinacea purpurea	Quart @ 18" OC	Alternate every other species in planting bed – Qty:425 each
400 SF	FM	50% Miscanthus "Little Kitten"	1 gallon @ 12" OC	Alternate each species in planting bed – Qty: 235 each
611	HB	Hardy Fern Mix	Quart	
195	IS	with Pochysandra terminalis		
		Helictotrichon sempervirens		
		Blue Oat Grass		
		Heimerocallis 'Steila de Oro'	1 gallon @ 12" OC	
281	IG	Dogfly		
		Ilex crenata 'Steeds'	60" Ht.	
		Steeds Upright Holly	24" Ht.	
		Ilex glabra 'Chromazin'		
3280 SF	LS	Nordic Inlberry Holly		
510	MS	50% Latis spicata	quart @ 24" OC	Alternate every other species in planting bed – Qty:480 each
		50% Multiberoglio rigens		
		Miscanthus sinensis 'Purpureus'	Quart @ 24" OC	
		Purple Silver Grass		
180	MR	Multiberoglio rigens	Quart @ 24" OC	
157 SF	JR	Deer Grass		
		50% Nepeta racemosa 'Walkers Low'	1 gallon @ 18" OC.	Alternate every other species in planting bed – Qty:50 each
		50% Liriope spicata		
		Pennisetum alopecuroides 'Hameln'	Quart @ 12" OC	
610	PA	Dwarf Fountain Grass		
17	JB	Spiraea x bumalda	24" Ht.	
6	JP	Burnind Spirea	24" Ht.	
17339SF	TR	Syringa pubescens 'Miss Kim'		
		Korean Lilac		
17339SF	TR	Turf (Sod)	SOD	Hardy to Zone 5
		Low Growing Fescue		

PLANTING NOTES:

Quantities in this legend are FOR REFERENCE ONLY. Contractor is responsible for all plant symbols and hatches on plans.

601 EAST PRATT STREET, SUITE 300
BALTIMORE, MARYLAND 21202
T: 410.685.6655 F: 410.539.6242

312 BLACKWELL STREET, SUITE 100
DURHAM, NORTH CAROLINA 27701
T: 919.381.9322 F: 919.381.9323

SHEET TITLE
PLANTING DETAILS

SCALE
1/8" = 1'-0"

406