

BOARD APPROVED

Case No: 2015-0269

Date: 8-3-15

W/Conditions: YES

W/Out Conditions:

VILLAGE OF ORLAND PARK

ORLAND PARK / WILL COUNTY

PRELIMINARY SITE IMPROVEMENT PLANS FOR

RIZZA PORSCHE AND ACURA

8130 W. 159TH STREET

ORLAND PARK, ILLINOIS 60462

| CIVIL DRAWING INDEX |                                                      |          |
|---------------------|------------------------------------------------------|----------|
| SHEET               | DESCRIPTION                                          | DATE     |
| T-1.0               | TITLE SHEET                                          | 06-17-15 |
| C-2.0               | SITE GEOMETRIC PLAN                                  | 06-17-15 |
| C-2.1               | PHASING PLAN                                         | 06-17-15 |
| C-4.0               | PRELIMINARY SITE GRADING PLAN                        | 06-17-15 |
| C-5.0               | PRELIMINARY SITE UTILITY PLAN                        | 06-17-15 |
| C-6.0               | SITE STORMWATER POLLUTION PREVENTION PLAN            | 06-17-15 |
| C-7.0-C-7.1         | CONSTRUCTION DETAILS                                 | 06-17-15 |
| S-1 - S-2           | BOUNDARY SURVEY (PREPARED BY W-T SURVEYING, INC.)    | 02-10-15 |
| S-3                 | TOPOGRAPHIC SURVEY (PREPARED BY W-T SURVEYING, INC.) | 02-10-15 |

BENCHMARK

1. ONSITE BENCHMARK #1- WEST SOUTHWEST FLANGE BOLT ON HYDRANT, 64.40' N.W. OF MH #3 AND 64.38' S.W. OF MH #4, ELEVATION=701.66' (NAVD88)

2. ONSITE BENCHMARK #2- N.E. FLANGE BOLT ON HYDRANT, 37.42' N.W. OF MH #16 AND 40.42' E.N.E. OF MH #19, ELEVATION=709.30' (NAVD88)

SITE LOCATION MAP

42" MWRD INTERCEPTOR

PROJECT SITE

VILLAGE OF ORLAND PARK STORM SEWER TO TINLEY CREEK

SECTION 14, TOWNSHIP 36 NORTH, RANGE 12 EAST

SCALE: 1" = 200'

CIVIL ENGINEERING STATEMENT AND SEAL

I, JASON E. GREEN, P.E., DULY LICENSED BY THE ILLINOIS DEPARTMENT OF FINANCIAL AND PROFESSIONAL REGULATION, DO HEREBY STATE THAT THIS DOCUMENT WAS PREPARED BY ME OR UNDER MY DIRECT SUPERVISION AND TO THE BEST OF MY KNOWLEDGE AND BELIEF DOES CONFORM TO THE APPLICABLE BUILDING CODES AND ORDINANCES, AND ARE IN COMPLIANCE WITH THE ENVIRONMENTAL BARRIERS ACT (410 ILCS 25) AND THE ILLINOIS ACCESSIBILITY CODE (71 ILL. ADM. CODE 400).

JASON E. GREEN - P.E.  
062-059460    DATE OF EXPIRATION - NOVEMBER 30, 2015  
NOTE: SIGNED AND SEALED FOR SHEETS T-1.0, C-2.0, C-2.1, C-4.0, C-5.0 - C-7.1

CALL JULIE TOLL FREE  
(800)842-0123  
OPERATES 24 HOURS A  
DAY 365 DAYS A YEAR

WARNING

CALL BEFORE YOU DIG

CALL  
(800)842-0123  
48 HOURS BEFORE  
YOU DIG

CONTRACTOR MUST LOCATE PRIVATE UTILITIES IN AREA OF CONSTRUCTION PRIOR TO PROCEEDING WITH WORK

BY DATE

4-10-15

ENK

REVISIONS

SUBMITTED FOR PRELIM. SITE PLAN REVIEW

PER VILLAGE COMMENTS

W-T CIVIL ENGINEERING, LLC

CIVIL AND STRUCTURAL ENGINEERS

2875 Pridem Avenue  
Orland Park, Illinois 60462  
PH: (224) 738-0333 FAX: (224) 735-6444  
www.wtengineering.com

IL License No.: 184-003492 Exp: 04/30/17

W-T

RIZZA PORSCHE AND ACURA

8130 W. 159TH STREET

ORLAND PARK, ILLINOIS 60462

TITLE SHEET

DATE: 4-10-15

SCALE: NTS

DRAWN: SMN

CHECK: JLG

JOB: CE14145

SHEET: T-1.0

COPYRIGHT ©2015 W-T CIVIL ENGINEERING, LLC

BOARD APPROVED

Case No: 2015-0269


Date: 8-3-15

W/Conditions: YES

W/Out Conditions:

VILLAGE OF ORLAND PARK

ORLAND PARK / WILL COUNTY

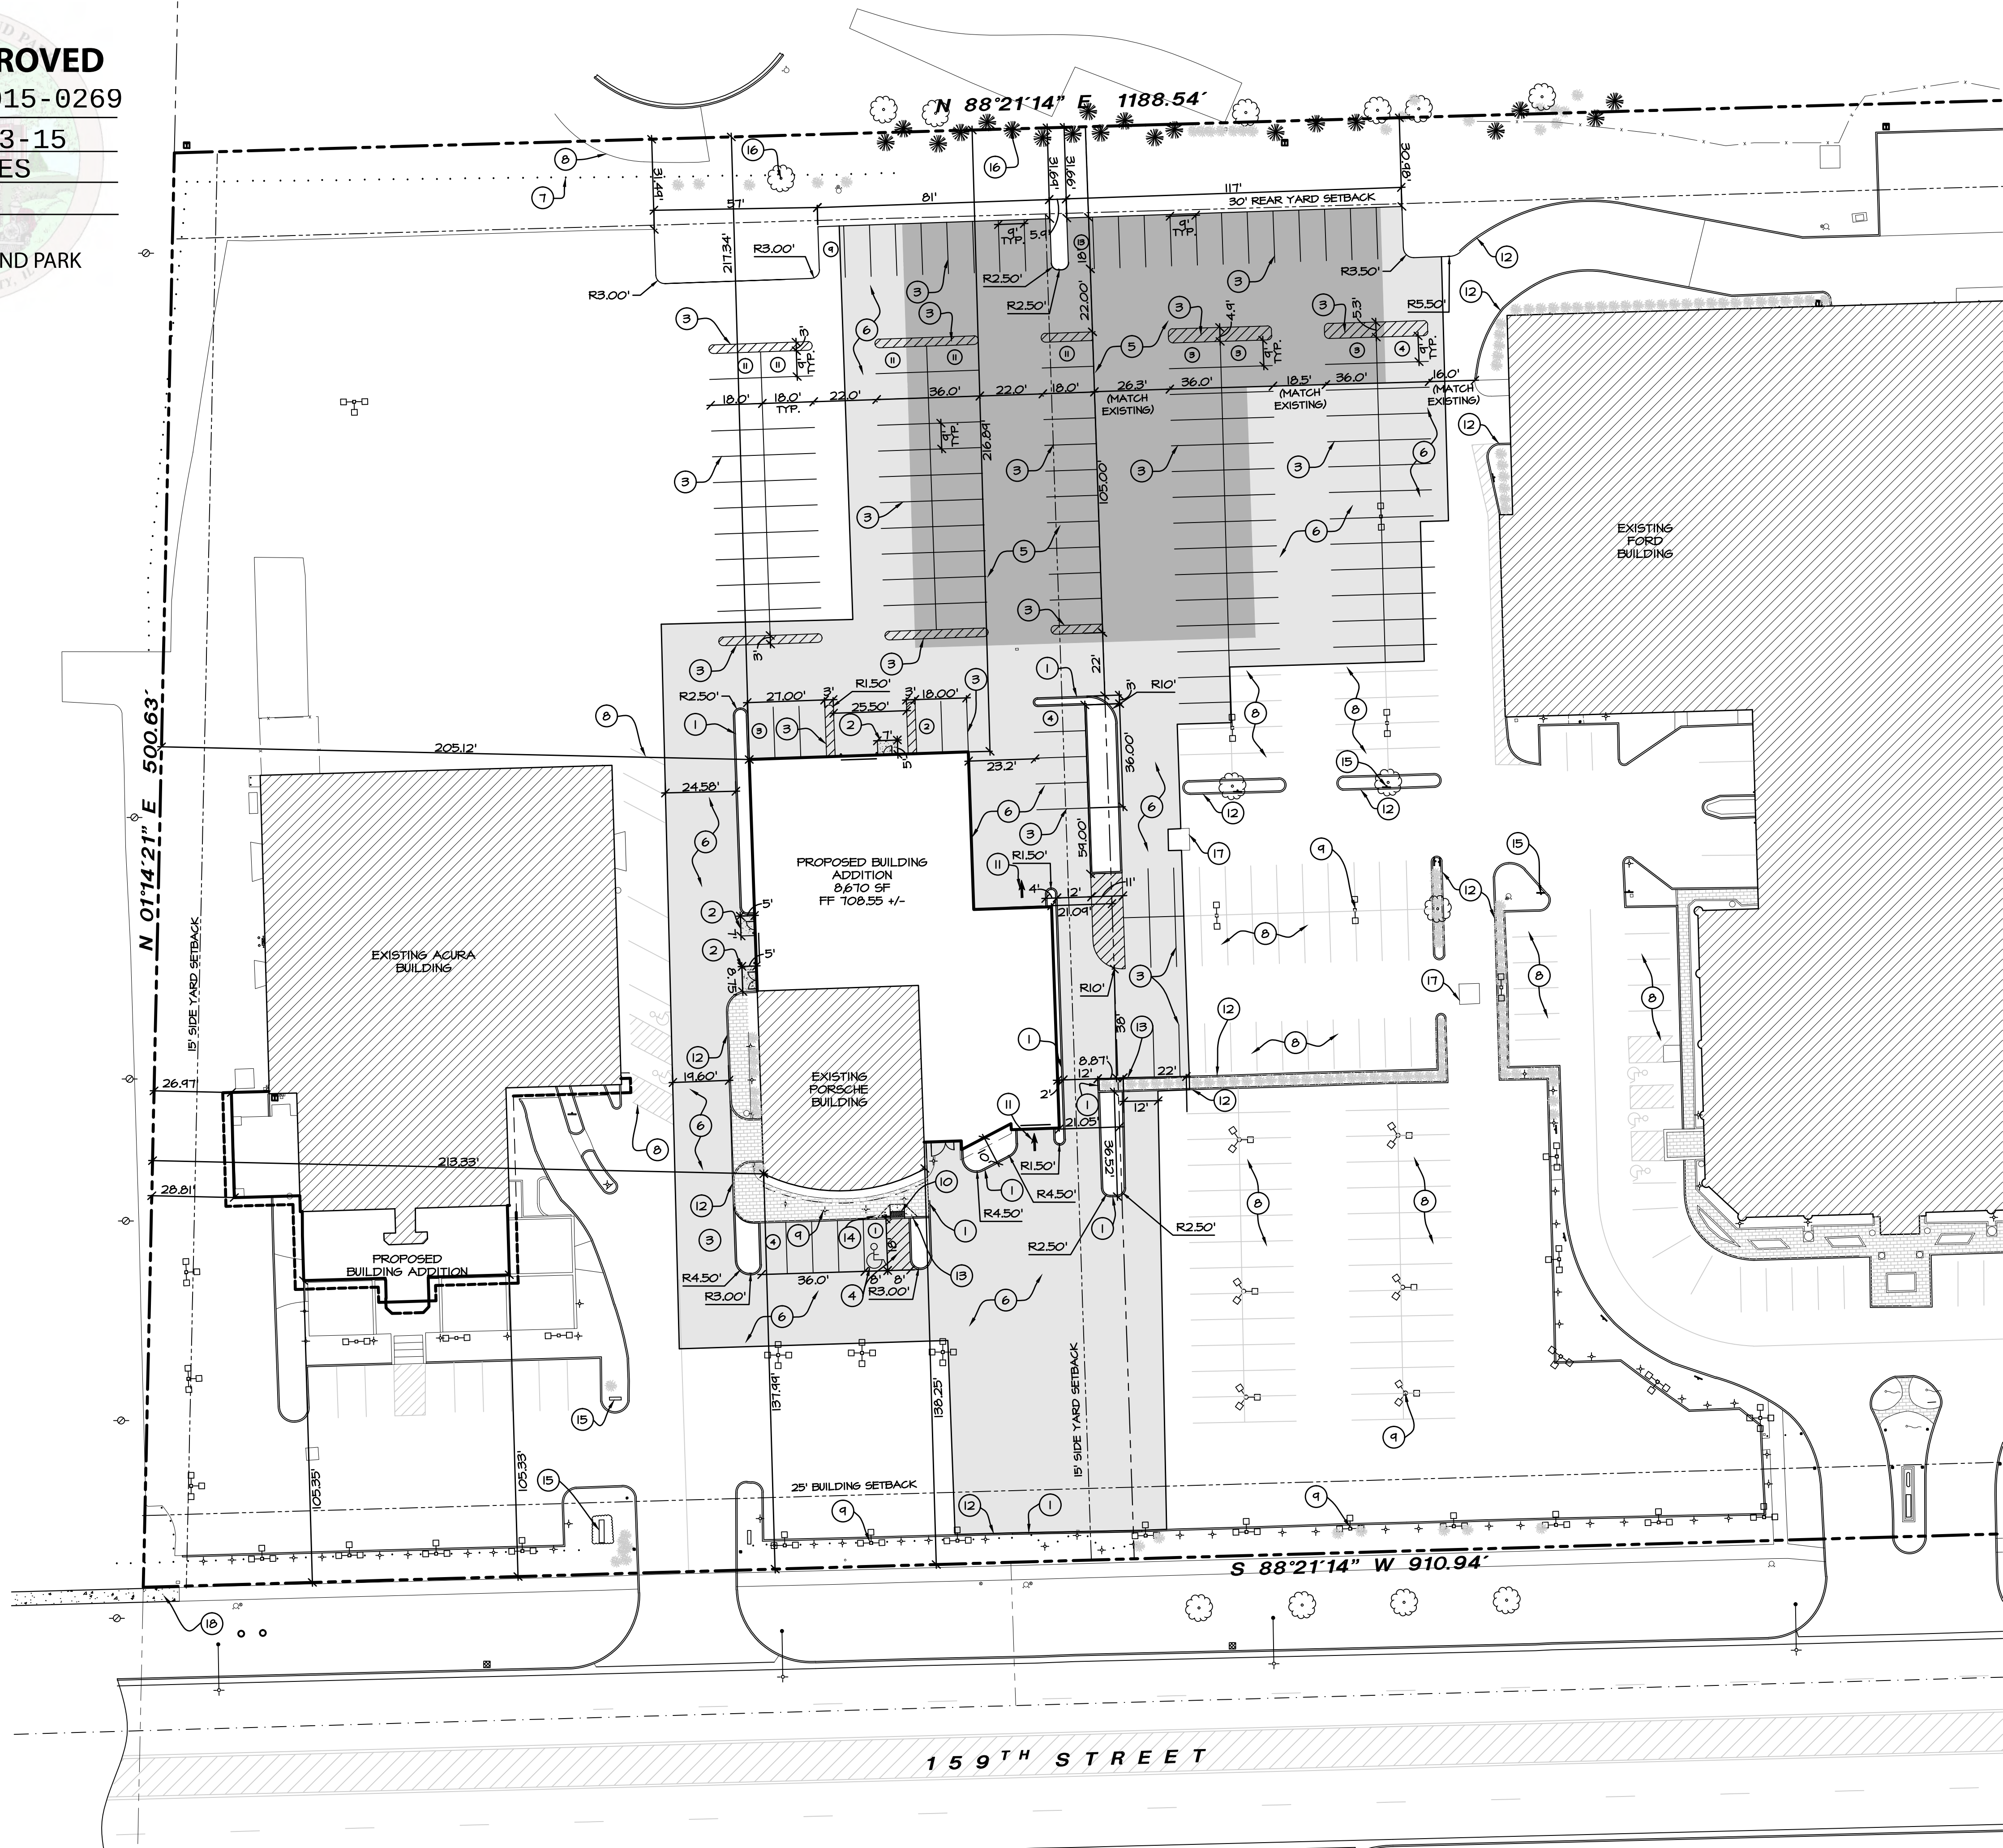

LEGEND

EXISTING FENCE LINE

PROPOSED FENCE LINE

EXISTING TREE

EXISTING SHRUB

PROPOSED PROPERTY LINE

EXISTING PROPERTY LINE

EXISTING AREA LIGHT

EXISTING LIGHT POLE

EXISTING SIGN

EXISTING MONUMENT SIGN

- SITE GEOMETRIC NOTES:
1. ALL DIMENSIONS ARE FACE OF CURB TO FACE OF CURB OR EDGE OF PAVEMENT UNLESS NOTED OTHERWISE.

2. ALL RADII ARE MEASURED TO FACE OF CURB UNLESS NOTED OTHERWISE.

3. CONTRACTOR SHALL CONTACT JULLIE, (811 OR 1-800-842-0123) AND/OR PRIVATE LOCATING SERVICE TO LOCATE ALL UNDERGROUND UTILITY LINES PRIOR TO STARTING ANY DEMOLITION AND/OR EXCAVATION. EXACT LOCATIONS OF ANY EXISTING ELECTRIC, GAS, TELEPHONE, ETC. LINES ARE UNKNOWN.

4. CONTRACTOR SHALL EXCAVATE AND VERIFY ALL EXISTING SEWER LOCATIONS, SIZES, CONDITIONS AND ELEVATIONS AT PROPOSED POINTS OF CONNECTION PRIOR TO ANY UNDERGROUND CONSTRUCTION AND NOTIFY THE OWNER AND ENGINEER OF ANY DISCREPANCIES OR CONFLICTS.

5. TOPOGRAPHY SHOWN REPRESENTS SITE CONDITIONS PER BOUNDARY & TOPOGRAPHIC SURVEY LAST DATED 2-10-15, PREPARED BY W-T LAND SURVEYING, INC. CONTRACTOR SHALL FIELD VERIFY EXISTING ELEVATIONS AND CONDITIONS (INCLUDING BUT NOT LIMITED TO VERIFICATION OF CONTROL AND ALL UTILITIES WHETHER DEPICTED OR NOT) PRIOR TO CONSTRUCTION.

6. PARKING LOT PAVEMENT MARKINGS SHALL BE PAINTED WITH TWO COATS OF 4" YELLOW EXCEPT STOP BARS AND ANY OTHER LANE MARKINGS, WHICH SHALL BE PAINTED WHITE. ALL PAVEMENT MARKINGS SHALL BE MADE WITH HIGH QUALITY PAINT CONFORMING TO ARTICLE 1045.02 OF THE I.D.O.T. STANDARD SPECIFICATIONS.

7. CONSTRUCTION SURVEY AND STAKEOUT SHALL BE THE RESPONSIBILITY OF THE CONTRACTOR.

8. ALL EXISTING LANDSCAPE TO REMAIN UNLESS NOTED TO BE REMOVED. RESTORE ALL DISTURBED GREEN AREAS WITH MINIMUM 6" TOPSOIL AND SEED UNLESS NOTED OTHERWISE.

- PROJECT NOTES
1. NEW 6" BARRIER CURB.

2. NEW CONCRETE SIDEWALK.

3. NEW 4" WIDE YELLOW PAINTED PAVEMENT STRIPING.

4. NEW HANDICAP STALL WITH STRIPING.

5. NEW FULL DEPTH ASPHALT PAVEMENT.

6. NEW ASPHALT OVERLAY.

7. EXISTING BOLLARD TO REMAIN (TYP.).

8. EXISTING PARKING FOR ADJACENT PROPERTY (TO REMAIN).

9. EXISTING LIGHT POLE TO REMAIN (TYP.).

10. NEW HANDICAP ACCESSIBLE RAMP WITH 2' WIDE TRUNCATED DOME PANEL.

11. NEW PAINTED DIRECTIONAL ARROW.

12. EXISTING CURB TO REMAIN.

13. NEW FULL DEPTH SANICUT.

14. NEW HANDICAP PARKING SIGN.

15. EXISTING SIGN TO REMAIN (TYP.).

16. EXISTING TREE TO REMAIN (TYP.).

17. EXISTING CONCRETE PAD TO REMAIN.

18. EXISTING 5' CONCRETE SIDEWALK TO BE EXTENDED +/- 250' WEST ACROSS AUTOMOBILE STORAGE LOT AND CONNECT TO EXISTING SIDEWALK.

HATCH LEGEND


NEW FULL DEPTH ASPHALT

ASPHALT OVERLAY

CONCRETE SIDEWALK

| EXISTING PARKING COUNT |    | NEW PARKING COUNT   |     |
|------------------------|----|---------------------|-----|
|                        |    | PORSCHE STORAGE     | 64  |
|                        |    | FORD STORAGE        | 26  |
| REGULAR PARKING        | 84 | EMPLOYEE / CUSTOMER | 13  |
| STALLS                 |    | ACCESSIBLE          | 1   |
| TOTAL                  | 88 | TOTAL               | 104 |

| IMPERVIOUS / PERVIOUS AREA |                        |
|----------------------------|------------------------|
|                            | EXISTING PROPOSED (SF) |
| IMPERVIOUS                 | 84,174 84,452          |
| PERVIOUS                   | 12,583 12,910          |

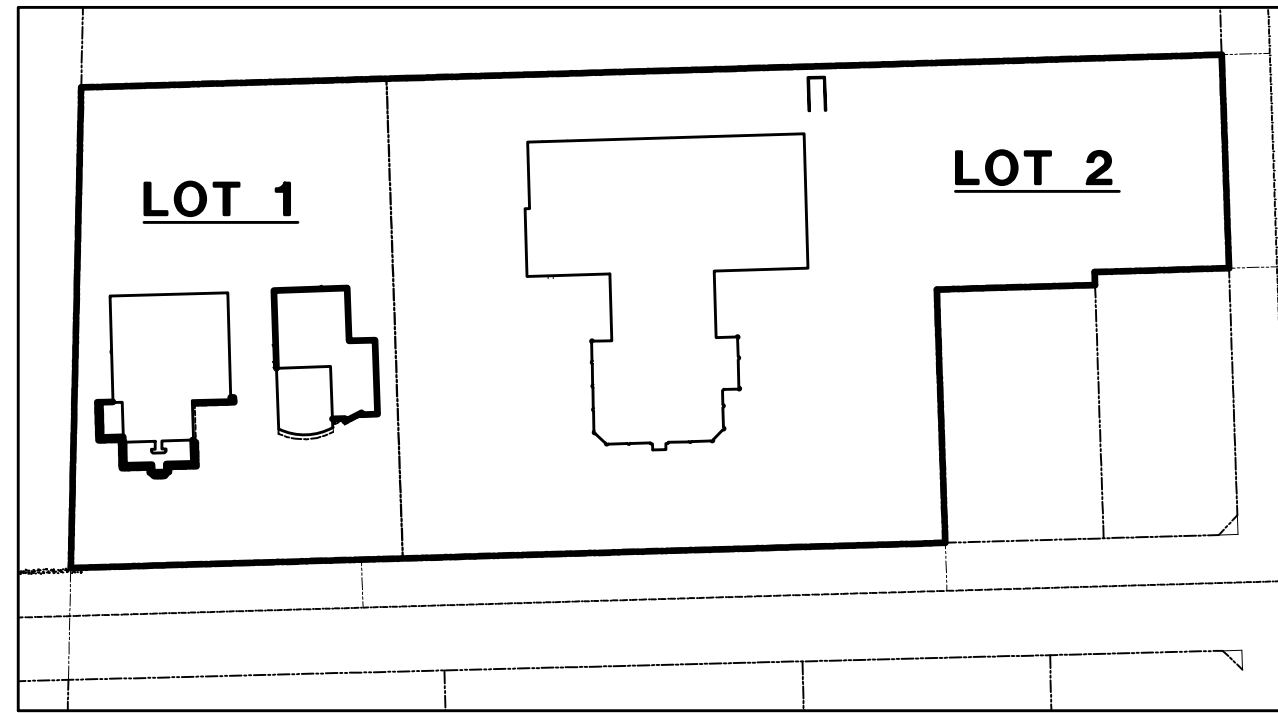

OVERALL SITE PLAN

LOT 1 ACREAGE = 3.81 ACRES  
LOT 1 COVERAGE = 88.2%

NORTH

1" = 30'

00 15 30 60 120

BY: ENK  
DATE: 4-10-15  
REVISIONS: SUBMITTED FOR PRELIM. SITE PLAN REVIEW  
ENK  
DATE: 6-11-15  
PER VILLAGE COMMENTS  
ENK  
DATE: 7-20-15  
PER VILLAGE COMMENTS  
JLG

W-T CIVIL ENGINEERING, LLC  
CIVIL AND STRUCTURAL ENGINEERS  
2675 Pratum Avenue  
Hoffman Estates, Illinois 60132  
PH: (224) 235-6444  
www.wtengineering.com  
IL License No.: 184-003492 Exp: 04/30/17

RIZZA PORSCHE AND ACURA

8130 W. 159TH STREET

ORLAND PARK, ILLINOIS 60462

SITE

GEOMETRIC

PLAN

DATE: 4-10-15

SCALE: 1" = 30'



DRAWN: SMN

CHECK: JLG

JOB: CEI4145


SHEET: C-2.0

COPYRIGHT © 2015 W-T CIVIL ENGINEERING, LLC

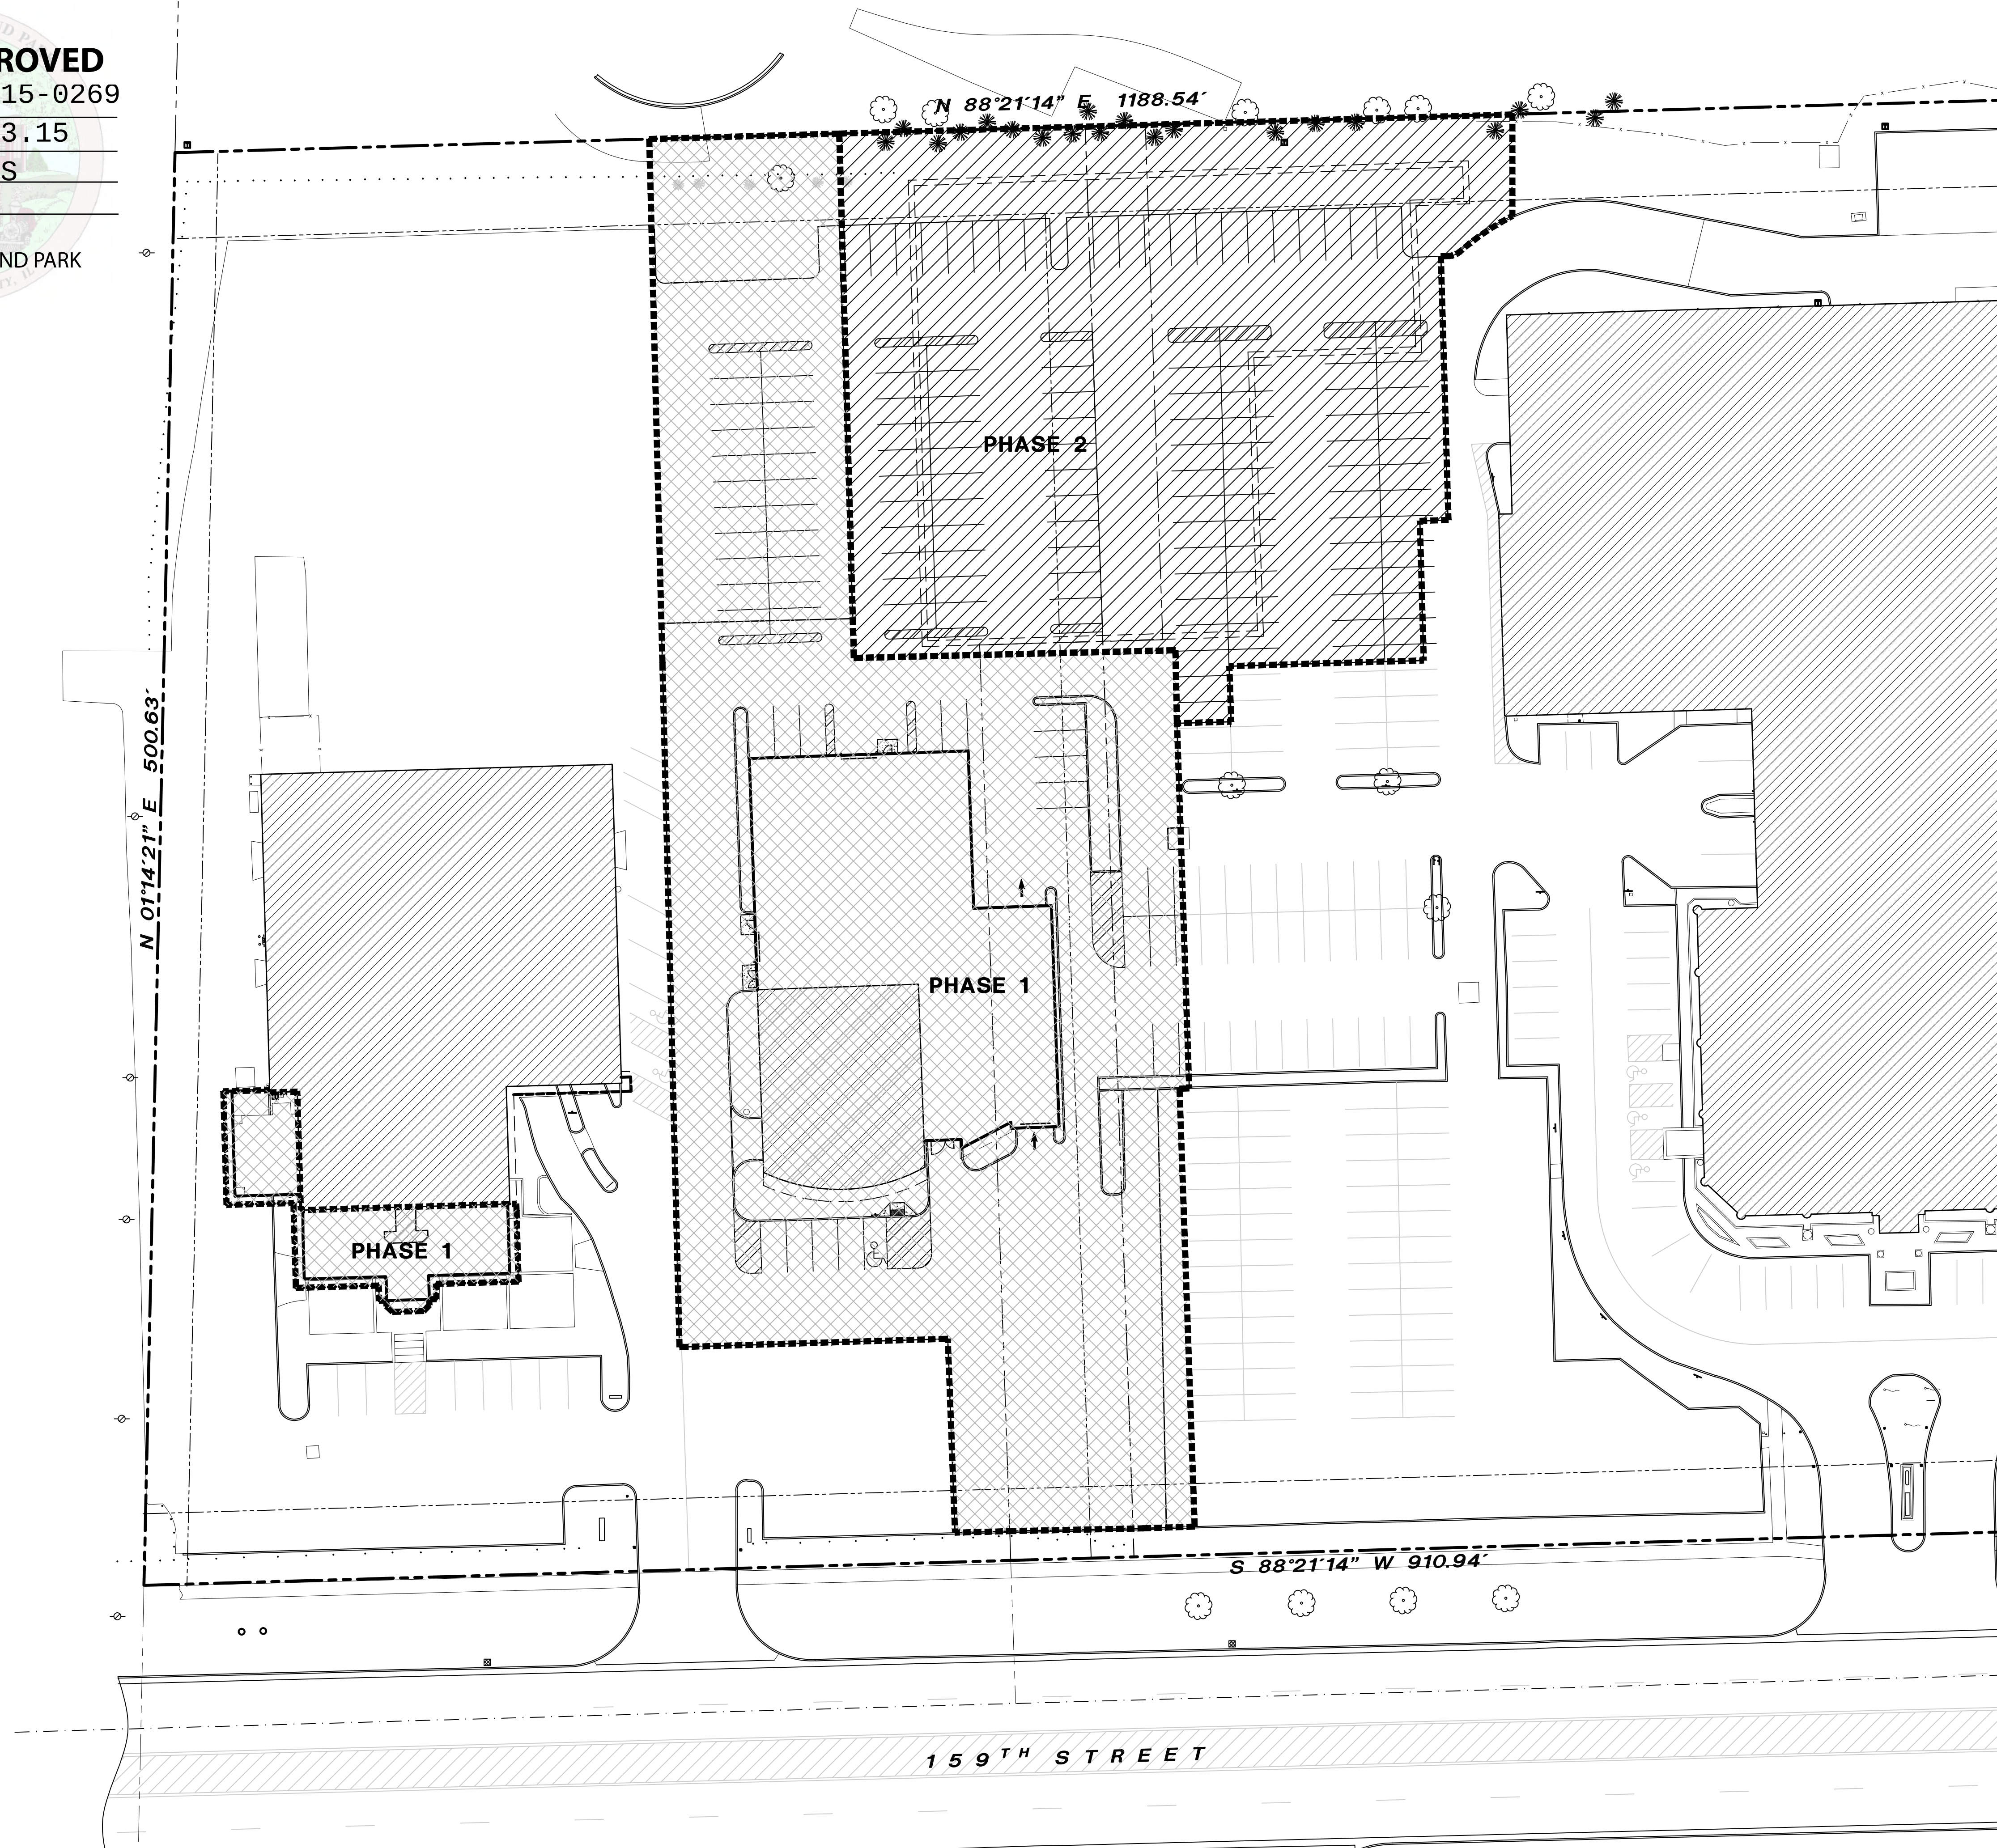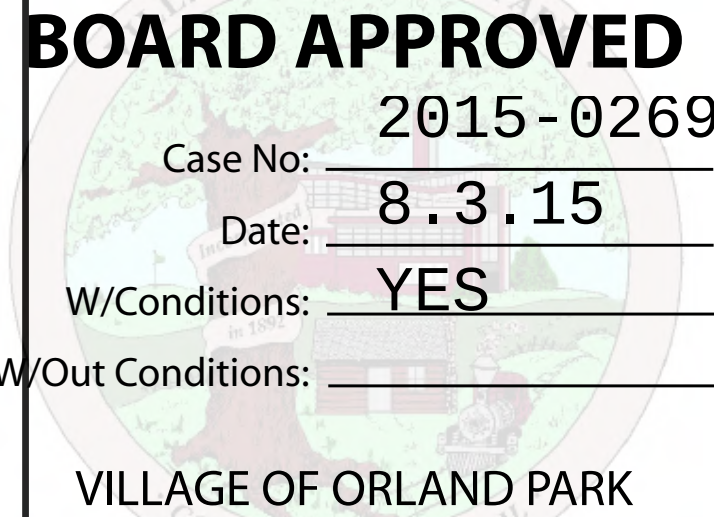

PHASE 1 IMPROVEMENTS

PHASE 2 IMPROVEMENTS

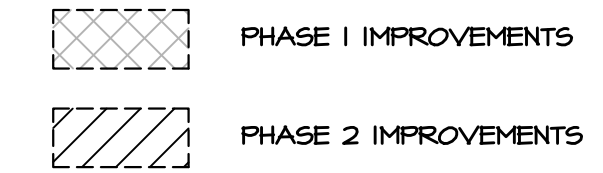

00 15 30 60 120

1" = 30'




| REVISIONS                              | DATE    | BY  |
|----------------------------------------|---------|-----|
| SUBMITTED FOR PRELIM. SITE PLAN REVIEW | 4-10-15 | ENK |
| PER VILLAGE COMMENTS                   | 6-17-15 | ENK |
|                                        |         |     |
|                                        |         |     |
|                                        |         |     |

**W-T CIVIL ENGINEERING, LLC.**  
**CIVIL AND STRUCTURAL ENGINEERS**

2675 Pratum Avenue  
Hoffman Estates, Illinois 60192  
PH: (224) 293-6333 FAX: (224) 293-6444  
[www.wtengineering.com](http://www.wtengineering.com)

IL License No.: 184-003492 Exp: 04/30/17

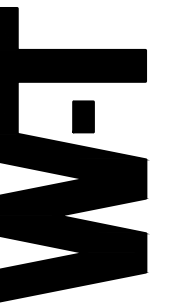

**RIZZA PORSCHE AND ACURA**  
8130 W. 159TH STREET  
ORLAND PARK, ILLINOIS 60462

# PHASING PLAN

|        |          |
|--------|----------|
| DATE:  | 4-10-15  |
| SCALE: | 1" = 30' |
| DRAWN: | SMN      |
| CHECK: | JLG      |
| JOB:   | CEI4145  |
| SHEET: |          |

## C-2.1

BOARD APPROVED

Case No: 2015-0269

Date: 8.3.15

W/Conditions: YES

W/Out Conditions:

VILLAGE OF ORLAND PARK



EXTERIOR RENDERING - PORSCHE01

SCALE: 1/8" = 1' - 0"

PROJECT:

JOE RIZZA

JOE RIZZA  
ACURA

Porsche Orland Park  
8130 W. 159th Street  
Orland Park, IL 60462

ACURA of Orland Park  
8150 W. 159th Street  
Orland Park, IL 60462

ARCHITECT:

SIMON

DESIGN GROUP, LLC

ARCHITECTURE  
DESIGN

planning - retail - automotive

505 Lake Cook Road, Suite 350  
Deerfield, IL 60015

Tel: 847-571-3814  
design@simon-arch.com

Civil Eng:

W-T Engineering

2675 Pratum Ave  
Hoffman Estates, IL 60192

Tel: 224-293-6333  
Fax: 224-293-6444  
Contact: Jon Grywa  
Em: Jon.Grzywa@wtengineering.com

APRIL 10, 2015 - PLANNING REVIEW

MAY 15, 2015 - DESIGN REVIEW

JUNE 29, 2015 - PLANNING REVIEW RESUBMIT

JULY 27, 2015 - BOARD REVIEW

EXTERIOR RENDERING -  
PORSCHE

A6.00

©2015 SIMON ARCH, LLC

BOARD APPROVED  
2015-0269

Case No: 8.3.15  
Date:

W/Conditions: YES

W/Out Conditions:

VILLAGE OF ORLAND PARK


TOP/NEW GLAZING  
ELEV. =8'-0" AFF

TOP/EXIST. SLAB  
ELEV. =8'-0" AFF

## EXTERIOR ELEVATION - SOUTH

SCALE: 1/8"


1

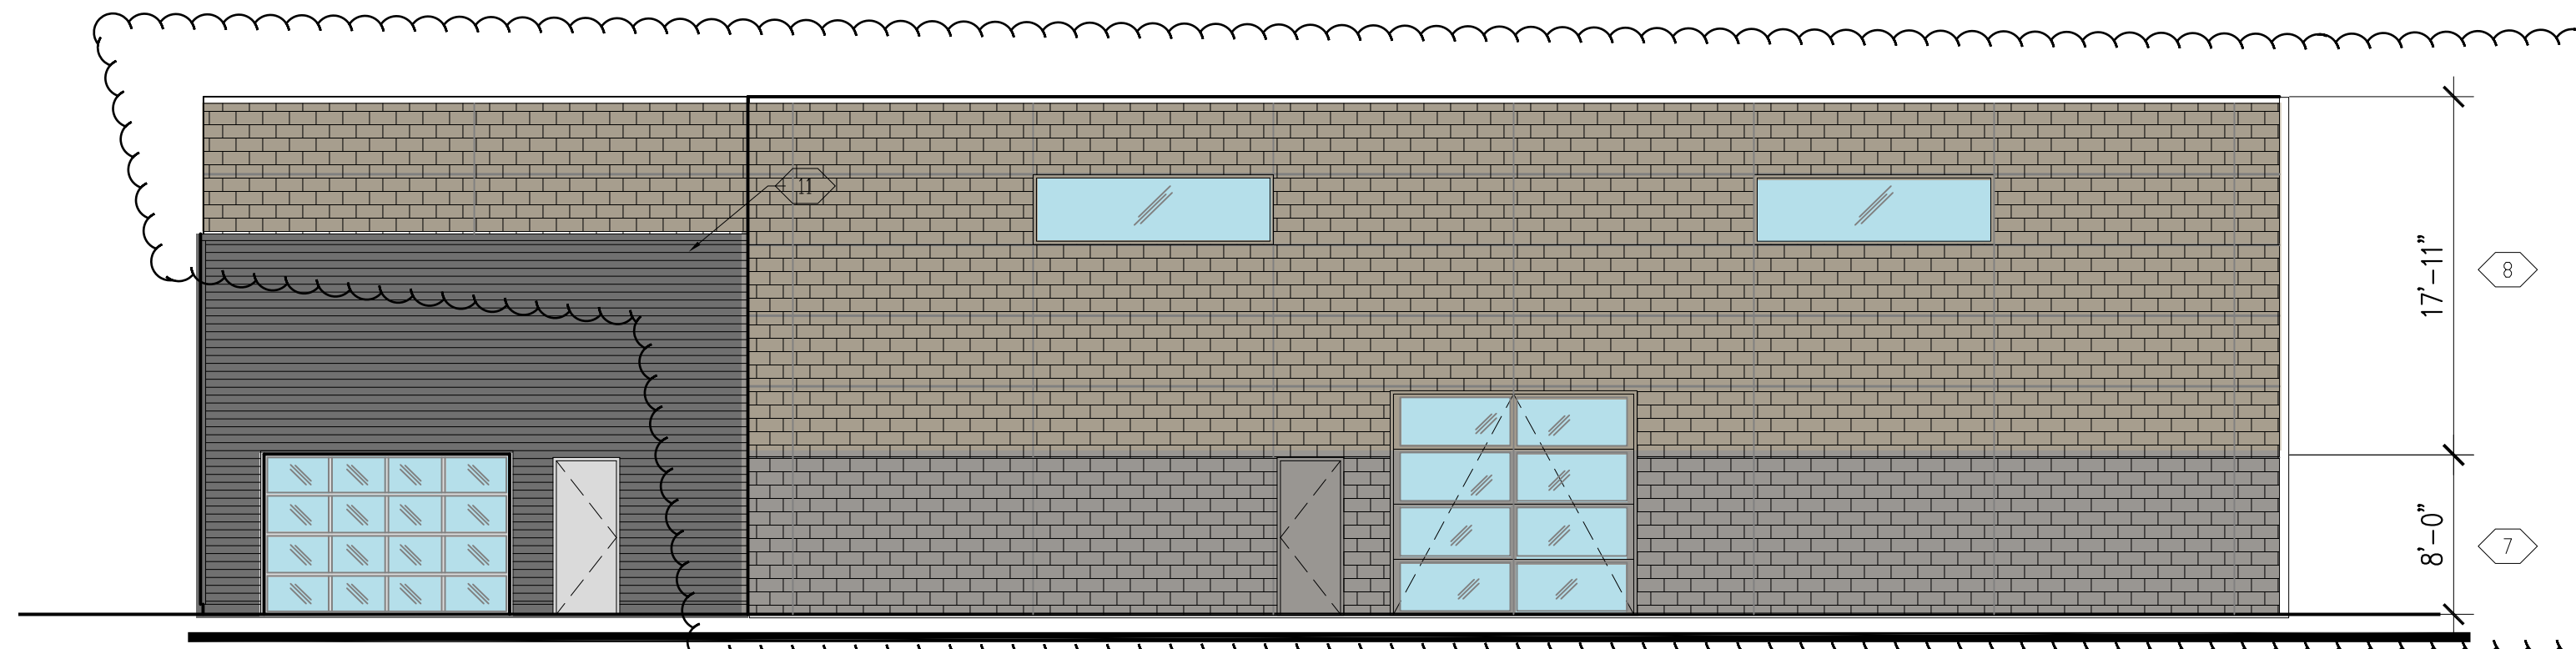

## EXTERIOR ELEVATION - NORTH

SCALE: 1/8"


2

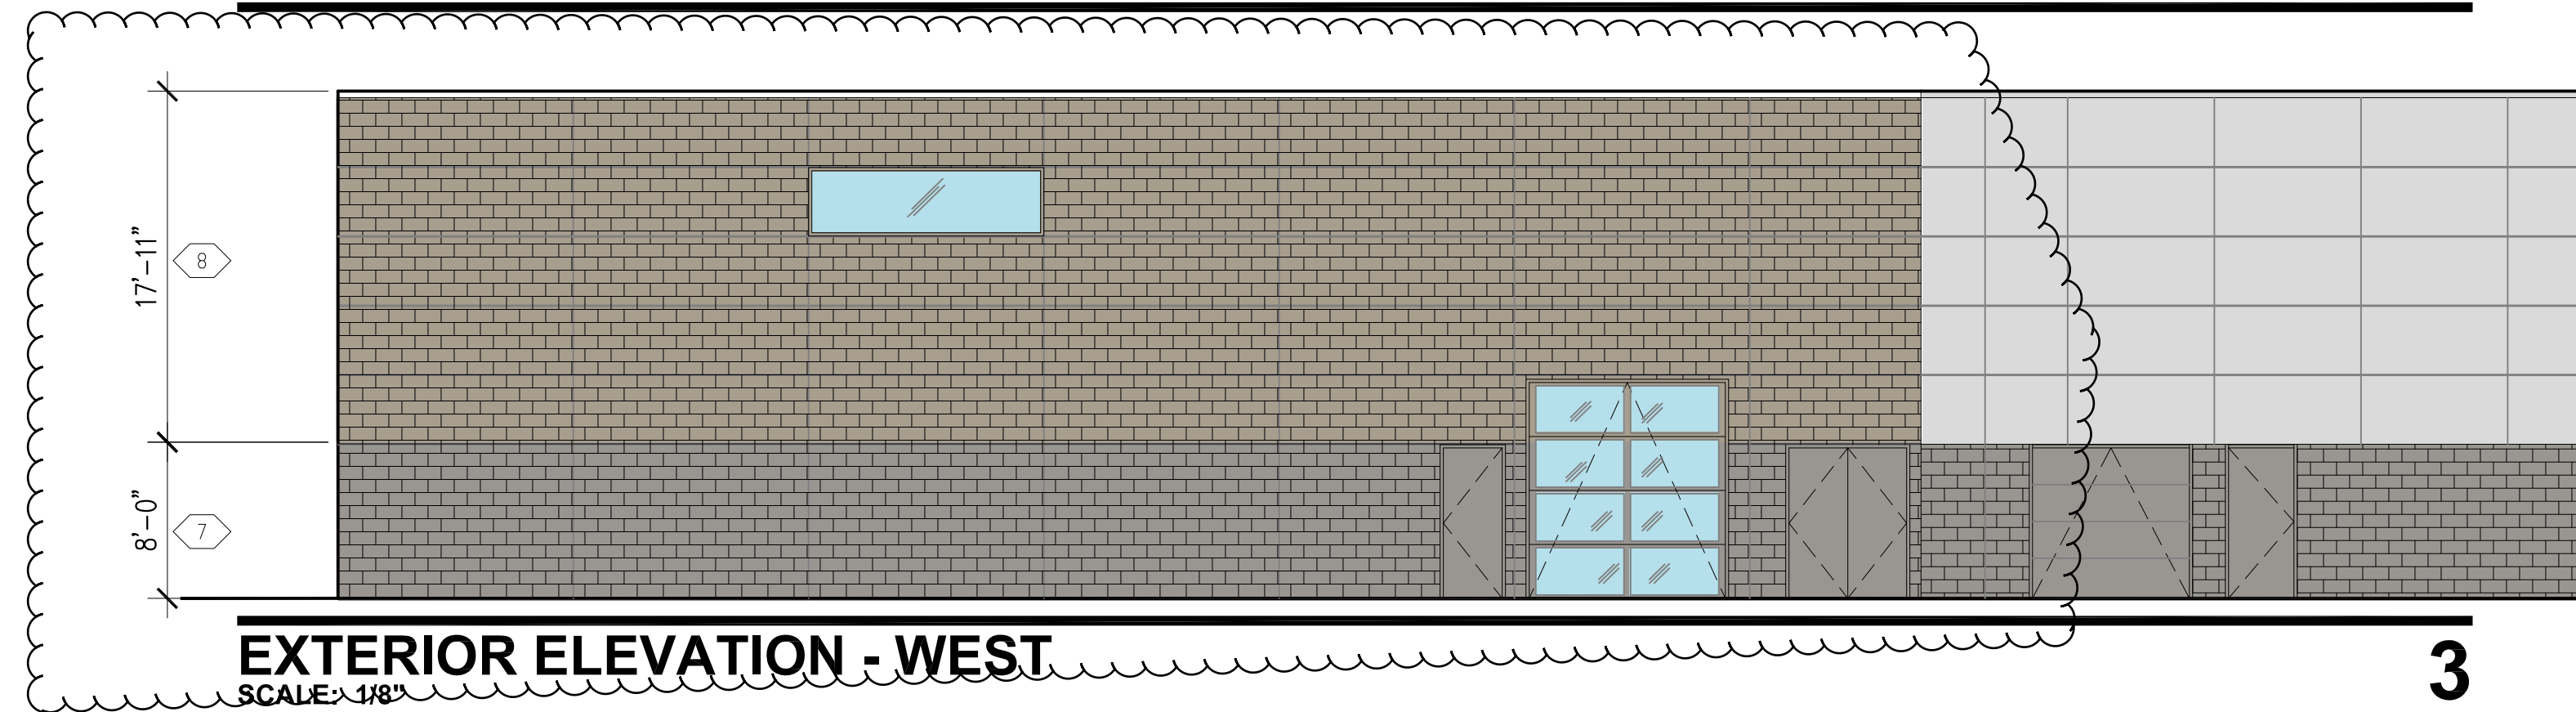

## EXTERIOR ELEVATION - WEST

SCALE: 1/8"

3

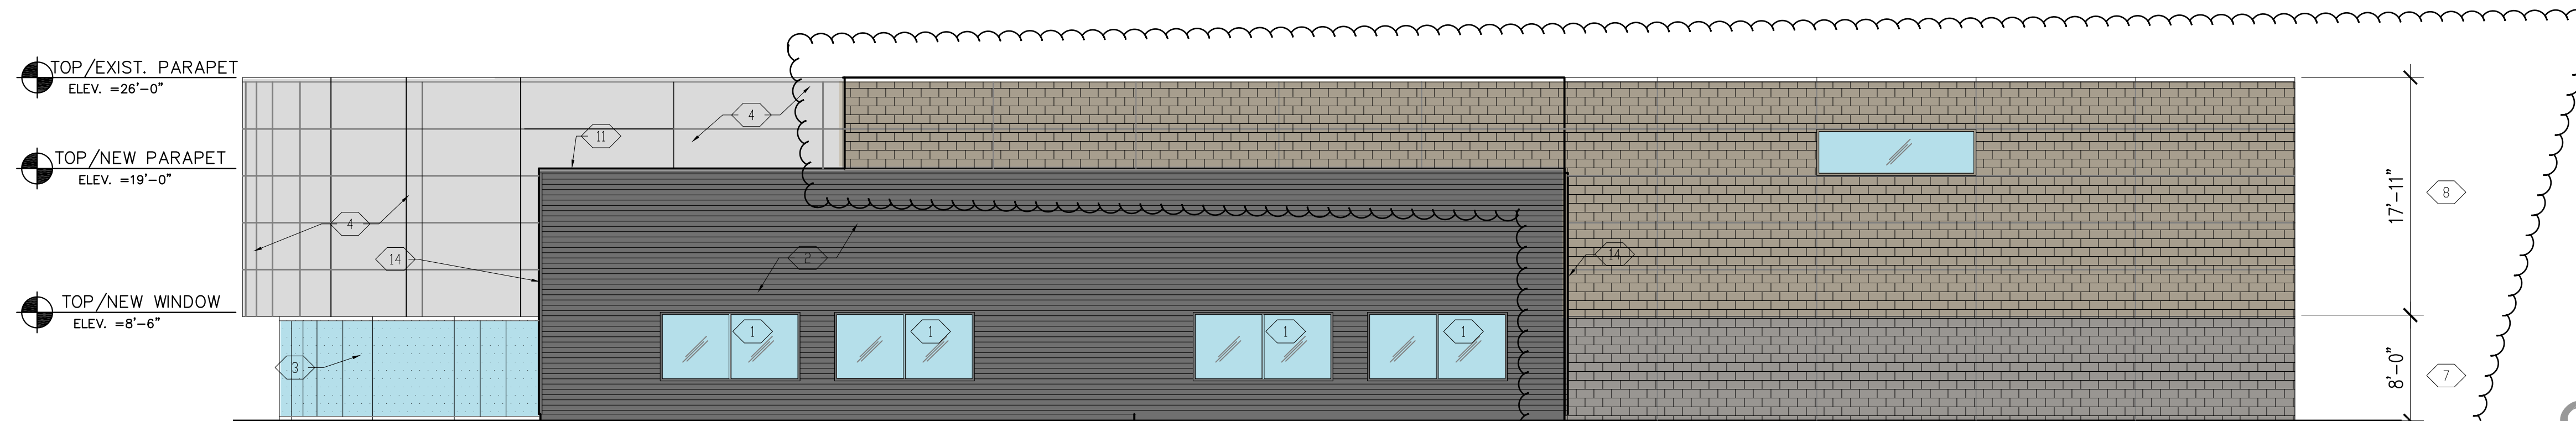

## EXTERIOR ELEVATION - EAST

SCALE: 1/8"

4

### ELEVATION KEY NOTES:

|    |                                                                                                                                                                            |
|----|----------------------------------------------------------------------------------------------------------------------------------------------------------------------------|
| 1  | BLACK ANODIZED ALUMINUM WINDOW. SEE SCH1.                                                                                                                                  |
| 2  | MP1: TRAPEZIUM SHEET METAL. 0.8MM, SYMMETRICAL, CORRUGATED, ENAMELED, W/ MATTE BLACK FINISH.                                                                               |
| 3  | EXTERIOR BUTT-JOINT GLAZING FROM FINISHED FLOOR TO 8'-0" A.F.F. SEE A10 AND SCH1 FOR MORE INFO.                                                                            |
| 4  | EXISTING METAL PANELS TO REMAIN                                                                                                                                            |
| 5  | 10'-0" x 8'-0" POWER OPERATED BLACK ANODIZED ALUMINUM OVERHEAD SECTIONAL GARAGE DOOR WITH GLAZING. MOUNT CONTROL WHERE SWITCH IS INDICATED. SEE SCH1 FOR MORE INFORMATION. |
| 6  | 8'-0" x 8'-0" BLACK ANODIZED ALUMINUM ENTRY DOOR. SEE SCH1 FOR MORE INFORMATION.                                                                                           |
| 7  | GROUND CMU-1 TO MATCH ADJACENT/EXISTING (GREY)                                                                                                                             |
| 8  | SPLIT FACE CMU-2 TO MATCH ADJACENT/EXISTING (SANDY BEIGE)                                                                                                                  |
| 9  | SIGNAGE TO BE FURNISHED AND INSTALLED BY OTHERS - PROVIDE POWER, SEE ELECTRICAL DRAWINGS.                                                                                  |
| 10 | SIGNAGE BY SIGN VENDOR (TO BE SUBMITTED BY VENDOR)                                                                                                                         |
| 11 | METAL COPING - COLOR TO MATCH TRAPEZIUM SHEET METAL                                                                                                                        |
| 12 | EXISTING OVERHEAD GARAGE DOORS                                                                                                                                             |
| 13 | POWER WASH EXISTING GROUND FACE CMU PRIOR TO PAINTING. SEE A40 FOR PAINT INFORMATION.                                                                                      |
| 14 | METAL CORNER TRIM BY METAL PANEL MANUFACTURER. COLOR AND FINISH TO MATCH TRAPEZIUM METAL PANELS                                                                            |
| 17 | BUTT GLAZED WITH BLACK MULLIONS, WITH DARK-TINTED GLAZING                                                                                                                  |

### EXTERIOR MATERIAL SCHEDULE

| ID    | DESCRIPTION               | MANUFACTURER       | SPECIFICATION                                                                                         | SOURCE/CONTACT                                       | REMARKS/ADD'L INFO.                                                                                                                                                       |
|-------|---------------------------|--------------------|-------------------------------------------------------------------------------------------------------|------------------------------------------------------|---------------------------------------------------------------------------------------------------------------------------------------------------------------------------|
| MP1   | TRAPEZIUM MTL PANELS      | ATAS INTERNATIONAL | TRAPEZIUM SHEET METAL 0.8MM, SYMMETRICAL, CORRUGATED, ENAMELED, W/ MATTE BLACK FINISH, SMOOTH TEXTURE | MARK BROWN AT ATAS INTERNATIONAL (800) 468-1441 X227 | PROVIDE CORNER, TRIM AND ANY OTHER MTL ACCESSORIES AND FLASHINGS AS NECESSARY TO ACHIEVE UNEXPOSED EDGES AT CORNERS, WINDOW & DOOR OPENINGS, ETC. FINISH TO MATCH PANELS. |
| GFM-1 | GROUND FACE MASONRY UNITS | TRENWYTH           | MESASTONE COLOR: HAYDITE                                                                              | TRENWYTH (630) 894-1629                              | PROVIDE SAMPLE FOR APPROVAL, TO MATCH EXISTING.                                                                                                                           |
| GFM-2 | GROUND FACE MASONRY UNITS | TRENWYTH           | TRENDSTONE PLUS COLOR: HAYDITE                                                                        | TRENWYTH (630) 894-1629                              | PROVIDE SAMPLE FOR APPROVAL, TO MATCH EXISTING.                                                                                                                           |

TOP/EXIST. PARAPET  
ELEV. =26'-0"

TOP/NEW PARAPET  
ELEV. =19'-0"

TOP/NEW WINDOW  
ELEV. =8'-6"


PROJECT:

**JOE RIZZA**



Porsche Orland Park  
8130 W. 159th Street  
Orland Park, IL 60462

ARCHITECT:

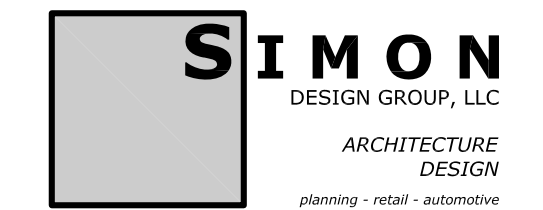

505 Lake Cook Road, Suite 350  
Deerfield, IL 60015

Tel: 847-571-3814  
design@simon-arch.com

JULY 22, 2015 - DESIGN REVIEW

JULY 27, 2015 - BOARD REVIEW

EXT.ELEVATIONS

**A06.01**

©2015 SIMON ARCH, LLC

BOARD APPROVED

Case No: 2015-0269

Date: 8.3.15

W/Conditions: YES

W/Out Conditions:

VILLAGE OF ORLAND PARK



EXTERIOR RENDER - ACURA

SCALE: -

01

PROJECT:

JOE RIZZA



Porsche Orland Park  
8130 W. 159th Street  
Orland Park, IL 60462

JOE RIZZA  
ACURA



ACURA of Orland Park  
8150 W. 159th Street  
Orland Park, IL 60462

ARCHITECT:



SIMON

DESIGN GROUP, LLC

ARCHITECTURE  
DESIGN

planning - retail - automotive

505 Lake Cook Road, Suite 350  
Deerfield, IL 60015

Tel: 847-571-3814  
design@simon-arch.com

Civil Eng:

*W-T Engineering*

2675 Pratum Ave  
Hoffman Estates, IL 60192

Tel: 224-293-6333  
Fax: 224-293-6444  
Contact: Jon Grywa  
Em: Jon.Grzywa@wtengineering.com

APRIL 10, 2015 - PLANNING REVIEW

MAY 15, 2015 - DESIGN REVIEW

JUNE 29, 2015 - PLANNING REVIEW RESUBMIT

JULY 27, 2015 - BOARD REVIEW

ISSUED FOR PRELIM SITE PLAN REVIEW - APRIL 10, 2015

EXTERIOR RENDERING -  
ACURA

A6.10

©2015 SIMON ARCH, LLC

**BOARD APPROVED**  
Case No: 2015-0269  
Date: 8.3.15  
W/Conditions: YES  
W/Out Conditions:

VILLAGE OF ORLAND PARK

SIGN TO BE SUBMITTED BY Acura VENDOR

EG-2

CM-2  
CM-1

EIFS-1

5  
TYP

EG-1  
SIGN TO BE SUBMITTED BY Acura VENDOR

2  
TYP

A  
E-8

B  
E-8

EG-3

C  
E-8

SF-1  
TYP

3  
TYP

SF-1  
TYP

9  
TYP

6  
TYP

1  
E-7

## FRONT ELEVATION

SF-1

CM-1

5  
TYP

CM-2

2  
TYP

EIFS-1

8

10  
TYP

EP-1

ED-1

3  
TYP

SF-1  
TYP

ED-1

4

11  
TYP

6  
TYP

6

2  
E-7

## RIGHT ELEVATION

EP-1

10  
TYP

EIFS-1

2  
TYP

CM-1

5  
TYP

CM-2

SF-1

6  
TYP

6  
TYP

11

9  
TYP

4

ED-1  
TYP

SF-1  
TYP

3  
TYP

ED-1

3  
E-7

## LEFT ELEVATION

### GENERAL NOTES

- A. ELEVATIONS NOT SHOWN SHALL RECEIVE SAME OR COMPLEMENTARY FINISHES TO MATERIALS SHOWN.  
B. SEE LIGHT FIXTURE SCHEDULE FOR EXTERIOR LIGHTING DESCRIPTION.

### DRAWING NOTES

- ENTRY ICON. SEE SHEET E-9 FOR MORE INFORMATION.
- EIFS REVEAL JOINT - SEE DETAIL E/E-8
- EXTERIOR LIGHTING FIXTURE. SEE LIGHTING SCHEDULE FOR DESCRIPTION.
- VEHICLE ACCESS DOORS (1) TO BE 5'-0" W X 7'-0" H THE OTHER TO BE 3'-0" W X 7'-0" H
- EIFS REVEAL JOINT - SEE DETAIL D/E-8.
- EXISTING DOOR.
- CLEAN EXISTING EIFS. PATCH AND REPAIR AS REQUIRED AND REAPPLY EIFS PER ORIGINAL SPECIFICATIONS.
- CLEAN AND REFURBISH EXISTING ACM PANELS TO ORIGINAL CONDITION.
- CLEAN EXISTING LIGHTS. SEE LIGHTING SCHEDULE FOR ADDITIONAL INFORMATION.
- EXISTING WINDOW.
- PAINTED FACE BRICK. COLOR TO MATCH EIFS-2 BELOW SILL, EIFS -1 ABOVE SILL

PROJECT:

**JOE RIZZA**




Porsche Orland Park  
8130 W. 159th Street  
Orland Park, IL 60462



ACURA of Orland Park  
8150 W. 159th Street  
Orland Park, IL 60462

ARCHITECT:

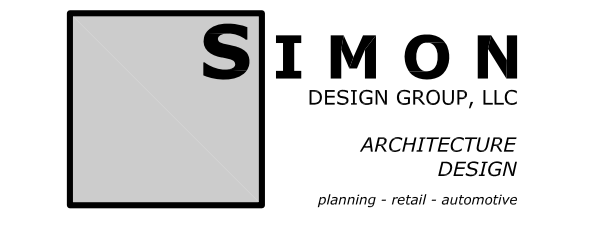

505 Lake Cook Road, Suite 350  
Deerfield, IL 60015

Tel: 847-571-3814  
design@simon-arch.com

Civil Eng:

**W-T Engineering**

2675 Pratum Ave  
Hoffman Estates, IL 60192

Tel: 224-293-6333  
Fax: 224-293-6444  
Contact: Jon Grywa  
Em: Jon.Grzywa@wtengineering.com

APRIL 10, 2015 - PLANNING REVIEW

MAY 15, 2015 - DESIGN REVIEW

JUNE 29, 2015 - PLANNING REVIEW RESUBMIT

 
JULY 27, 2015 - BOARD REVIEW

ISSUED FOR PRELIM SITE PLAN REVIEW - APRIL 10, 2015


EXT ELEV - ACURA

# A6.11

©2015 SIMON ARCH, LLC



| CODE   | ITEM                                                               | LOCATION                         | MANUFACTURER                         | DESCRIPTION                |                                                                               |                   | ADDITIONAL INFORMATION                                                                                                                                                                                                                |
|--------|--------------------------------------------------------------------|----------------------------------|--------------------------------------|----------------------------|-------------------------------------------------------------------------------|-------------------|---------------------------------------------------------------------------------------------------------------------------------------------------------------------------------------------------------------------------------------|
|        |                                                                    |                                  |                                      | SERIES                     | COLOR                                                                         | DIMENSIONS        |                                                                                                                                                                                                                                       |
| BP-1   | BRICK BRICK PAVERS                                                 | EXTERIOR ENTRANCE/ MAIN ENTRANCE | HANOVER ARCHITECTURAL PRODUCTS, INC. | TRADITIONAL PREST          | LIMESTONE GREY                                                                | 12"x12"           | CONTACT: HANOVER ARCHITECTURAL (717) 637-0500                                                                                                                                                                                         |
| CM-1   | COMPOSITE METAL PANEL OPTION 1                                     | EXTERIOR FACADE                  | ALUCOBOND                            | PE STOCKING COLORS         | CHAMPAGNE METALLIC                                                            | SEE ELEVATIONS    | CONTACT: MIKE CALDWELL AT ALUCOBOND (770) 982-5822 OR (470) 554-2651                                                                                                                                                                  |
|        | COMPOSITE METAL PANEL OPTION 2                                     | EXTERIOR FACADE                  | REYNOBOND                            | COLORWELD 500 XL           | CHAMPAGNE METALLIC                                                            | SEE ELEVATIONS    | CONTACT: DUTCH JUEDEMAN AT REYNOBOND (478) 319-0139 OR (770) 695-0973                                                                                                                                                                 |
|        | COMPOSITE METAL PANEL OPTION 3                                     | EXTERIOR FACADE                  | ALPOLIC                              |                            | 4MM4CMX3.5<br>MTLC CHMPGN                                                     | SEE ELEVATIONS    | CONTACT: DAVID J. KEARNEY AT ALPOLIC (757) 382-5724 OR (757) 286-1005                                                                                                                                                                 |
| CM-2   | COMPOSITE METAL PANEL OPTION 1                                     | EXTERIOR FACADE                  | ALUCOBOND                            |                            | BN3L121B DURANAR XL SPIRE BLUE II<br>10570 WITH 614C3030                      | SEE ELEVATIONS    | CONTACT: MIKE CALDWELL AT ALUCOBOND (770) 982-5822 OR (470) 554-2651                                                                                                                                                                  |
|        | COMPOSITE METAL PANEL OPTION 2                                     | EXTERIOR FACADE                  | REYNOBOND                            |                            | MIDNIGHT BLUE<br>COLOR: TO MATCH PMS 282C                                     | SEE ELEVATIONS    | CONTACT: DUTCH JUEDEMAN AT REYNOBOND (478) 319-0139 OR (770) 695-0973                                                                                                                                                                 |
|        | COMPOSITE METAL PANEL OPTION 3                                     | EXTERIOR FACADE                  | ALPOLIC                              |                            | 4MM4AUB3.5, AUB BLUE<br>COLOR: TO MATCH PMS 282C                              | SEE ELEVATIONS    | CONTACT: DAVID J. KEARNEY AT ALPOLIC (757) 382-5724 OR (757) 286-1005                                                                                                                                                                 |
| CONC-1 | CONCRETE                                                           | EXTERIOR FACADE                  | SCOFIELD SYSTEMS                     | LITHOCHROME COLOR HARDENER | A-21 DEEP CHARCOAL                                                            |                   | CONTACT: ROBERT E. KRAUSKOPF AT L.M. SCOFIELD COMPANY (800) 800-9900<br>NOTE: CONTACT MANUFACTURER TO OBTAIN RECOMMENDED CURING AGENT & SEALER FOR APPLICATION                                                                        |
| CONC-2 | CONCRETE                                                           | EXTERIOR FACADE                  | SCOFIELD SYSTEMS                     | LITHOCHROME COLOR HARDENER | A-26 BRICK RED                                                                |                   |                                                                                                                                                                                                                                       |
| CT-1   | CERAMIC TILE                                                       | FOUNTAIN WALLS                   | BUCHTAL                              | CHROMA 2                   | 539 MEDIUM GRAY                                                               | 8 X 8             | CONTACT: LORI RING AT HAMILTON PARKER (614) 778-1491                                                                                                                                                                                  |
| *ED-1  | STOREFRONT DOOR                                                    |                                  | KAWNEER OR EQUAL                     | NARROW STILE               | COLOR TO MATCH CM-1                                                           |                   |                                                                                                                                                                                                                                       |
| ED-2   | HOLLOW METAL DOOR                                                  | SEE A3.01                        | REF: DOOR SCHEDULE                   |                            | EXTERIOR FINISH: PAINT EP-1 INTERIOR FINISH: PAINT P-1, SEE INTERIOR SCHEDULE |                   |                                                                                                                                                                                                                                       |
| ED-3   | OVERHEAD DOOR                                                      | SEE A3.01                        | REF: DOOR SCHEDULE                   |                            | PAINT EP-1                                                                    | * SIZE VARIES     | CONSULT DEALER FOR REQUIRED SIZE                                                                                                                                                                                                      |
| ED-4   | PARTS OVERHEAD DOOR                                                | SEE A3.01                        | REF: DOOR SCHEDULE                   |                            |                                                                               | 8 X 10H           |                                                                                                                                                                                                                                       |
| ED-5   | GLASS AND ALUMINUM OVERHEAD DOOR                                   | SERVICE & RECEPTION              | KAWNEER OR EQUAL                     |                            | MULLIONS TO MATCH SF-1                                                        | REFER TO DOOR SCH |                                                                                                                                                                                                                                       |
| EIFS-1 | EXTERIOR INSULATING FINISH SYSTEM ON 2" INSULATION ON DRAINAGE MAT | FIELD/EXTERIOR WALLS             | DRYVIT                               | AMERISTONE                 | AHC011100 WHITE ASH                                                           |                   | CONTACT: BOB DAZEL AT DRYVIT NATIONAL ACCOUNTS (734) 276-0404                                                                                                                                                                         |
| EIFS-2 | EXTERIOR INSULATING FINISH SYSTEM ON 2" INSULATION ON DRAINAGE MAT | BASE BAND, EXTERIOR WALLS        | DRYVIT                               | QUARZPUTZ                  | AHC021020 KING'S GRAY                                                         |                   | CONTACT: BOB DAZEL AT DRYVIT NATIONAL ACCOUNTS (734) 276-0404<br>*NOTE: MINOR COLOR VARIANTS WILL OCCUR DUE TO THE NATURAL AGGREGATES USED. FINAL SELECTION TO BE MADE FROM CONTRACTOR-SUBMITTED SAMPLES. ALLOW 3 TO 6 WEEK LEADTIME. |
| *EP-1  | EXTERIOR PAINT                                                     | SEE SHEET A3.01                  | SHERWIN WILLIAMS                     |                            | SW-1015 SKYLINE STEEL                                                         |                   | CONTACT: DAVE RYAN (317) 714-5610<br>NOTE: CONSULT MANUFACTURER FOR APPROPRIATE PRIMER AND GRADE OF PAINT FOR THE APPLICABLE SUBSTRATE.                                                                                               |
| MC-1   | METAL COPING                                                       |                                  | BY ARCHITECT OF RECORD               |                            | COLOR AND FINISH TO MATCH CM-1                                                |                   |                                                                                                                                                                                                                                       |
| SF-1   | STOREFRONT                                                         | SHOWROOM AREA                    | OLD CASTLE OR EQUAL                  | OLD CASTLE FG 3000 SYSTEM  | CHAMPAIGN MULLION COLOR TO MATCH CM-1                                         |                   | INSULATED STOREFRONT SYSTEM - 2X4.5 CENTERSET MULLIONS, LOW-E ON 3RD FACE.                                                                                                                                                            |

 

©2015 SIMON ARCH, LLC